


HEATING KEY	
Ⓜ	WALL MOUNTED TEMPERATURE CONTROLLER
▬	UNDERFLOOR HEATING MANIFOLD
BLR	GAS FIRED BOILER
●	FLOOR SENSOR

LIGHTING KEY	
⊠	HEAT DETECTOR
⊞	EXTRACT FAN
⊞	SMOKE DETECTOR
⊗	LIGHTING
⊗	SPOT LIGHT
⊗	PENDANT
⊗	WALL MOUNTED LIGHT
⊗	EMERGENCY SPOT LIGHT
⊗	EXTERNAL WALL MOUNTED LIGHT WITH DUSK TO DAWN SENSOR
⊞	DOUBLE SOCKET
⊞	SINGLE SOCKET
⊞	BATHROOM SOCKET

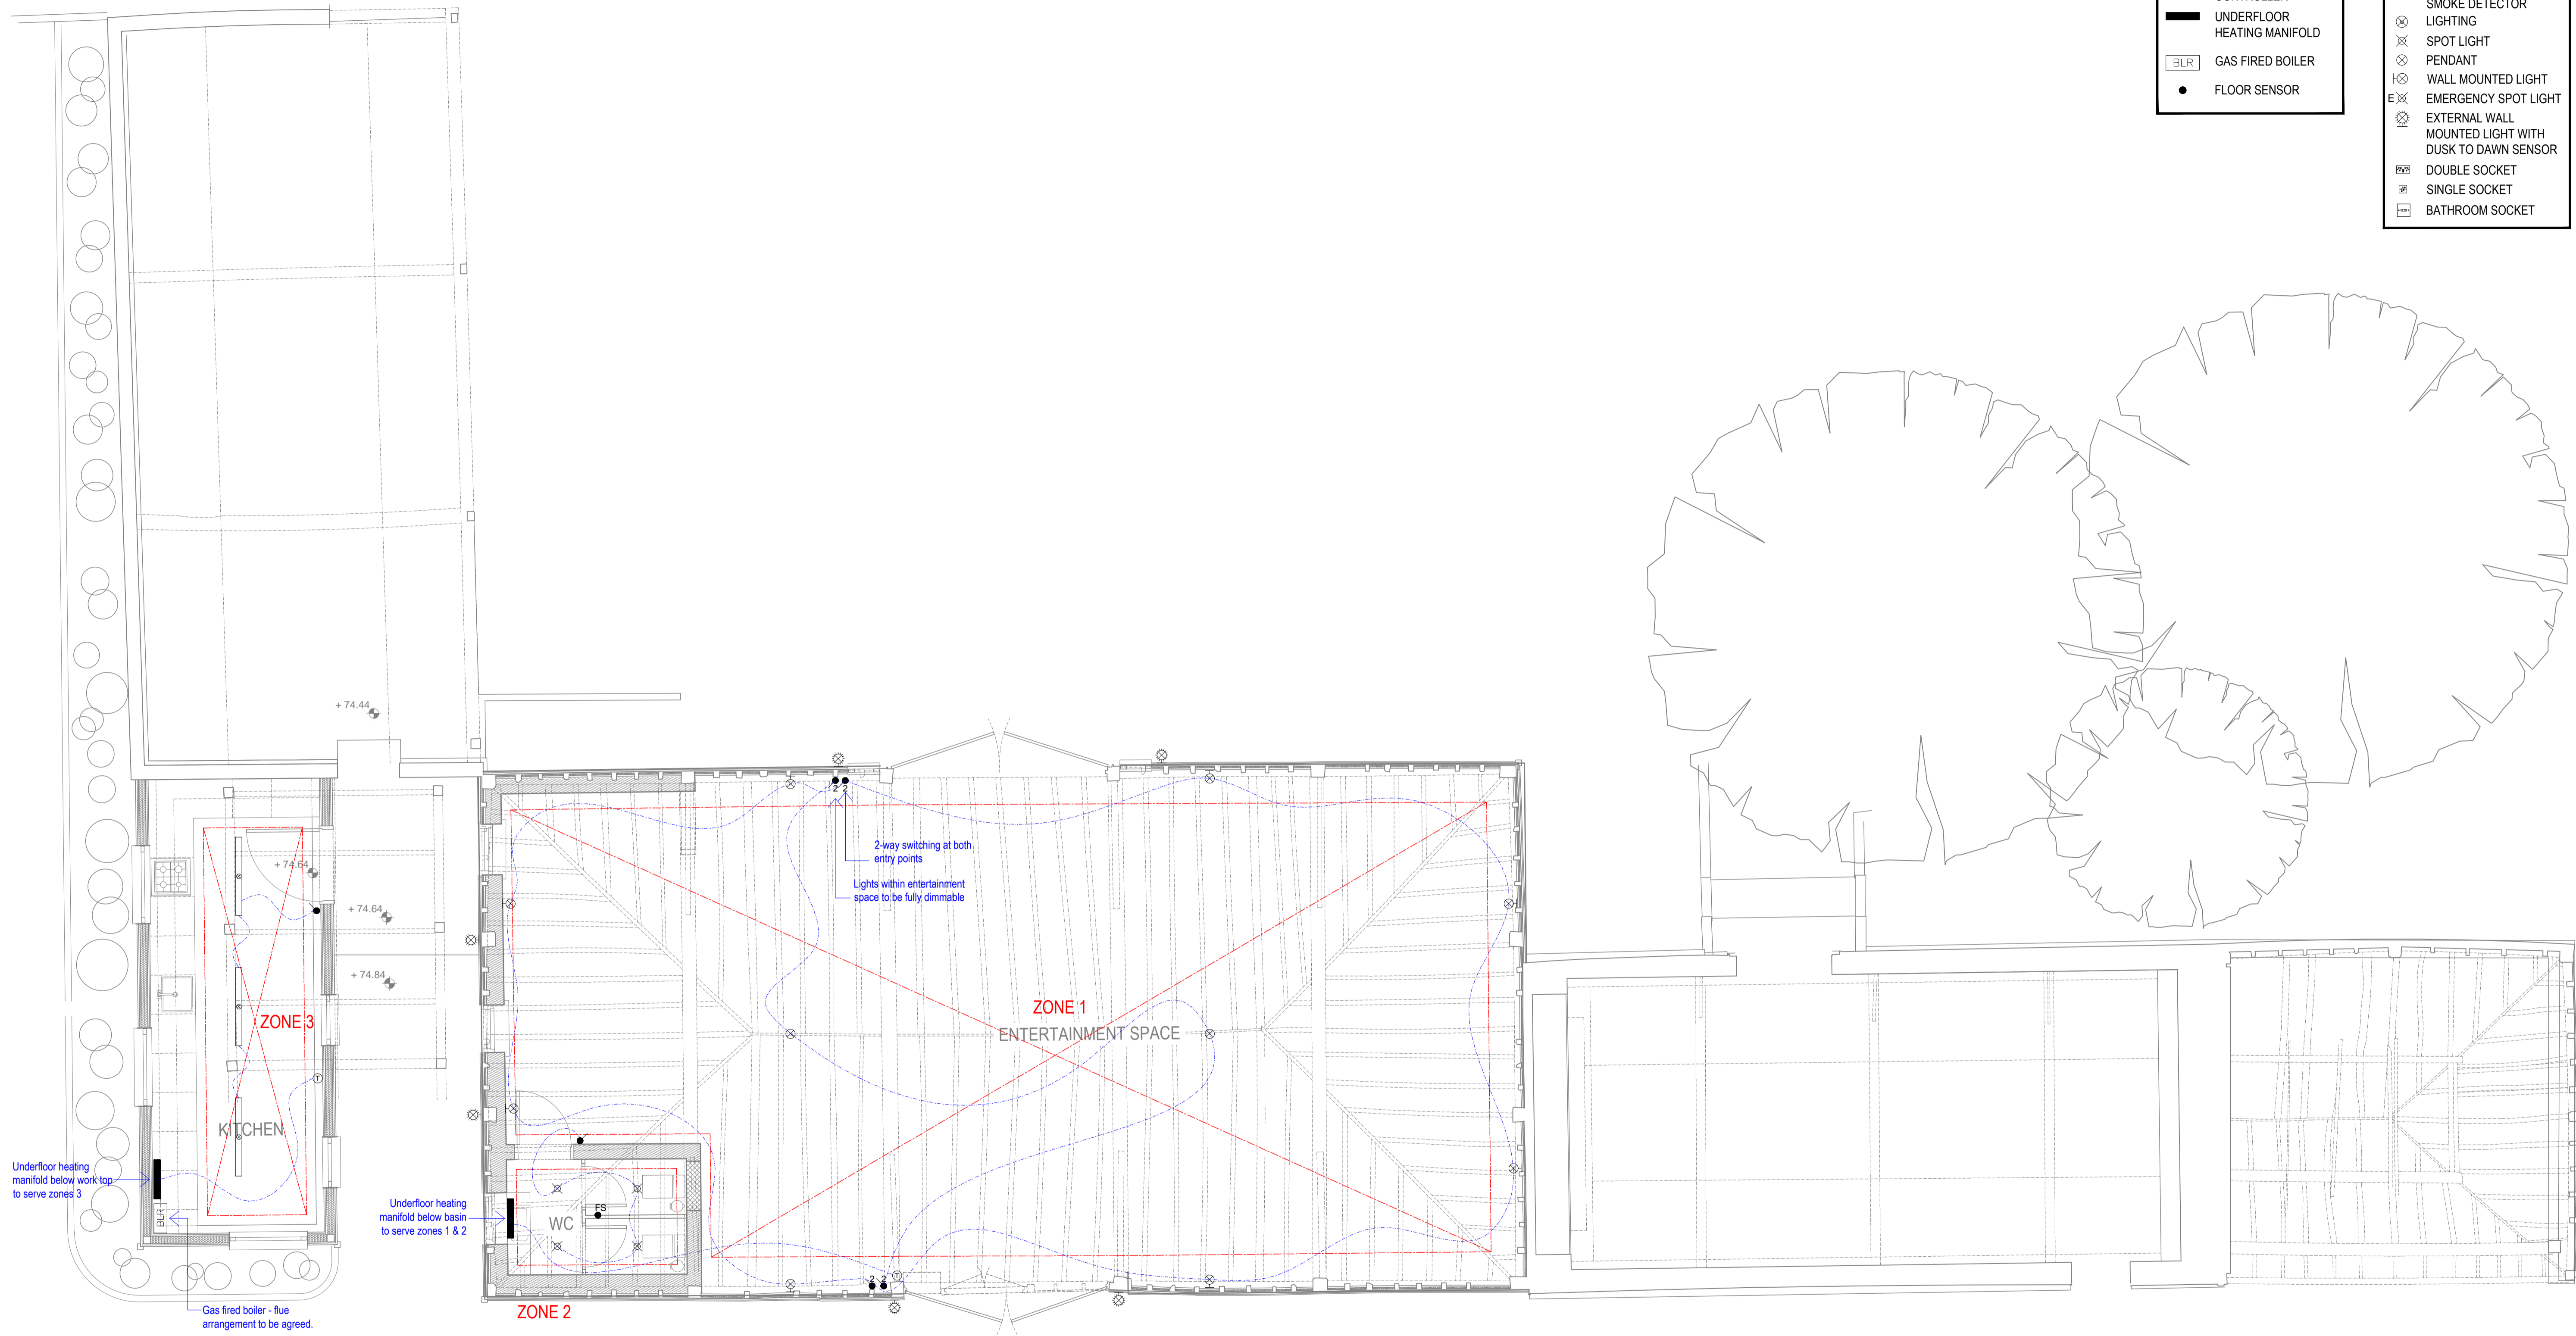

NOTE:
DO NOT SCALE FROM DRAWINGS - EXCEPT FOR PLANNING PURPOSES.
ALL DISCREPANCIES TO BE REPORTED TO ARCHITECT IMMEDIATELY.
ALL DIMENSIONS TO BE VERIFIED BY CONTRACTOR ON SITE PRIOR TO THE COMMENCEMENT OF ANY WORKS.

DOC 13/07/16 Issue for discharge of conditions

ISO-A1	VIVENDI ARCHITECTS LTD		CLIENT	STATUS
	Unit E3U, Bounds Green Industrial Estate, Ringway, London N11 2UD		PRIVATE CLIENT	DOC
	Tel/Fax +44 (0)20 3232 4000			SCALE AT A1:
	© Vivendi Architects Ltd 2016. All rights reserved. Nothing to be published in the Copyright, Design and Patents Act 1988.			1:50
PROJECT TITLE		JOB AND DRAWING NO.		REVISION:
GREAT NAST HYDE HOUSE, WILKIN'S GREEN LANE, HATFIELD AL10 9RB		1630-ME01-00		BR1
DRAWING TITLE				
Proposed Heating and Lighting Plan				