



Site Plan. Scale 1:100

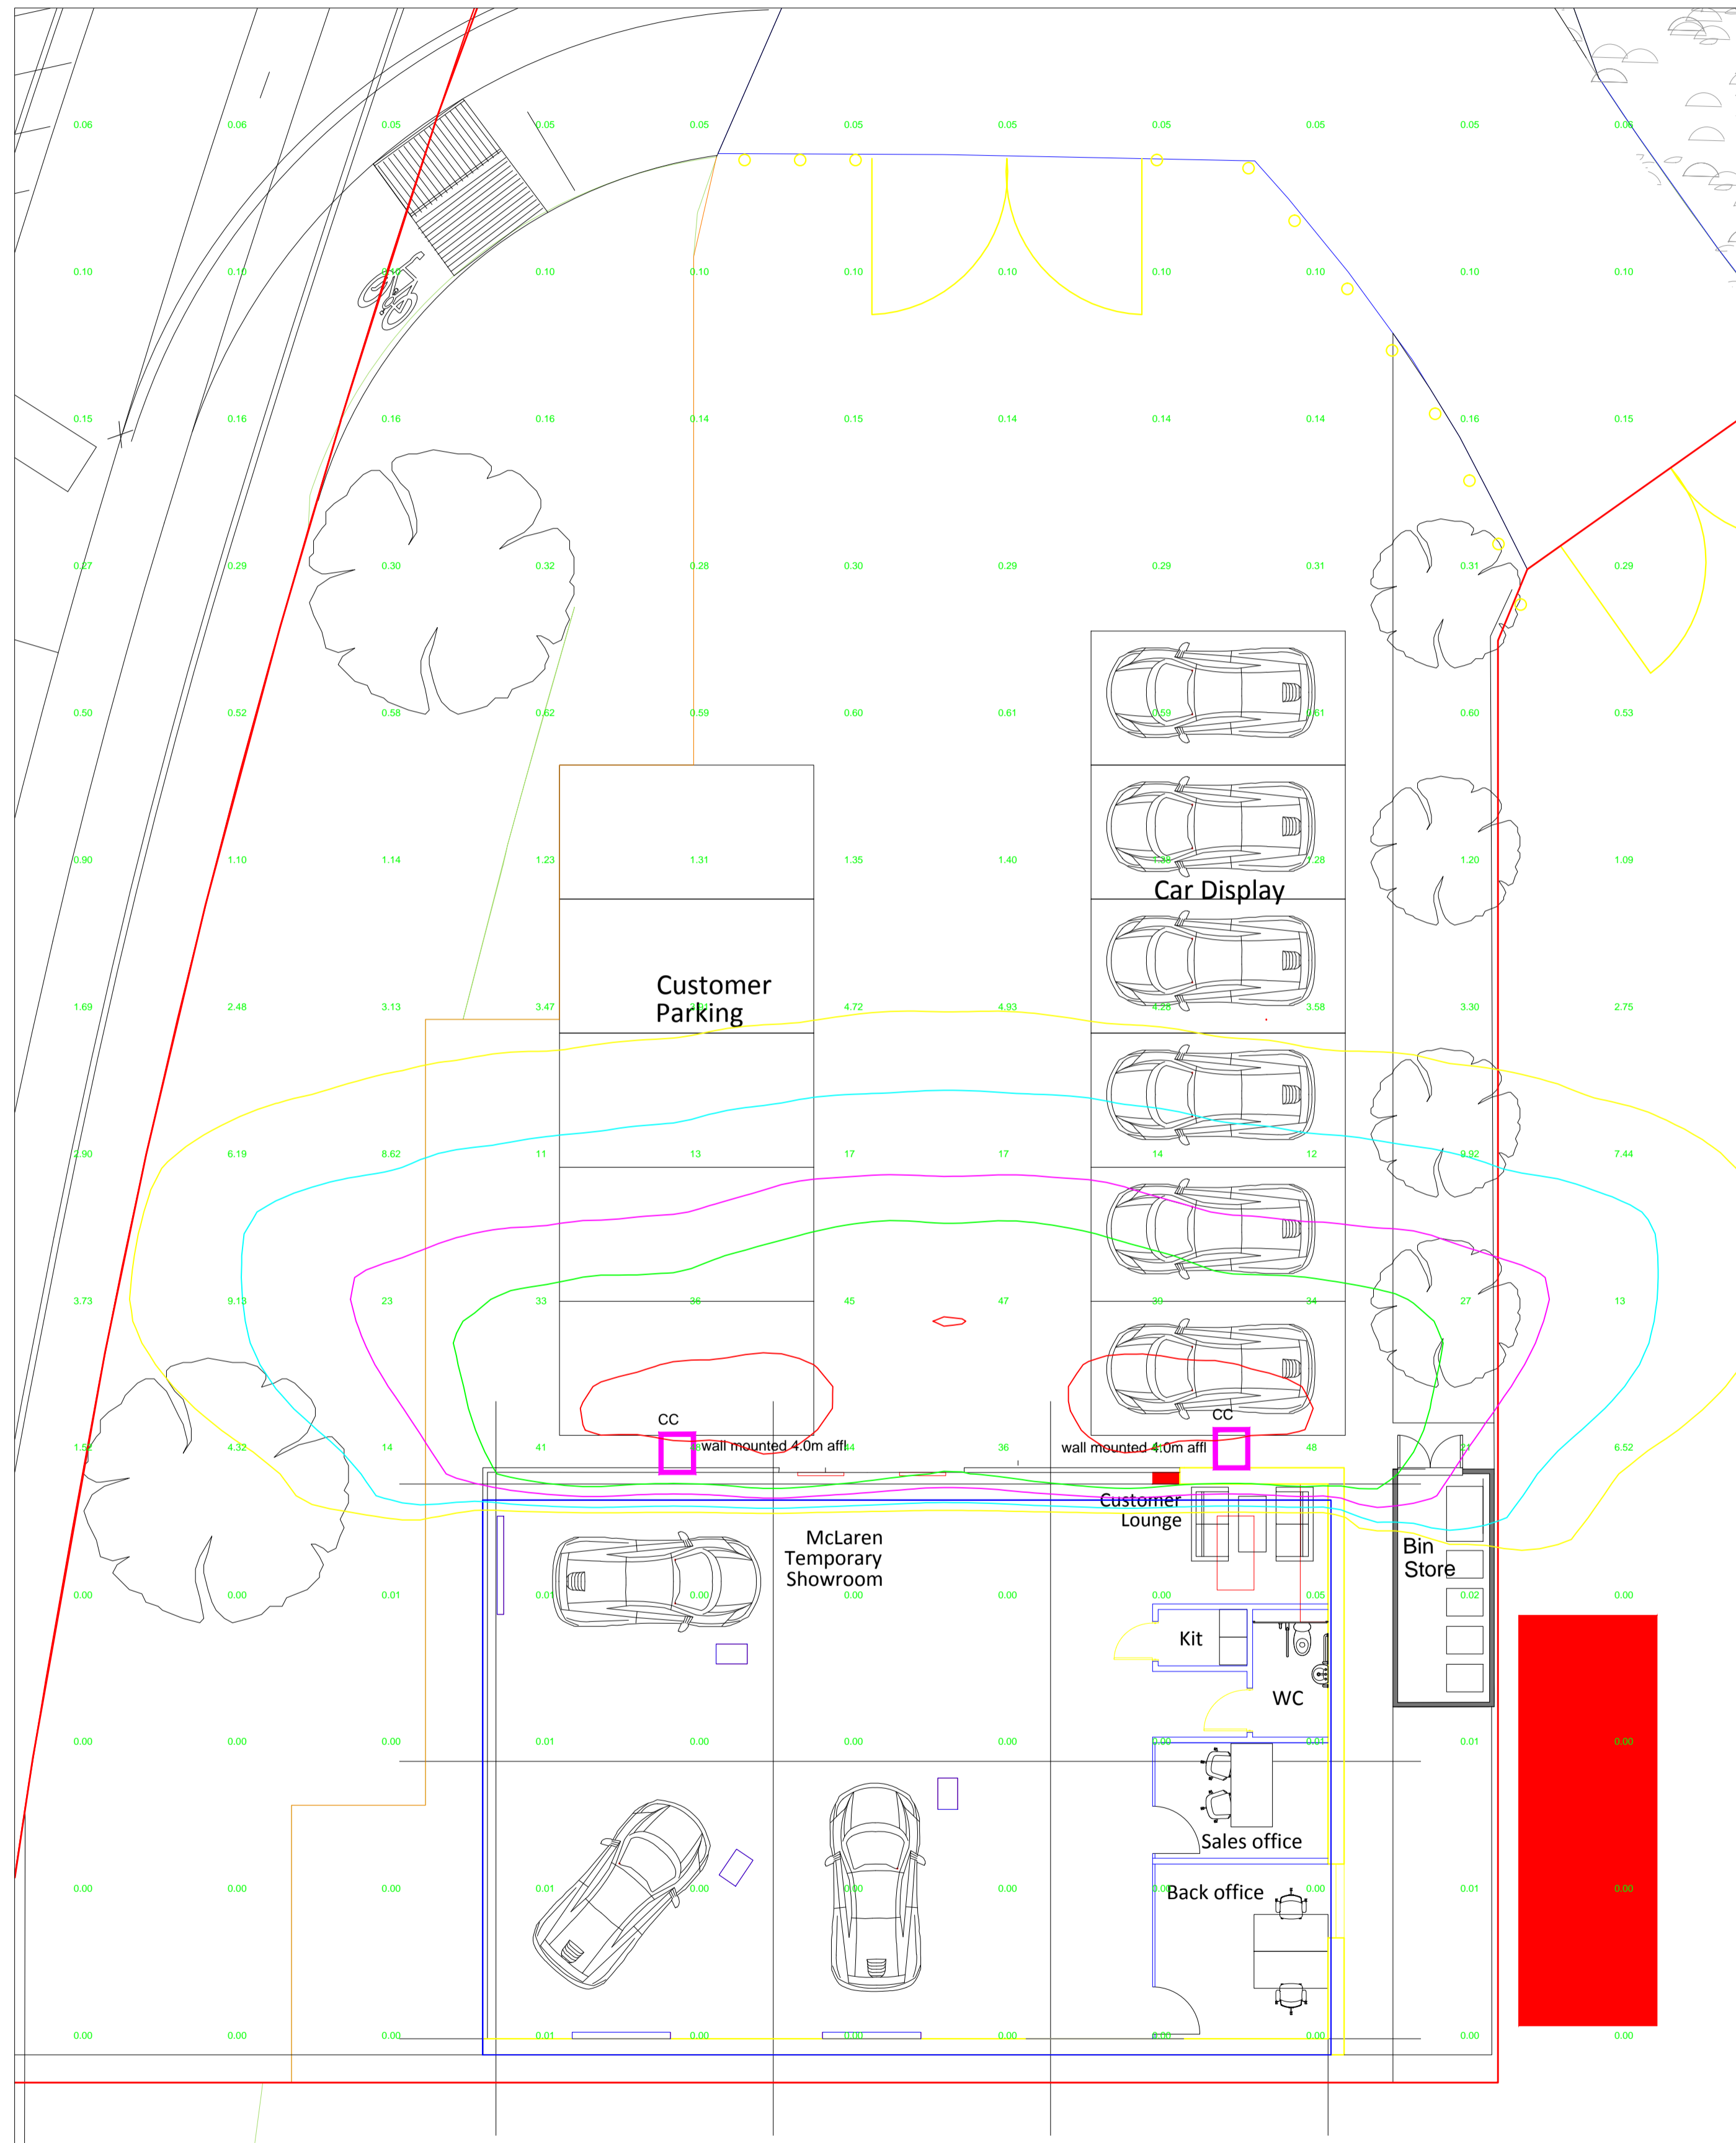

Key Plan. Scale 1:1000

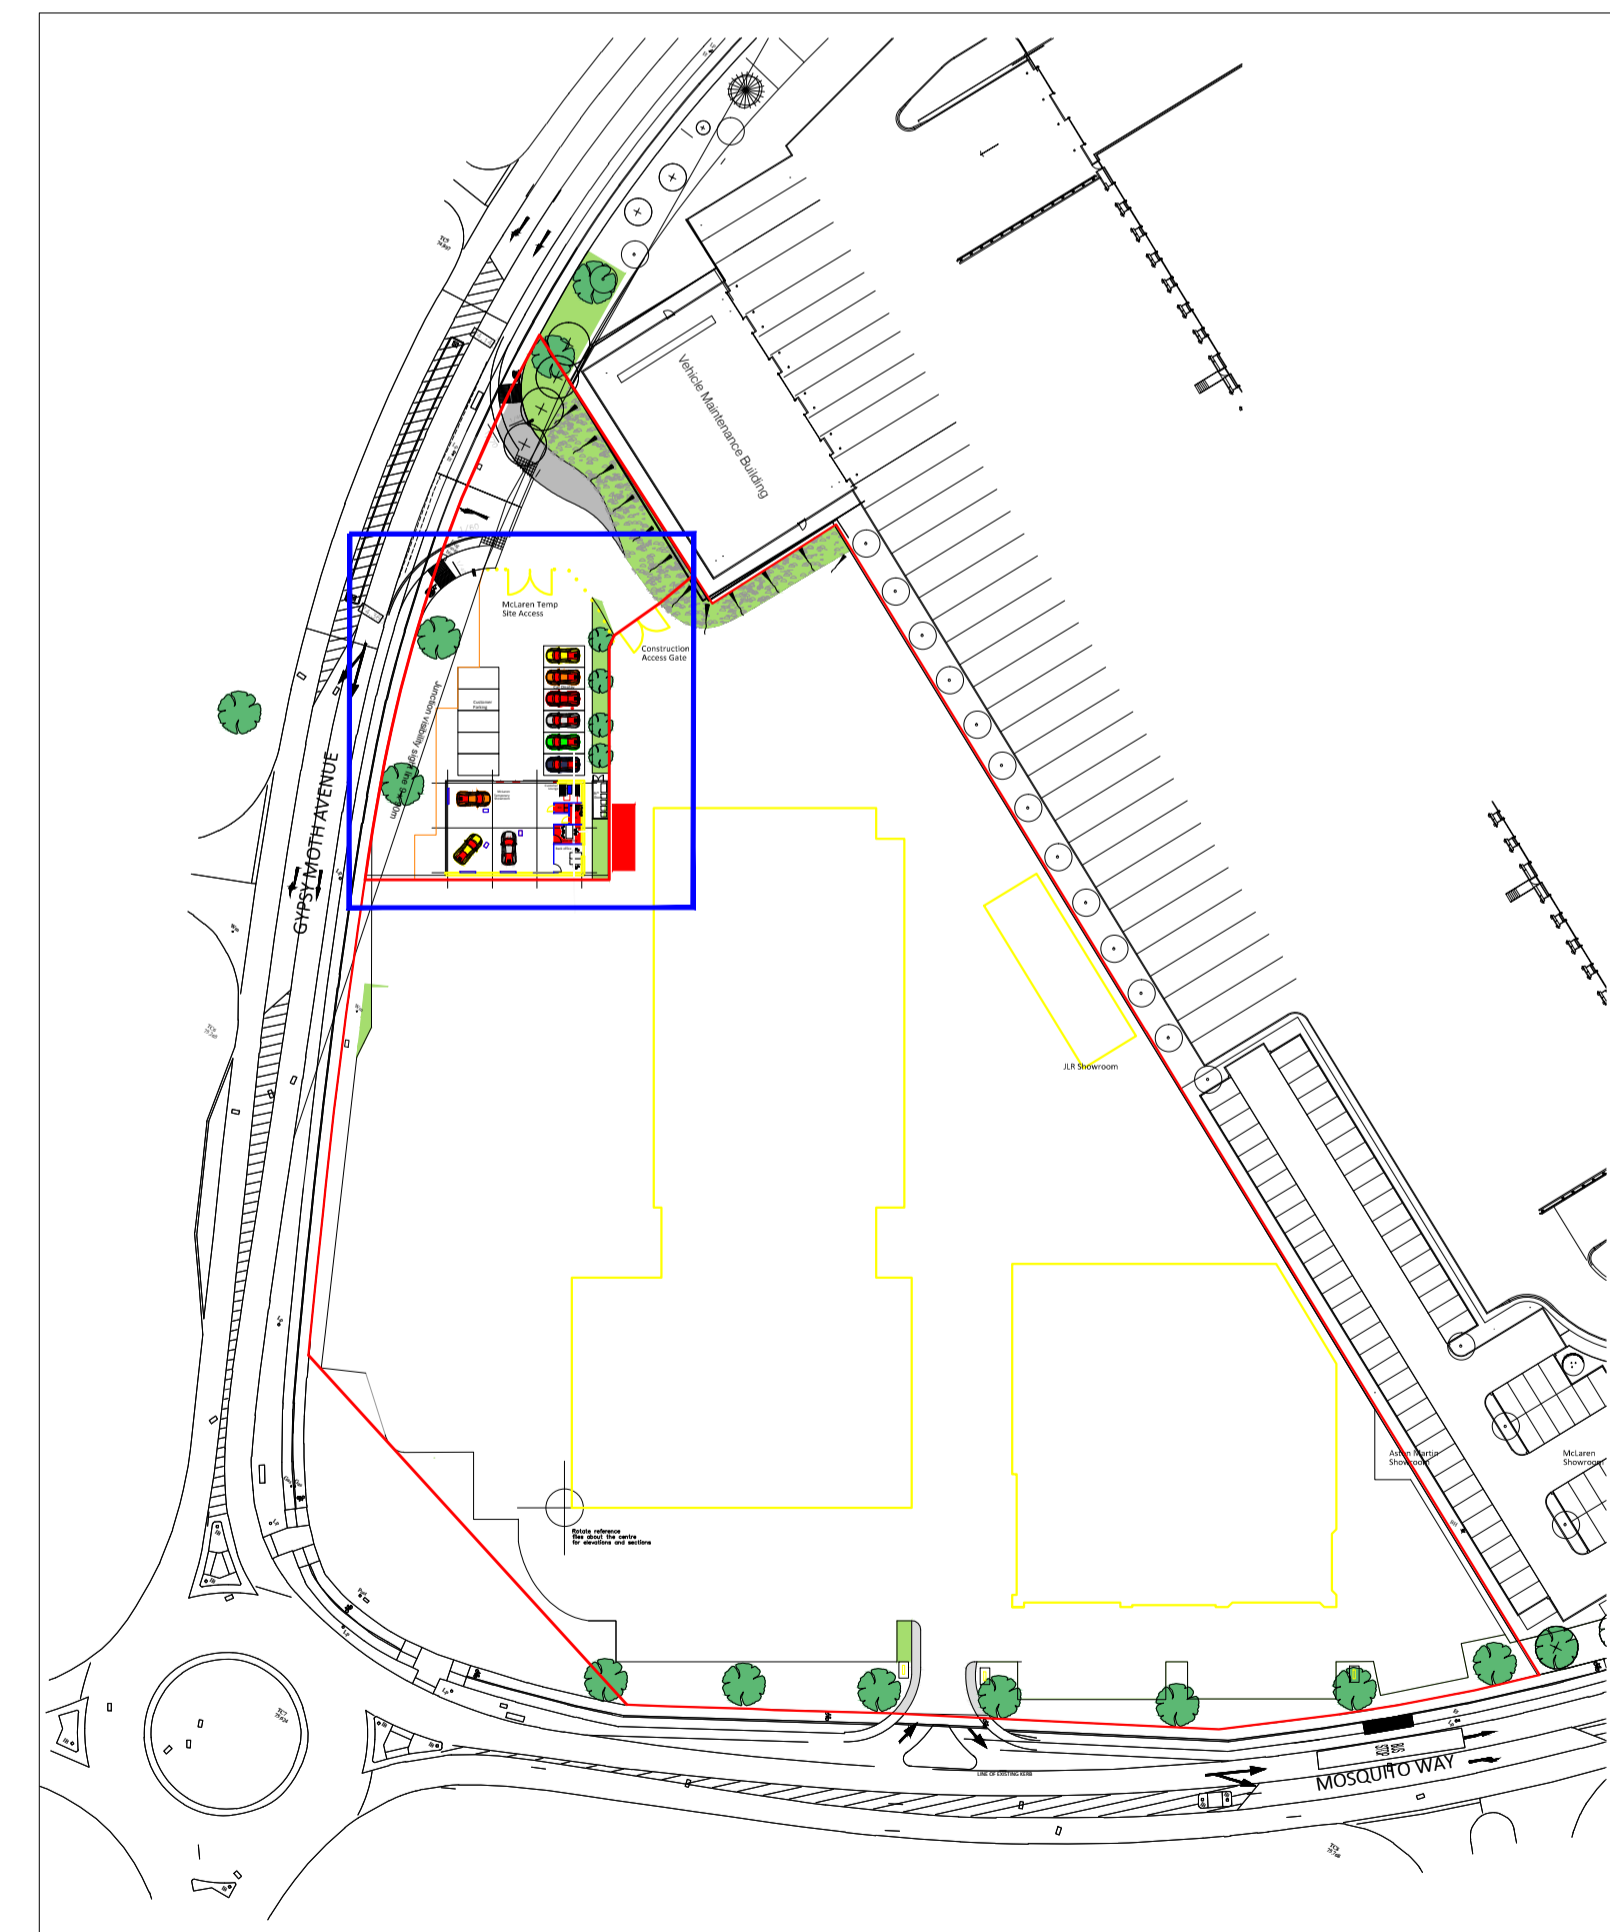

Note:

1. These drawings are the copyright of D&d Building Services Consulting Engineers Ltd. and may only be copied with prior permission.
2. All information is indicative only and must be verified on site by the contractor.
3. It is the responsibility of the Contractor to produce fully co-ordinated and working detailed drawings.

External Lighting Legend	
Symbol	Description
CC	Thorlux Lighting LED IP65 Floodlight Starbeam 62W Area Smart

- Isolines
- 0.0 lx
 - 10.0 lx
 - 20.0 lx
 - 30.0 lx
 - 50.0 lx

Rev	Date	Description	AG
P0	21/12/17	For Planning	AG

D&d
 Building Services Consulting Engineers Ltd
 28 Market Place, Kegworth
 Derby, DE74 2EE
 Tel: 01509 670100
 Fax: 01509 670110

Client
Cambridia

Project
Grange Multi-Brand Hatfield

Drawing Title
**McLaren Temporary Showroom
 Proposed External Electrical Services.**

Scale: 1:100@ A1 Date: December 2017

Drawn: AG Checked: RJC

Drawing No.: 17.046/E/32 Rev / P0

For Planning