



© EIRENG CONSULTING ENGINEERS  
 This drawing and any design hereon is the copyright of the Consultants and must not be reproduced without their written consent. All drawings remain the property of the Consultants.  
 Figures dimension only to be taken from this drawing. All dimensions to be checked on site. Consultants to be informed immediately of any discrepancies before work proceeds.

LEGEND:  
 — DENOTES SITE BOUNDARY LINE  
 — DENOTES SITE OWNERSHIP  
 — DENOTES OUTLINE OF PROPOSED VMU

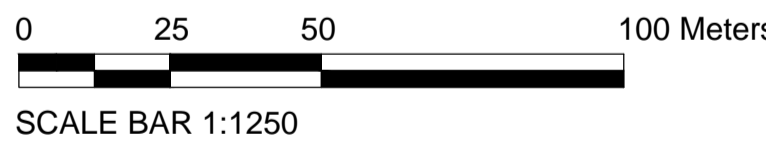

REV	DATE	BY	DESCRIPTION
PL4	29.08.18	LL	ISSUED FOR PLANNING
PL3	17.08.18	JC	ISSUED FOR PLANNING
PL2	16.08.18	JC	ISSUED FOR PLANNING
PL1	25.06.18	LL	ISSUED FOR PLANNING

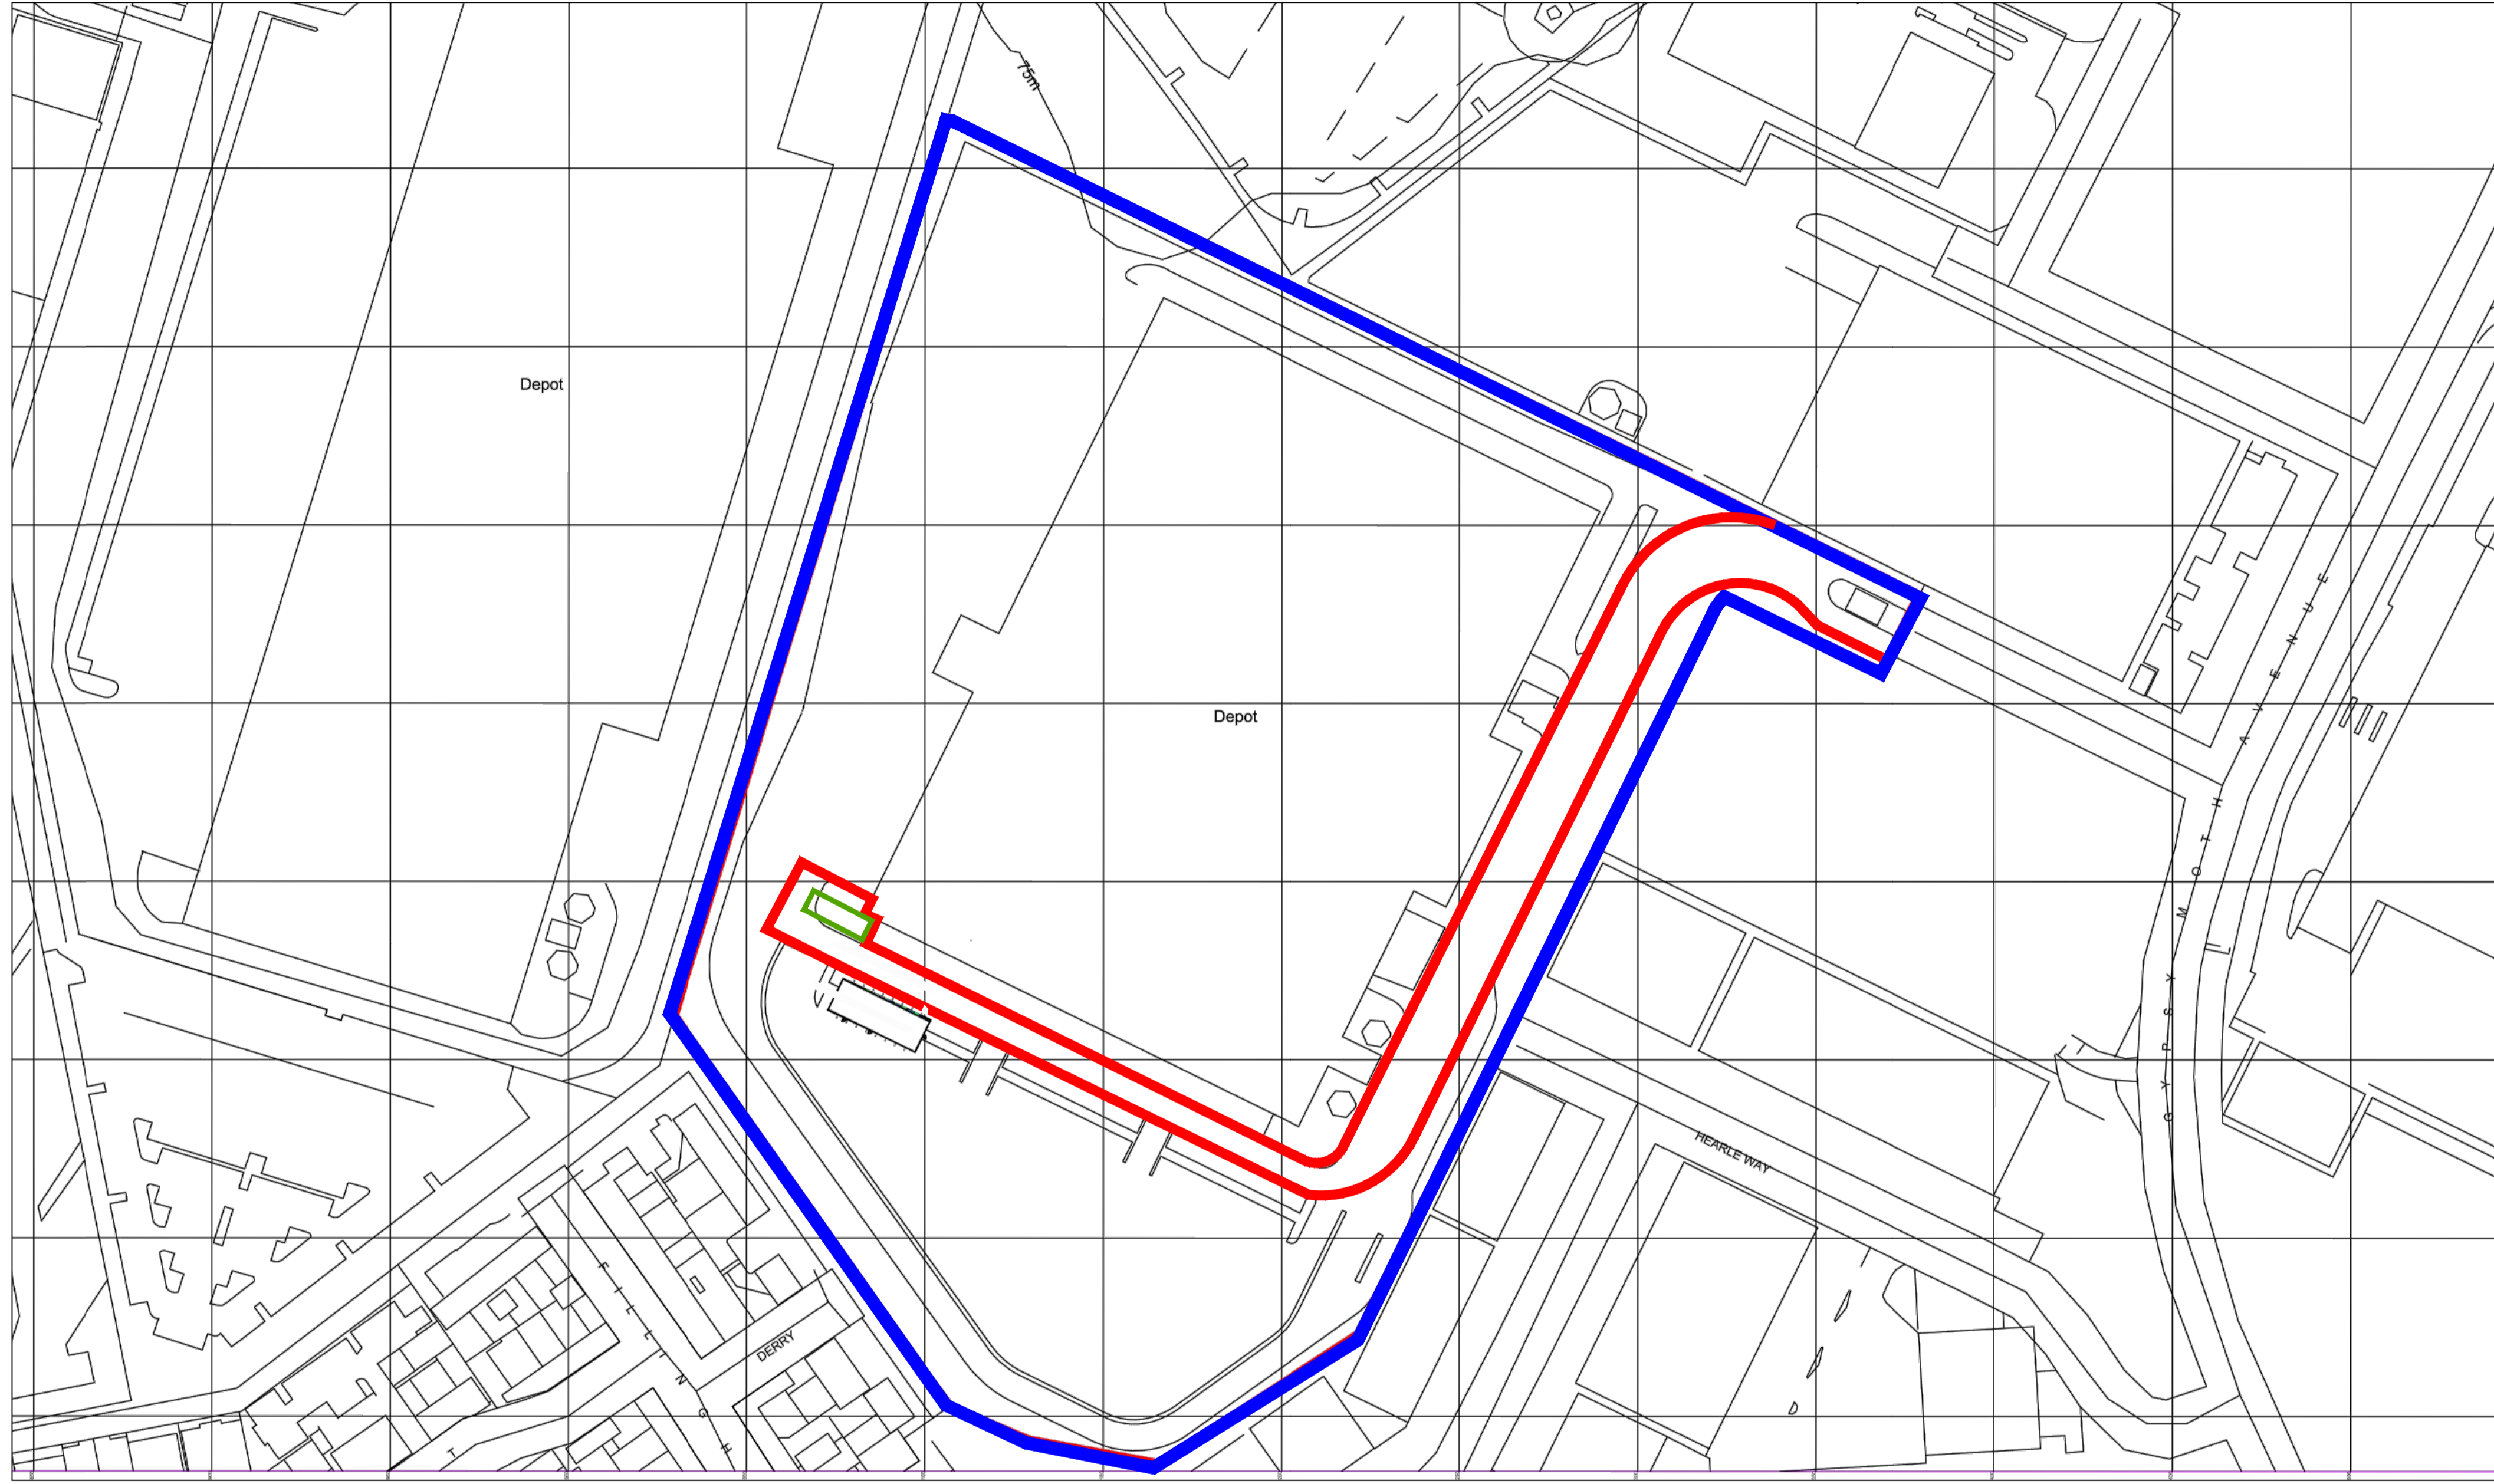

PROJECT TITLE  
**HATFIELD - NEW VEHICLE MAINTAINANCE UNIT (VMU)**

DRAWING TITLE  
**SITE PLAN**



DRAWN BY	L. Lonergan	DATE	10/08/18
ENG CHECK	E. Deasy	DATE	6.07.2018
APPROVED	J. Lamb	DATE	6.07.2018
SCALE	1:1250	SHEET	A1
STATUS	PLANNING		
JOB NO.	182037	DRAWING NUMBER	C001
		REVISION	PL4