


- Note:**
1. These drawings are the copyright of D&d Building Services Consulting Engineers Ltd. and may only be copied with prior permission.
  2. All information is indicative only and must be verified on site by the contractor.
  3. It is the responsibility of the Contractor to produce fully co-ordinated and working detailed drawings.

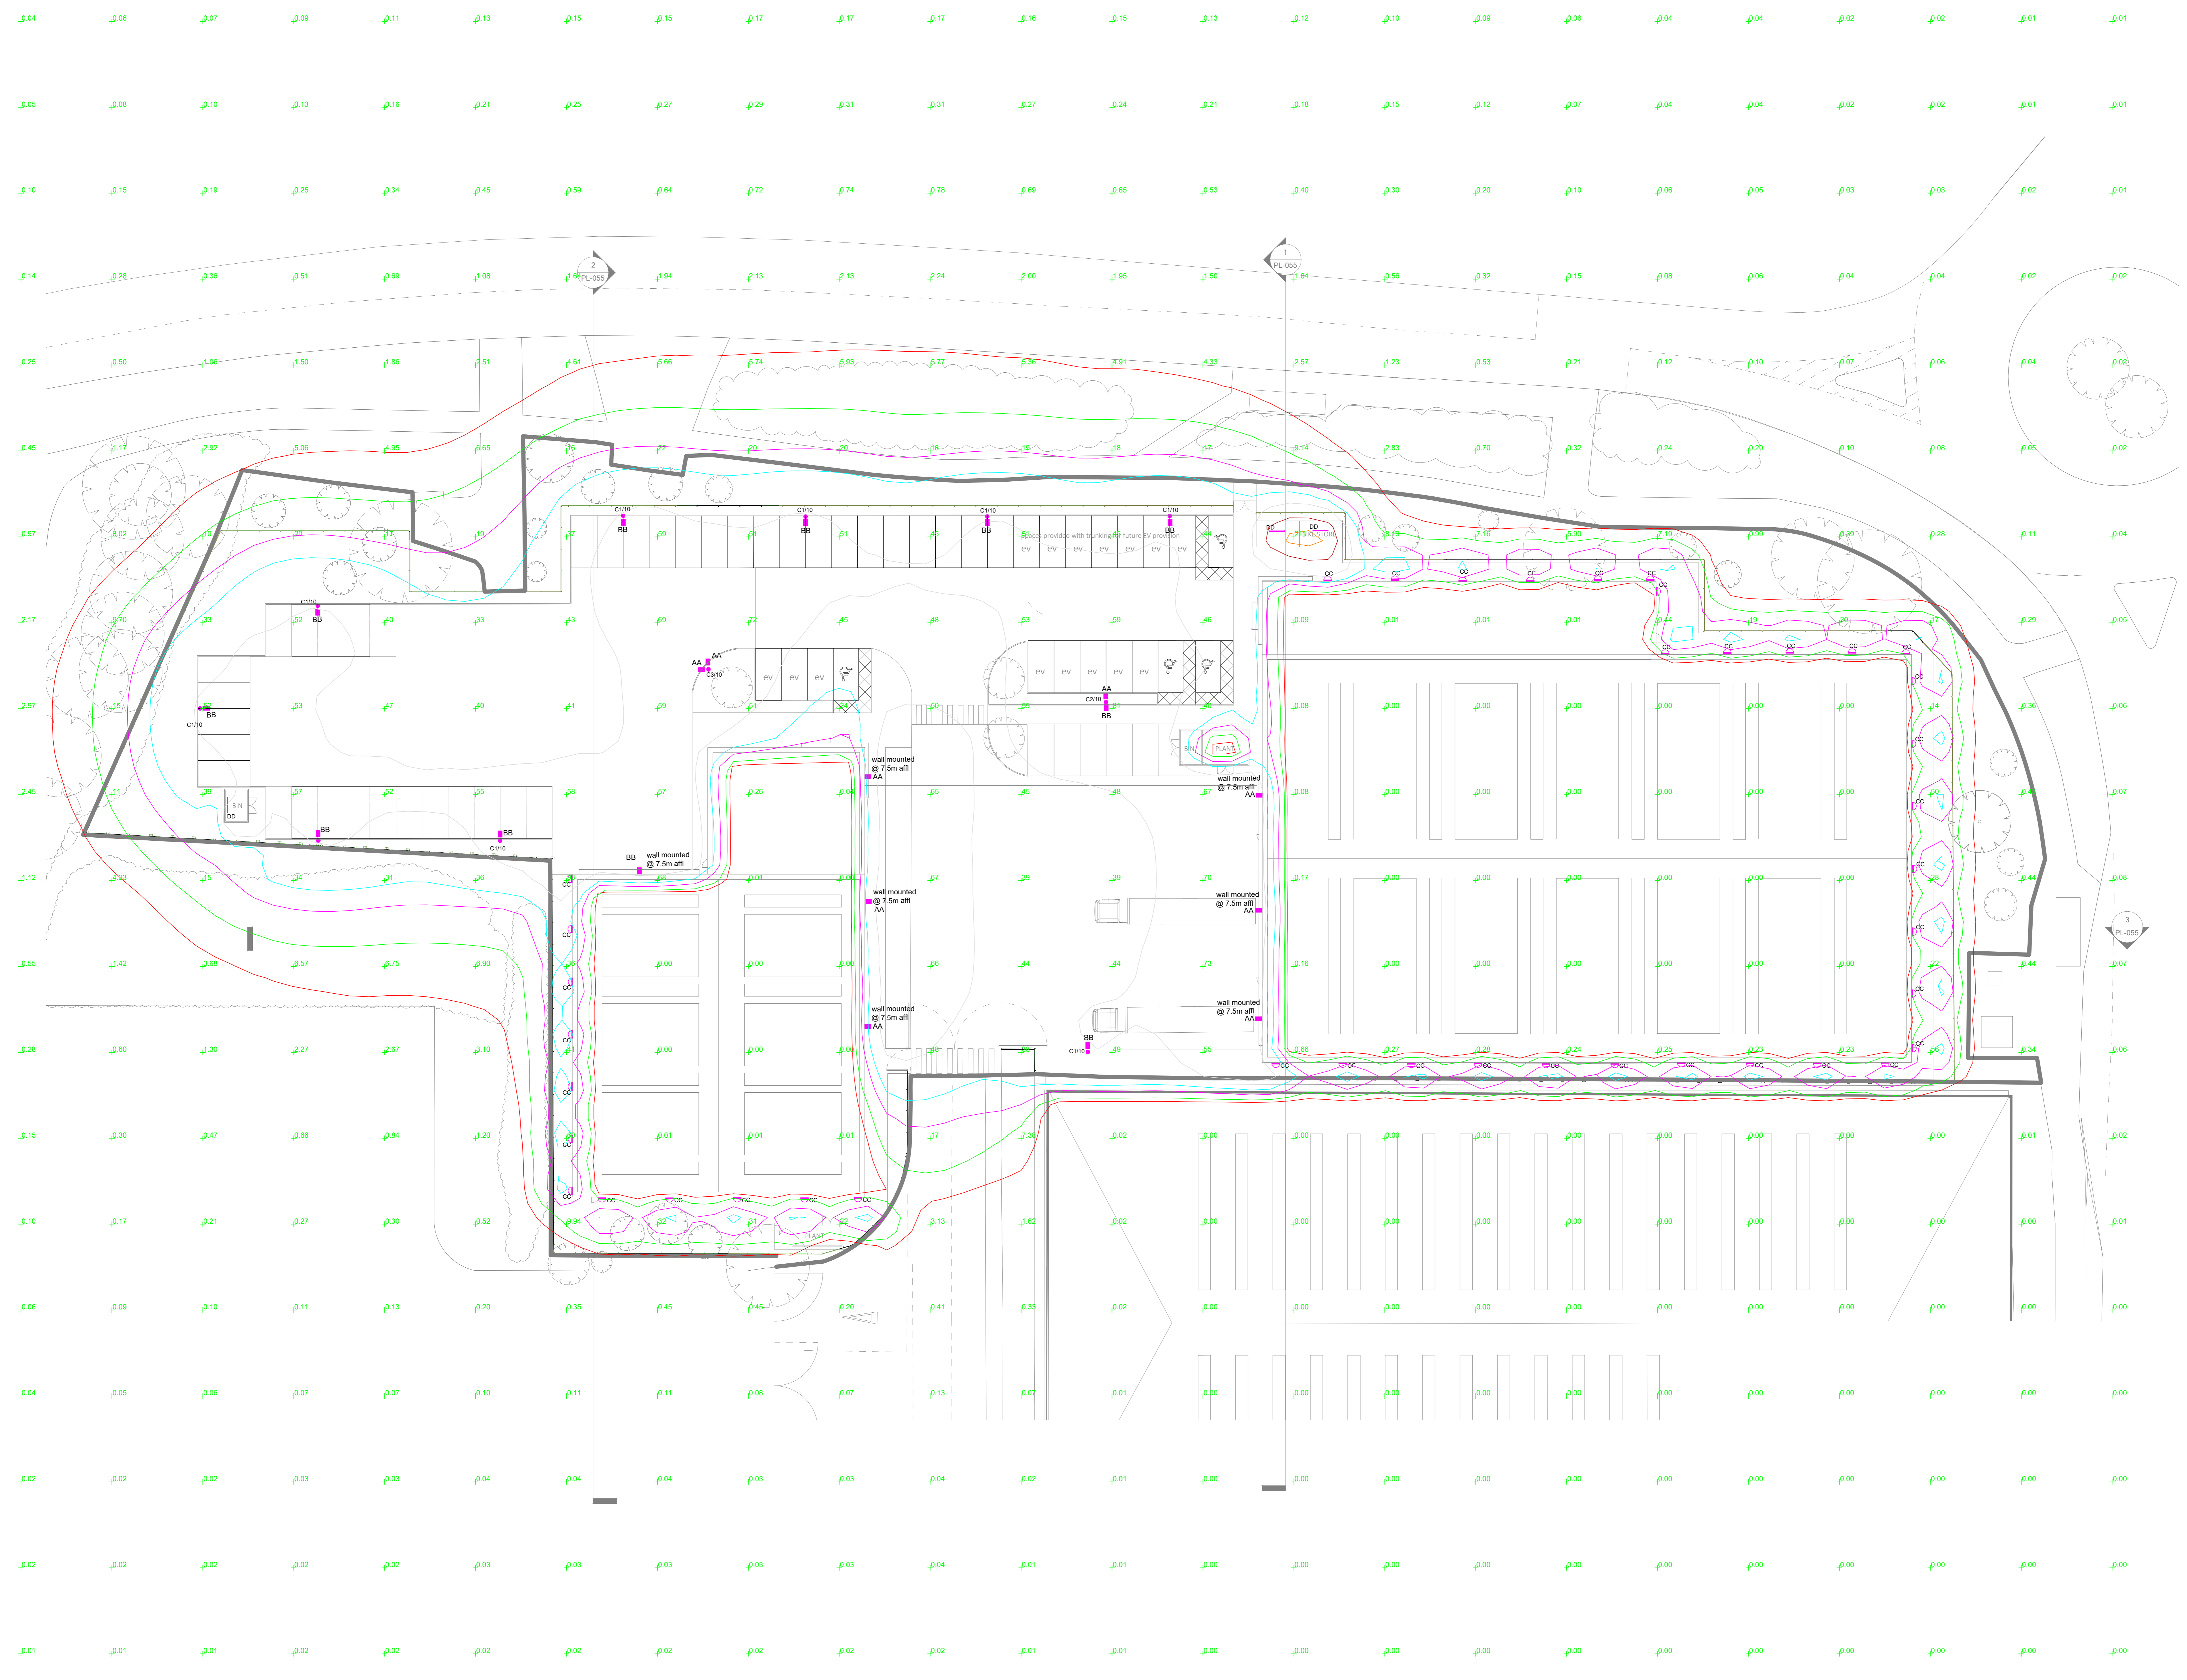

Symbol	Lighting Legend	Description
AA	■	IP66 LED Roadlight Whitcroft Lighting Services Mast 120W Area Cycle
BB	■	IP66 LED Roadlight Whitcroft Lighting Services Mast 160W Area Cycle
CC	○	Wall mounted (2.5m affl) bulkhead IP66 circular Whitcroft Lighting - Kolo Hood LED 14W
DD	○	Surface mounted IP65 luminaire Whitcroft Lighting - ACL Industry 50W LED
C110	●	10 metre column with Single Outreach Arm
C210	●	10 metre column with Twin Outreach Arm 180 degree
C310	●	10 metre column with Twin Outreach Arm 90 degree

Rev	Date	Description	AS	Table
P2	28/11/22	Updated Site Plan drawings Revised by AG	AG	
P1	23/11/22	Updated Site Plan drawings Revised by AG	AG	
PS	14/02/22	For Planning	AG	

**D&d**  
 Building Services Consulting Engineers Ltd  
 28 Market Place, Kegworth  
 Derby, DE74 2EE  
 Tel: 01509 670100  
 Fax: 01509 670110

Client	Cambria	
Project	Plot 5610 Hatfield	
Drawing Title	Proposed External Lighting	
Scale: 1:50@ A0	Date: July 2022	
Drawn: AG	Checked: RJC	
Drawing No.:	22.034/EP/01	Rev / P2

For Planning