


Copyright
 This drawing/specification is the property of Eisai Limited and may not be reproduced or disclosed to a third party in any form without written permission from the company.

SITE BOUNDARY IN BLUE

LOCATION OF CHEMICAL STORAGE UNIT IN RED

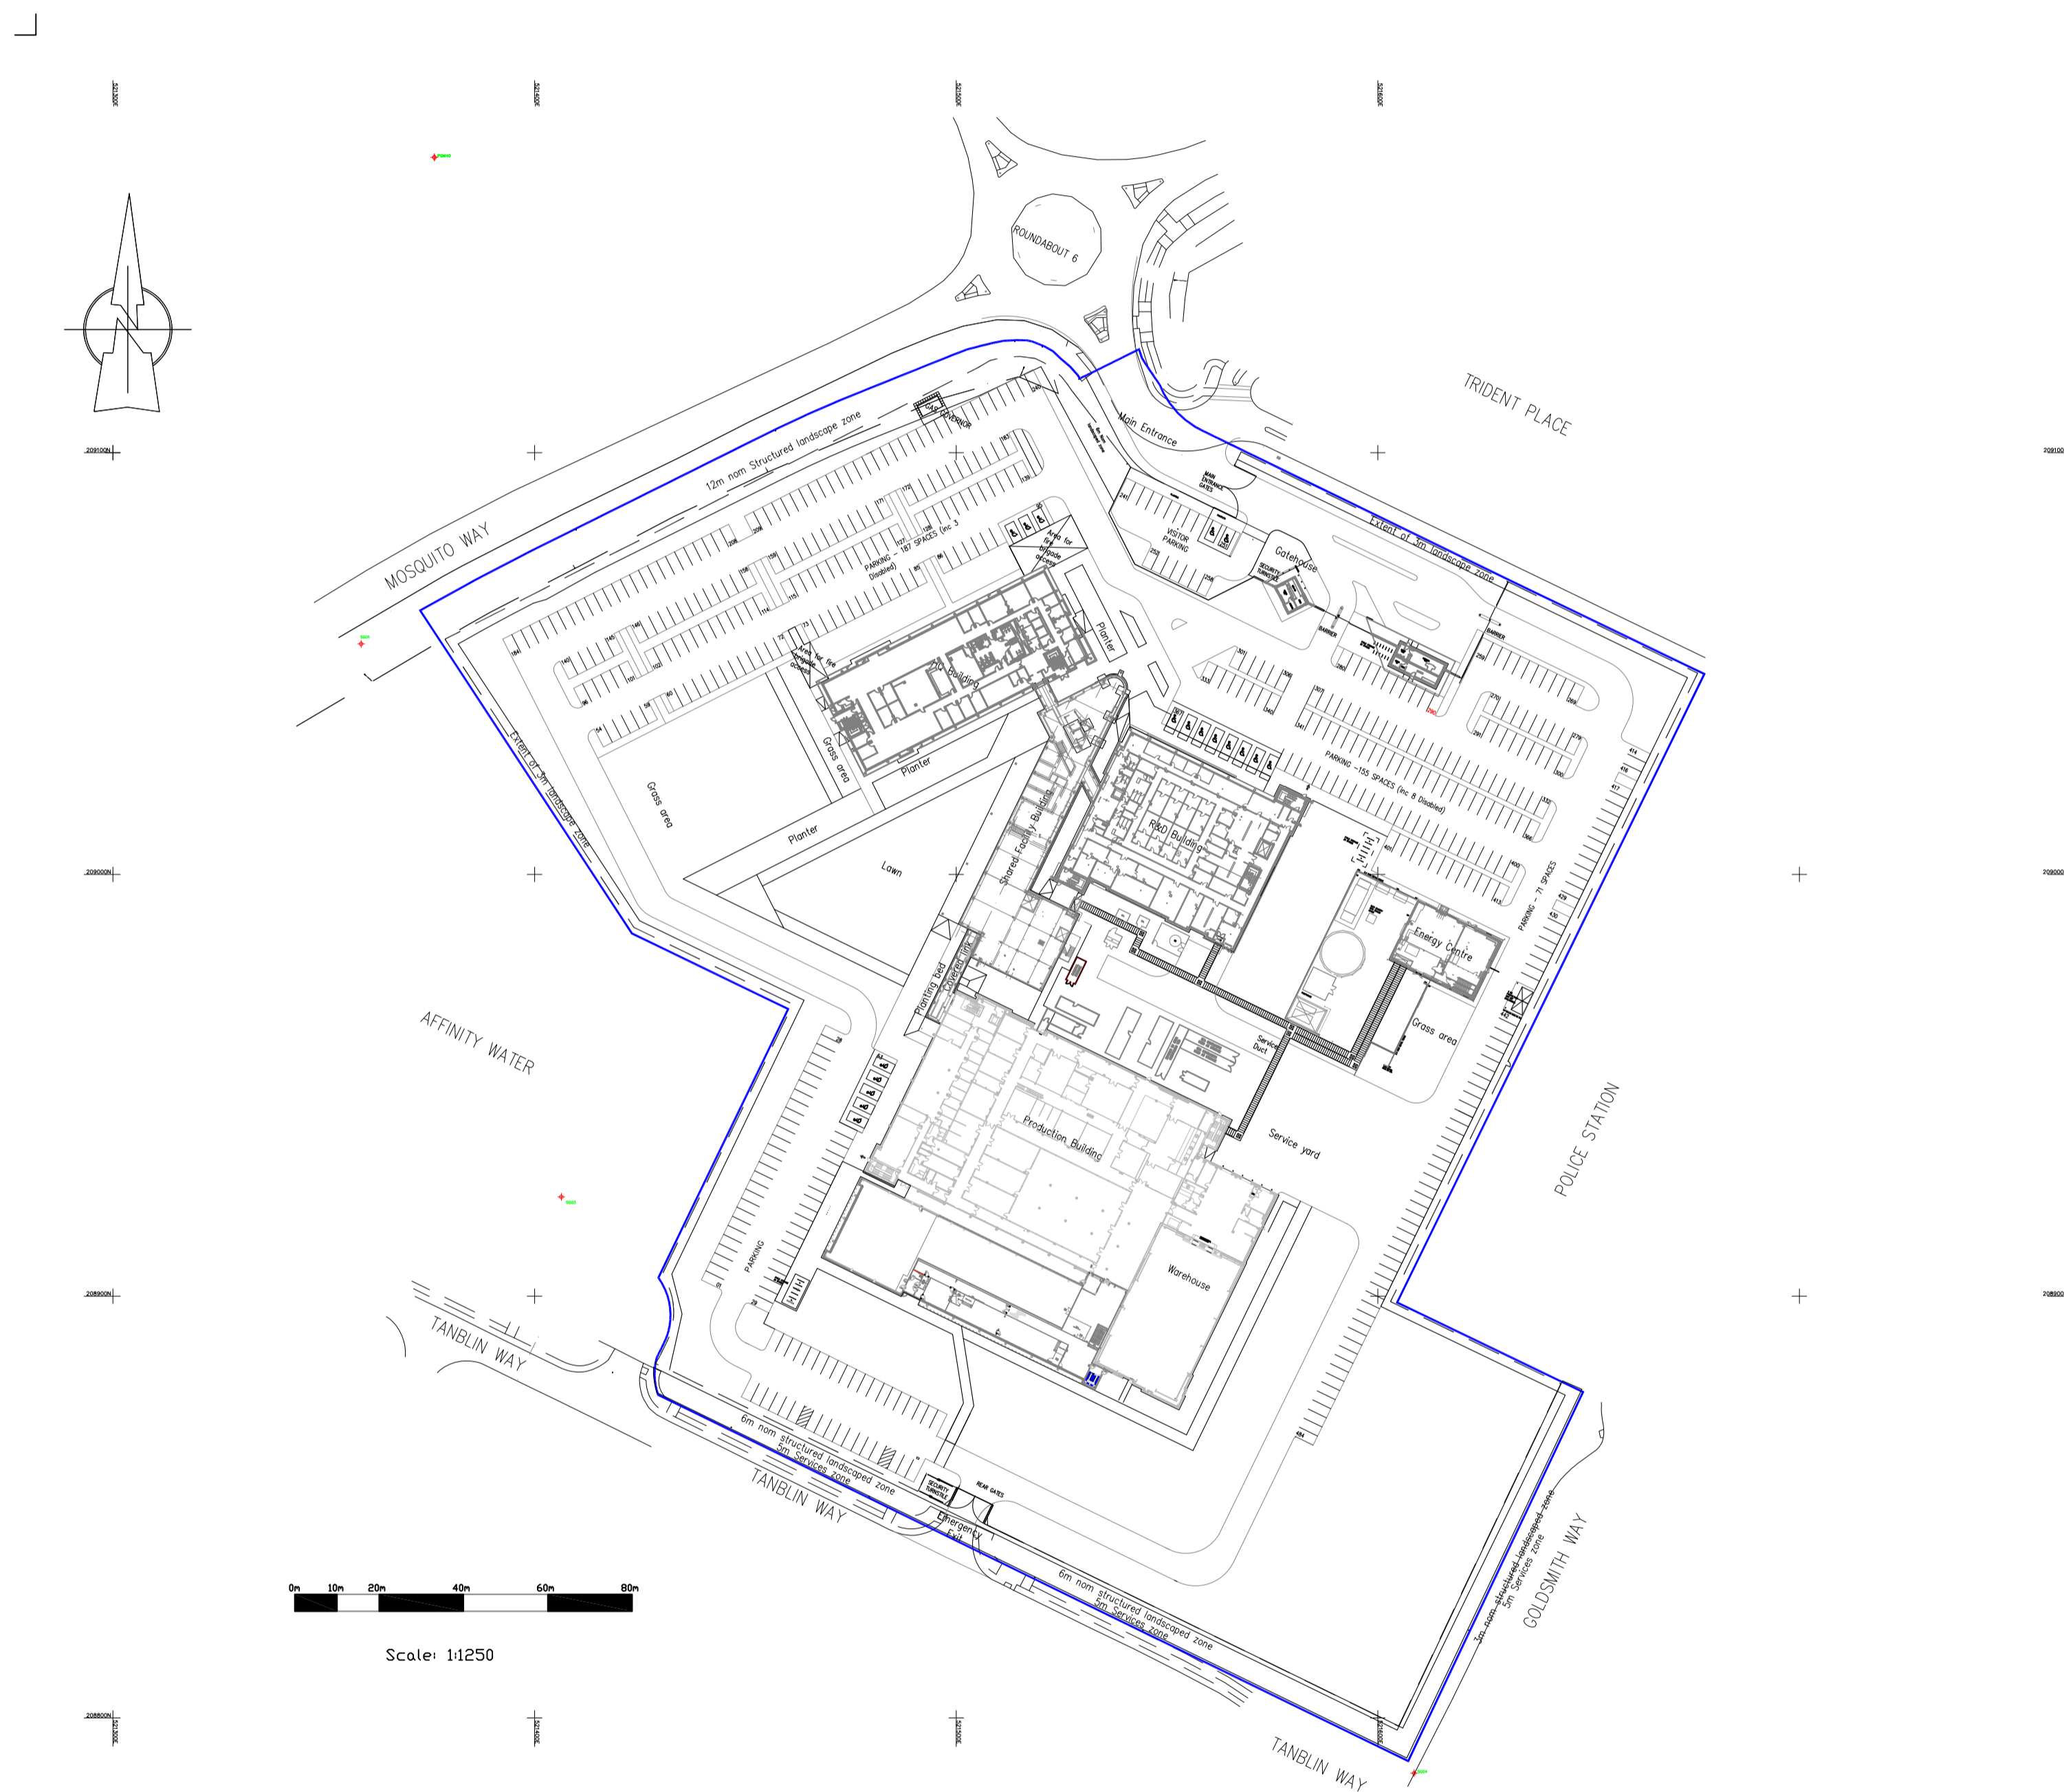

Rev:	CCR:	Date:	Description:
Created	ENG. Reviewed 1	ENG. Reviewed 2 (P&ID Only)	ENG. Approved
Name	Name	Name	Name
Sign	Sign	Sign	Sign
Date	Date	Date	Date



European Knowledge Centre
 Mosquito Way
 Hatfield
 Hertfordshire, AL10 9SN
 Tel :- 0845 676 1400
 Fax :- 0845 676 5050
 Website :- www.eisai.co.uk

Updated from original vendor drawing:	 THIRD ANGLE PROJECTION
Drawing No. Revision: Date:	

Project:
**EISAI
 EML**

Drawing Title:
**CHEMICAL
 STORAGE UNIT
 SITE PLAN**

Drawing Status:

Drawn:	Date :	Scale: 1:1250	Sheet: 1 of 11
Checked :	Date :	Size A1	Revision

Drawing No.
CS01

