



Copyright
 This drawing/specification is the property of Eisai Limited and may not be reproduced or disclosed to a third party in any form without written permission from the company.

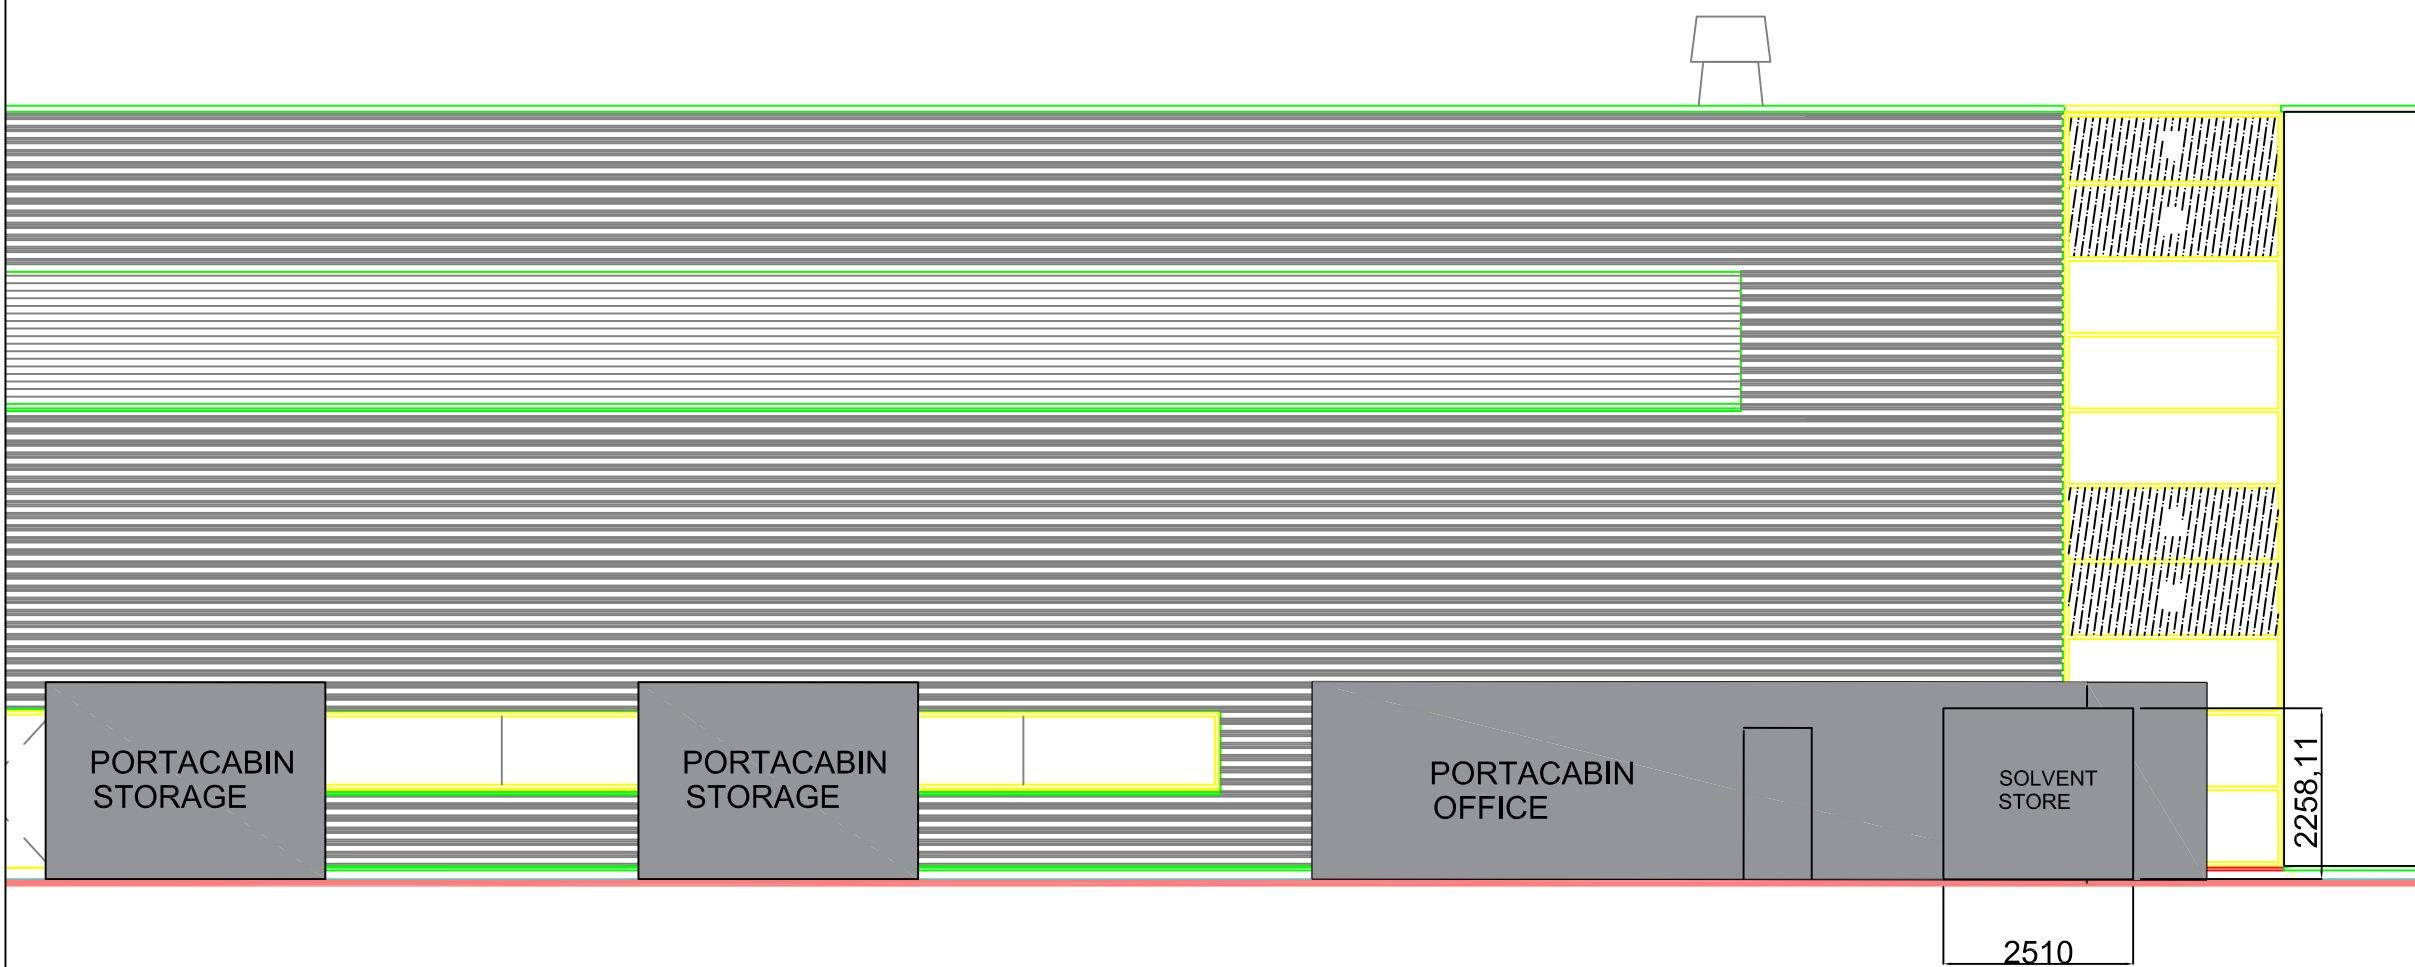

NORTH EAST ELEVATION

 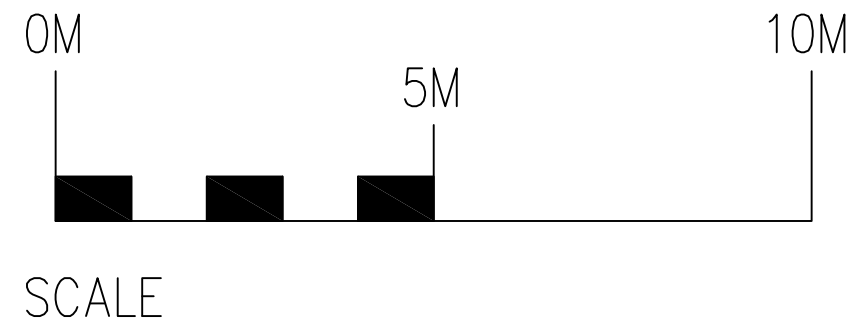


Rev:	CCR:	Date:	Description:
Created	ENG. Reviewed 1	ENG. Reviewed 2 (P&ID Only)	ENG. Approved
Name	Name	Name	Name
Sign	Sign	Sign	Sign
Date	Date	Date	Date



European Knowledge Centre
 Mosquito Way
 Hatfield
 Hertfordshire, AL10 9SN
 Tel :- 0845 676 1400
 Fax :- 0845 676 5050
 Website :- www.eisai.co.uk

Updated from original vendor drawing:		
Drawing No.	Revision:	Date:



Project:
**EML
 EISAI**

Drawing Title:
**CHEMICAL
 STORAGE UNIT
 PROPOSED NORTH EAST ELAVATION**

Drawn:	Date :	Scale:	Sheet:
Checked :	Date :	Size A3	Revision
Drawing No. CS05			