


Copyright  
This drawing/specification is the property of Eisai Limited and may not be reproduced or disclosed to a third party in any form without written permission from the company.

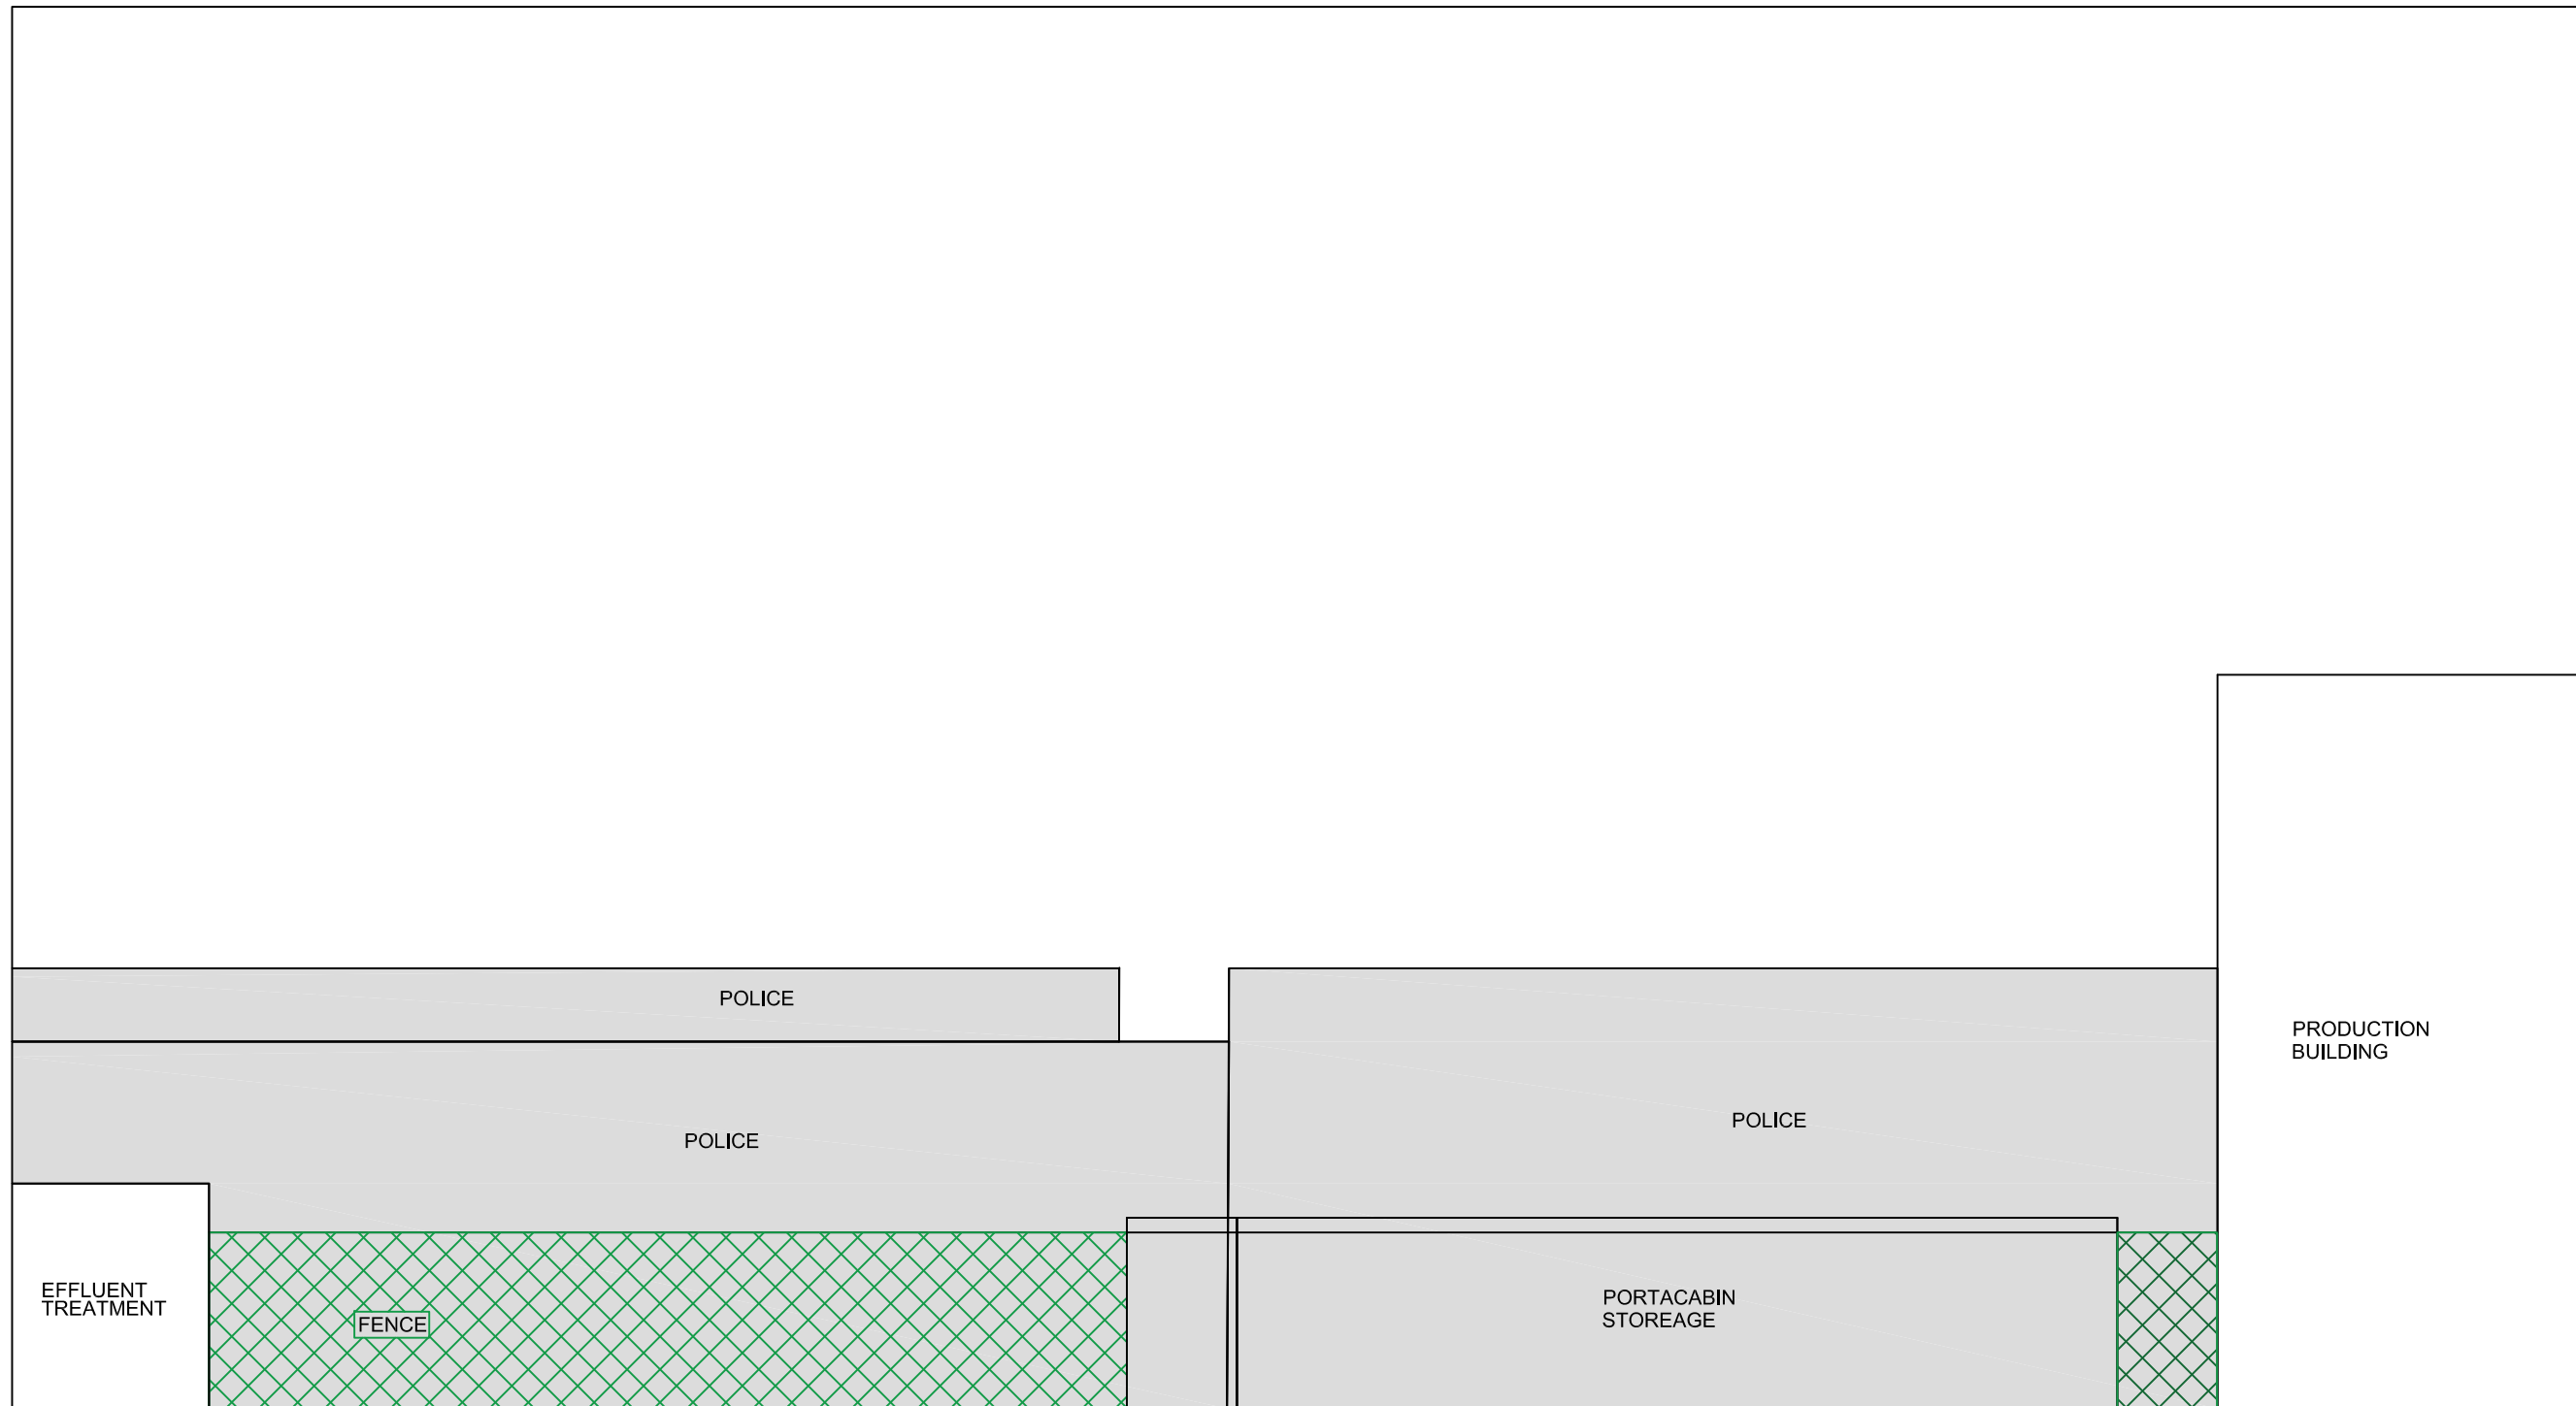

Rev.	CCR	Date	Description


Created	ENG. Reviewed 1	ENG. Reviewed 2 (P&ID Only)	ENG. Approved
Name	Name	Name	Name
Sign	Sign	Sign	Sign
Date	Date	Date	Date



European Knowledge Centre  
Mosquito Way  
Hatfield  
Hertfordshire, AL10 9SN

Tel :- 0845 676 1400  
Fax :- 0845 676 5050  
Website :- www.eisai.co.uk

 Updated from original vendor drawing:  
Drawing No. Revision: Date:



THIRD ANGLE PROJECTION

Project:  
EISAI  
EML

Drawing Title:  
CHEMICAL STORAGE UNIT  
EXISTING NORTH WEST ELEVATION

Drawing Status:

Drawn:	Date:	Scale: 1:100	Sheet
Checked:	Date:	Size <b>A3</b>	Revision
Drawing No. CS06			

NORTH WEST ELEVATION

