


Copyright
 This drawing/specification is the property of Eisai Limited and may not be reproduced or disclosed to a third party in any form without written permission from the company.

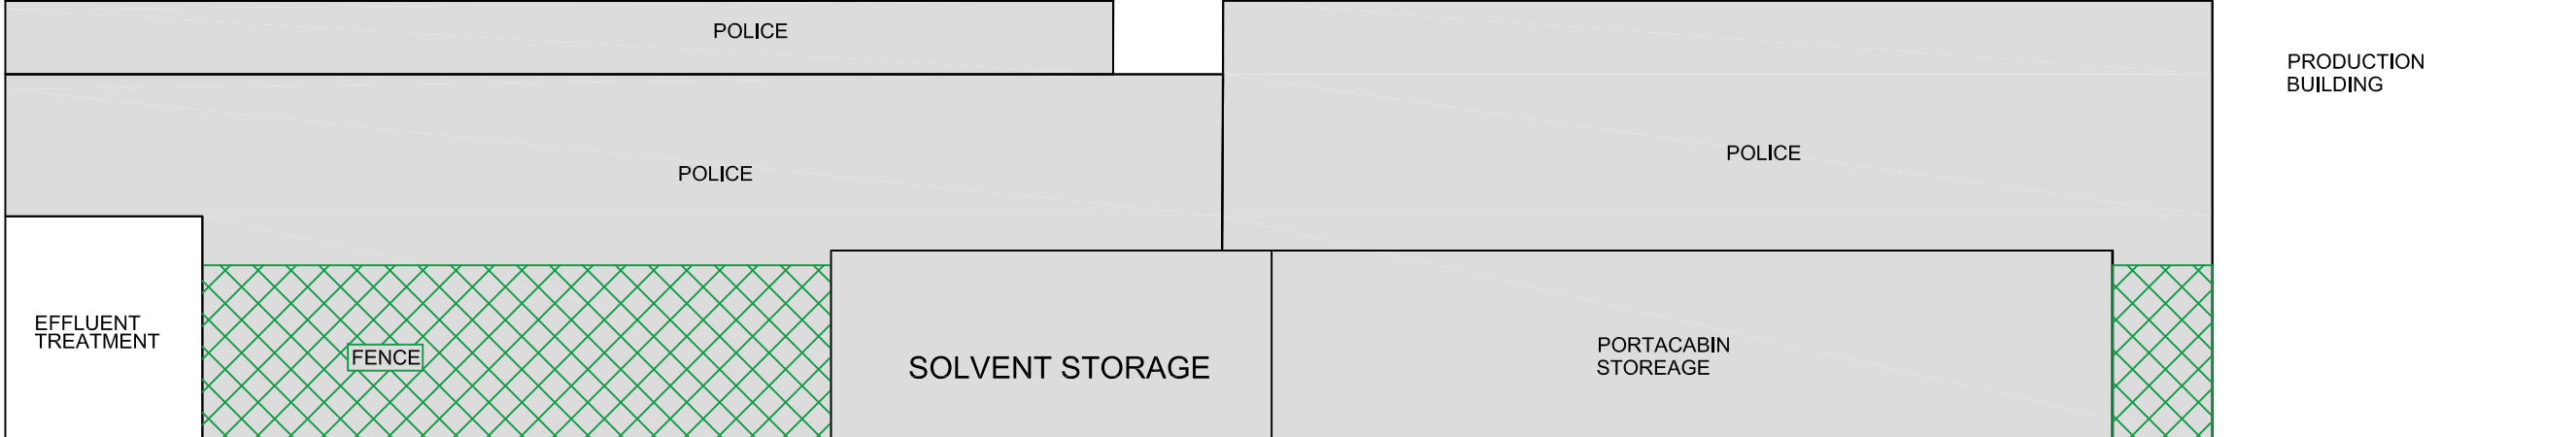

Rev:	CCR:	Date:	Description:

Created	ENG. Reviewed 1	ENG. Reviewed 2 (P&ID Only)	ENG. Approved
Name	Name	Name	Name
Sign	Sign	Sign	Sign
Date	Date	Date	Date

 


European Knowledge Centre
 Mosquito Way
 Hatfield
 Hertfordshire, AL10 9SN

Tel :- 0845 676 1400
 Fax :- 0845 676 5050
 Website :- www.eisai.co.uk

Updated from original vendor drawing:

Drawing No.	Revision:	Date:
-------------	-----------	-------



THIRD ANGLE PROJECTION

Project:
EISAI EML

Drawing Title:
CHEMICAL STORAGE UNIT PROPOSED NORTH WEST ELEVATION

Drawn:	Date:	Scale: 1:100	Sheet
Checked:	Date:	Size A3	Revision
Drawing No. CS07			

NORTH WEST ELEVATION

