


Copyright
This drawing/specification is the property of Eisai Limited and may not be reproduced or disclosed to a third party in any form without written permission from the company.

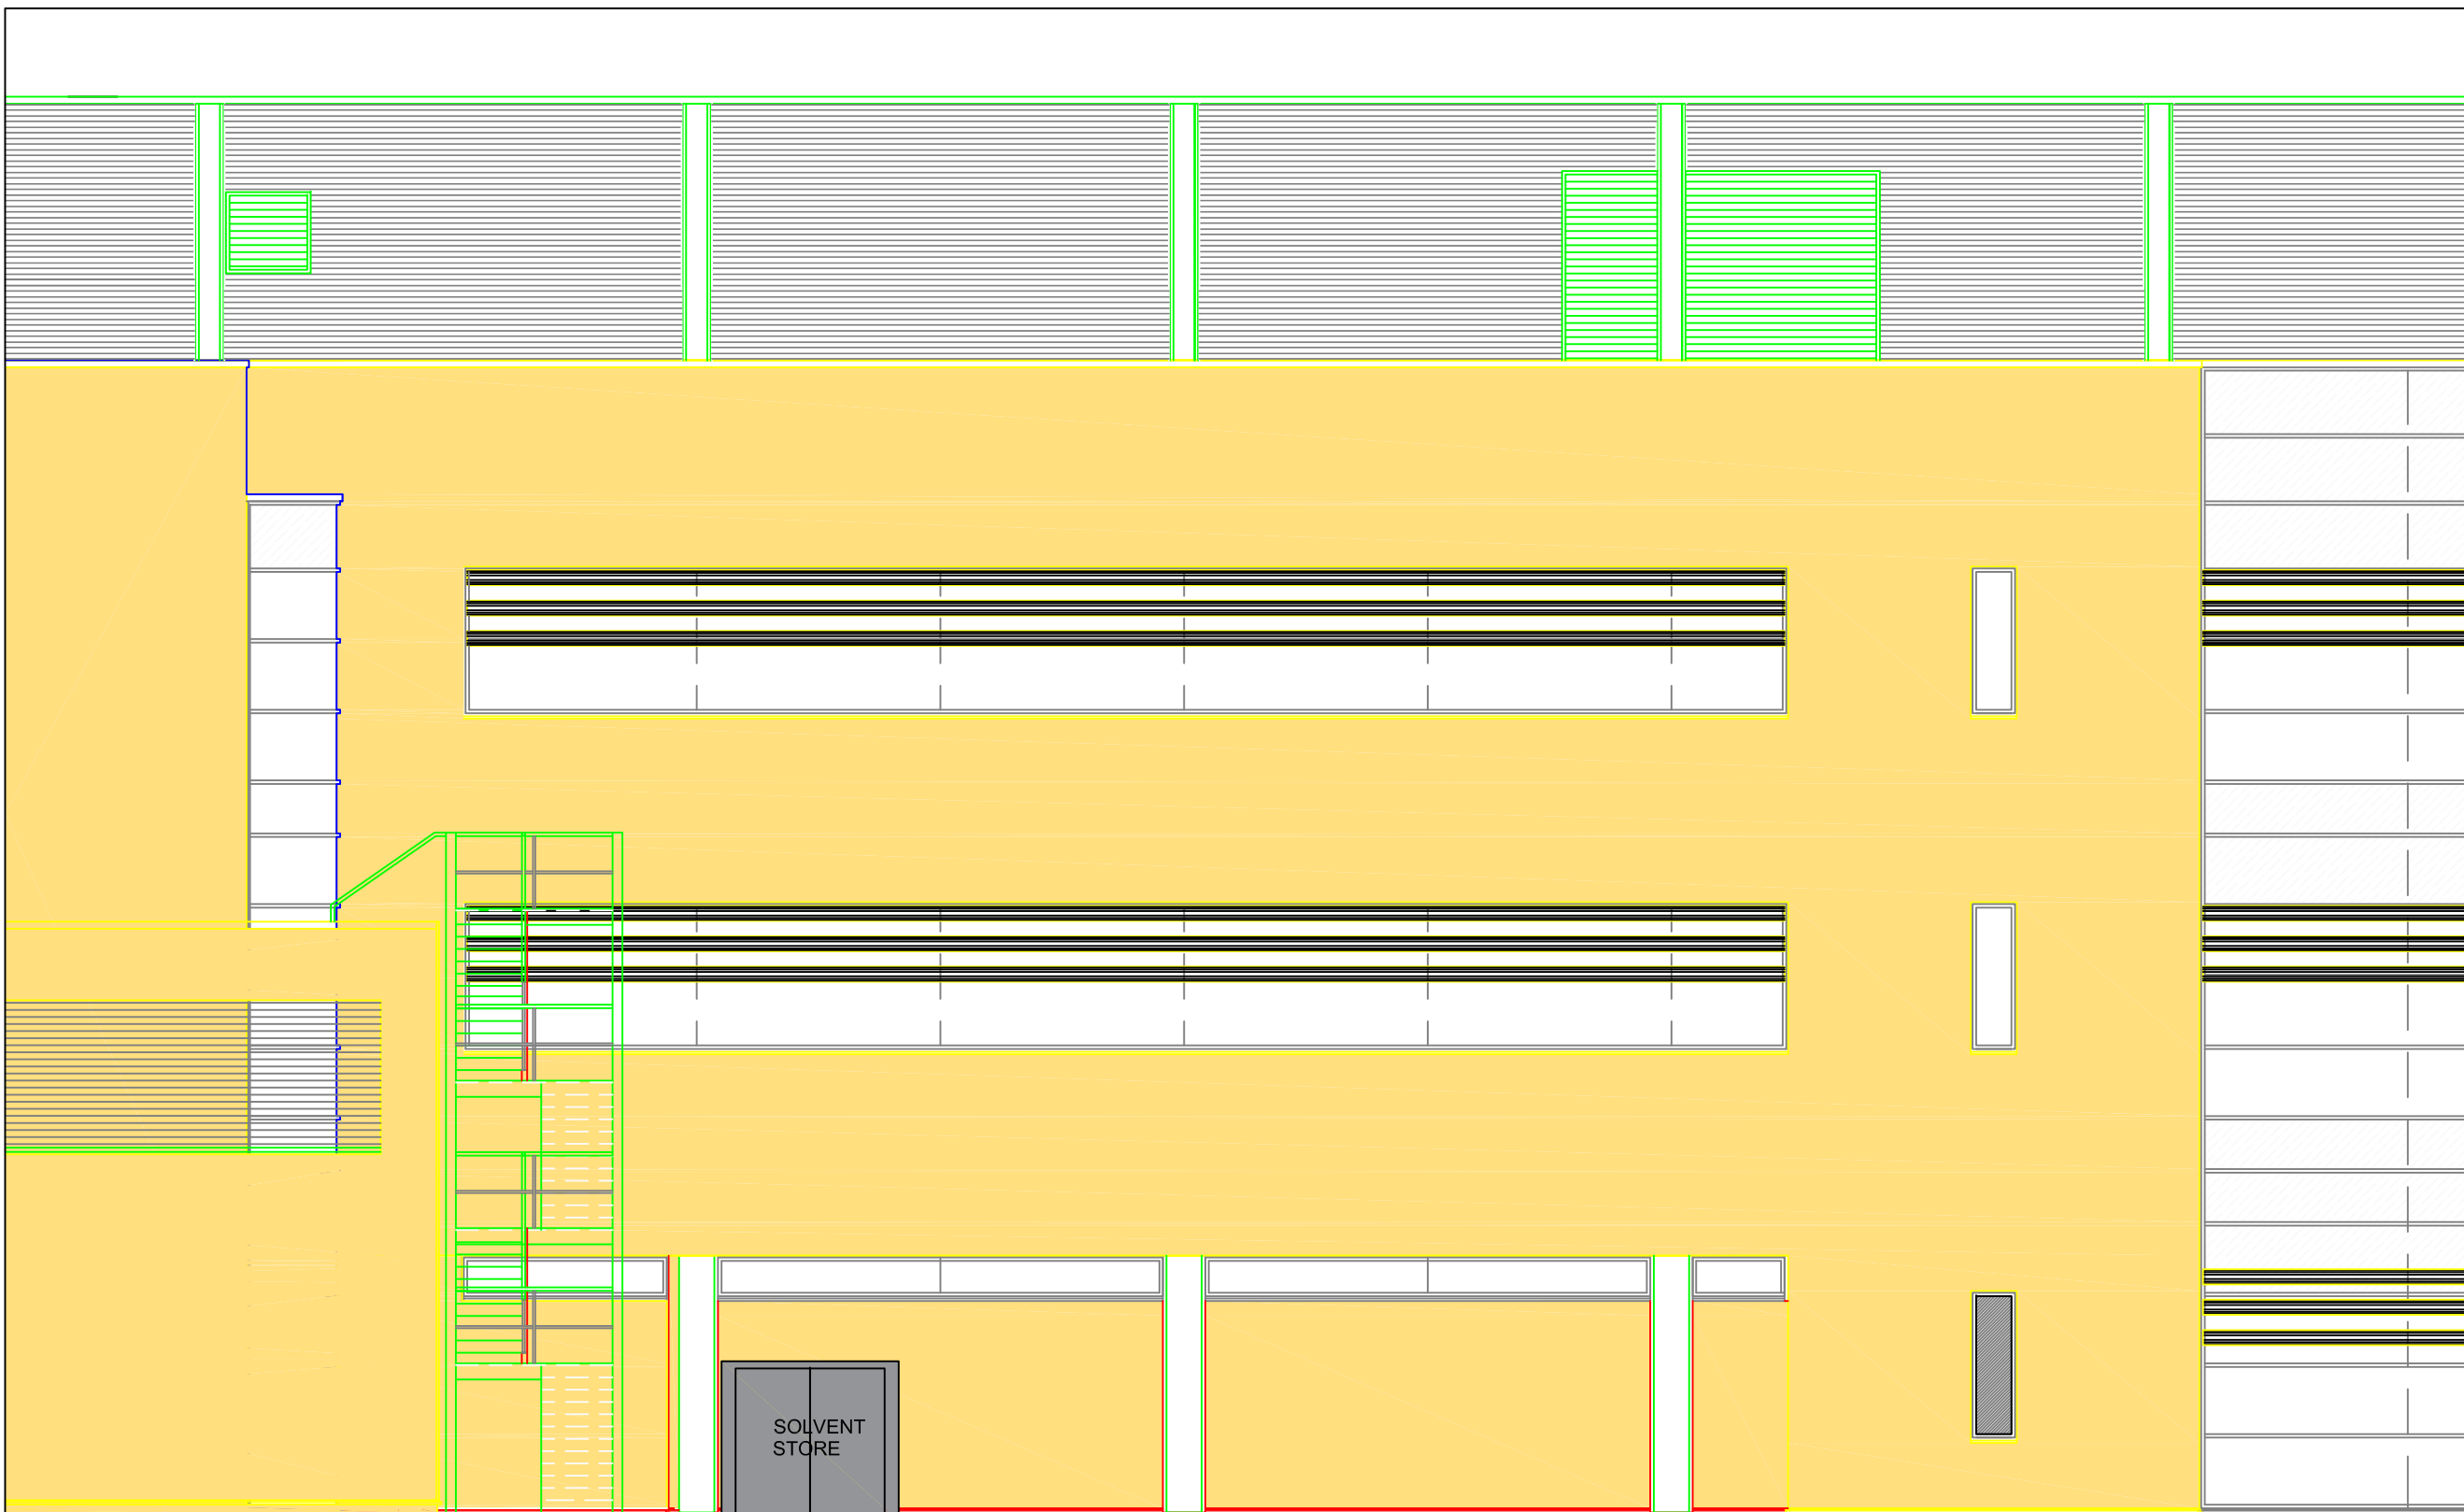

Rev:	CCR:	Date:	Description:

Created	ENG. Reviewed 1	ENG. Reviewed 2 (P&ID Only)	ENG. Approved
Name	Name	Name	Name
Sign	Sign	Sign	Sign
Date	Date	Date	Date



European Knowledge Centre
Mosquito Way
Hatfield
Hertfordshire, AL10 9SN

Tel :- 0845 676 1400
Fax :- 0845 676 5050
Website :- www.eisai.co.uk

Updated from original vendor drawing:
Drawing No. Revision: Date:


THIRD ANGLE PROJECTION

Project:
**EISAI
EML**

Drawing Title:
**CHEMICAL
STORAGE UNIT
PROPOSED SOUTH WEST ELEVATION**

Drawing Status:

Drawn:	Date:	Scale:	Sheet:
Checked:	Date:	Size:	Revision:
Drawing No.		A3	
CS09			

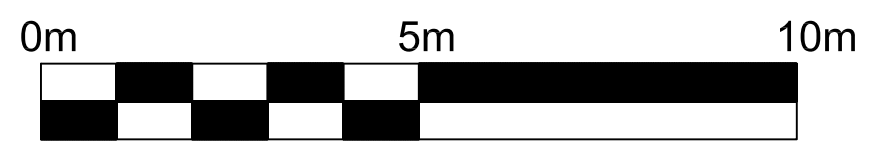

SOUTH WEST ELEVATION