


Copyright
 This drawing/specification is the property of Eisai Limited and may not be reproduced or disclosed to a third party in any form without written permission from the company.

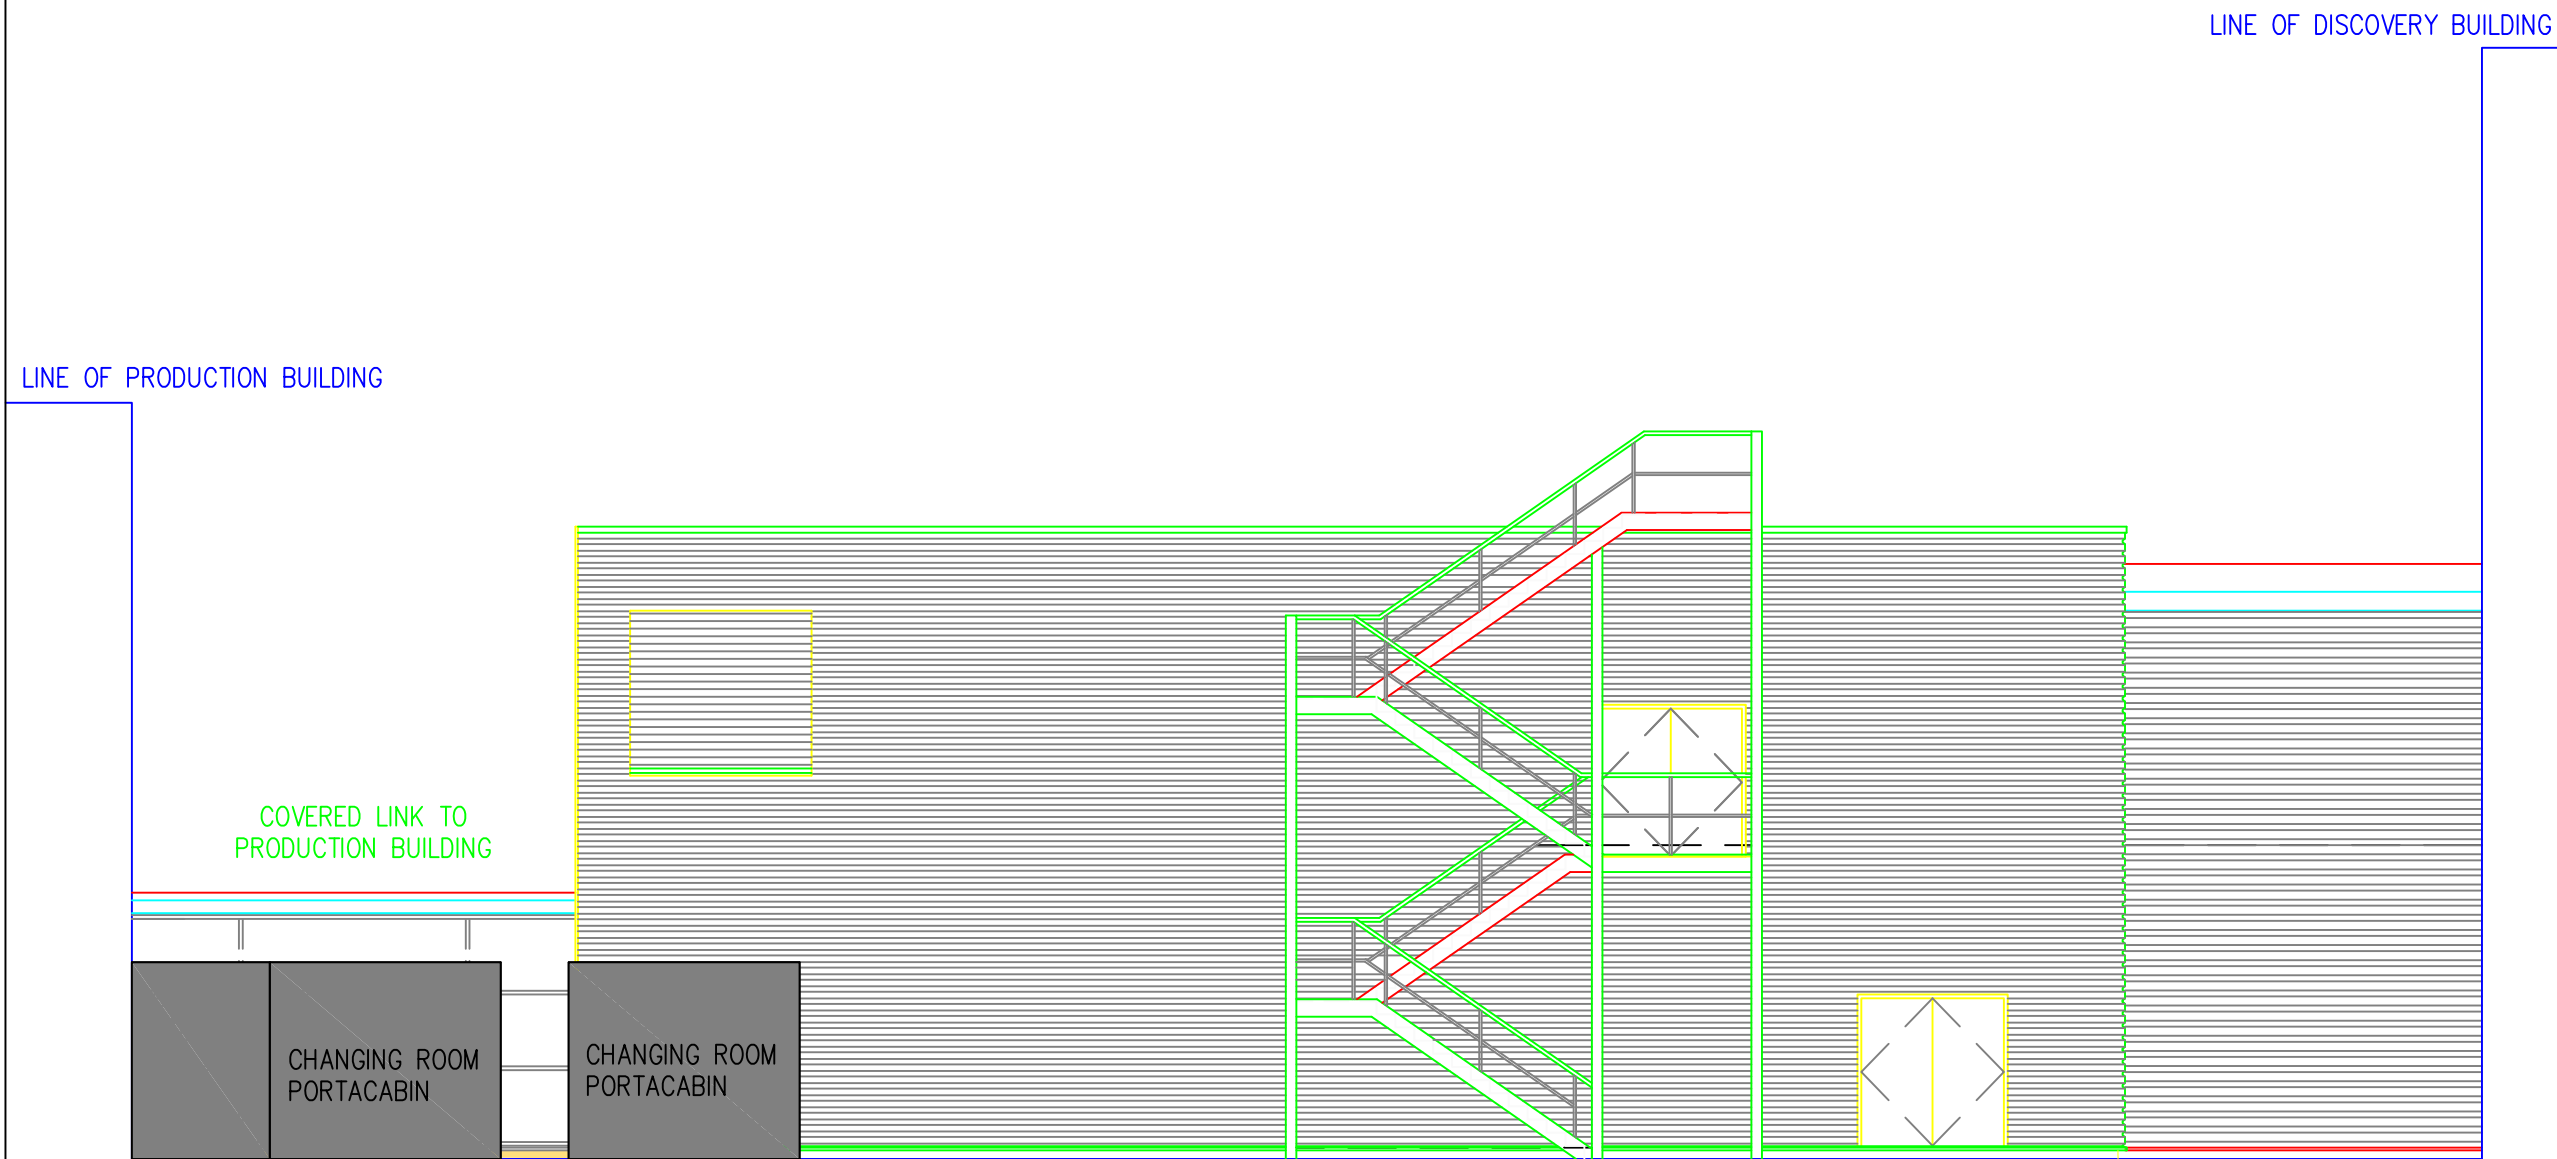

LINE OF PRODUCTION BUILDING


LINE OF DISCOVERY BUILDING

COVERED LINK TO PRODUCTION BUILDING

CHANGING ROOM PORTACABIN

CHANGING ROOM PORTACABIN

 
SOUTH EAST ELEVATION

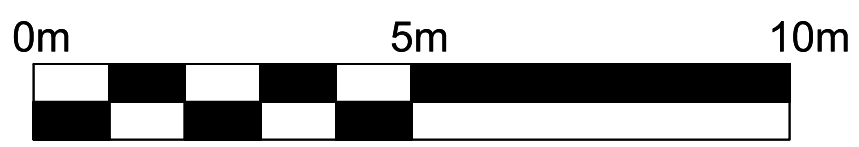

Rev:	CCR:	Date:	Description:
Created	ENG. Reviewed 1	ENG. Reviewed 2 (P&ID Only)	ENG. Approved
Name	Name	Name	Name
Sign	Sign	Sign	Sign
Date	Date	Date	Date



European Knowledge Centre
 Mosquito Way
 Hatfield
 Hertfordshire, AL10 9SN
 Tel :- 0845 676 1400
 Fax :- 0845 676 5050
 Website :- www.eisai.co.uk

Updated from original vendor drawing:		
Drawing No.	Revision:	Date:
 THIRD ANGLE PROJECTION		

Project:
 EML
 EISAI

Drawing Title:
 CHEMICAL STORAGE UNIT
 EXISTING SOUTH EAST ELEVATION

Drawn:	Date:	Scale:	Sheet:
Checked:	Date:	Size	Revision
Drawing No.		CS10	