



Copyright  
 This drawing/specification is the property of Eisai Limited and may not be reproduced or disclosed to a third party in any form without written permission from the company.

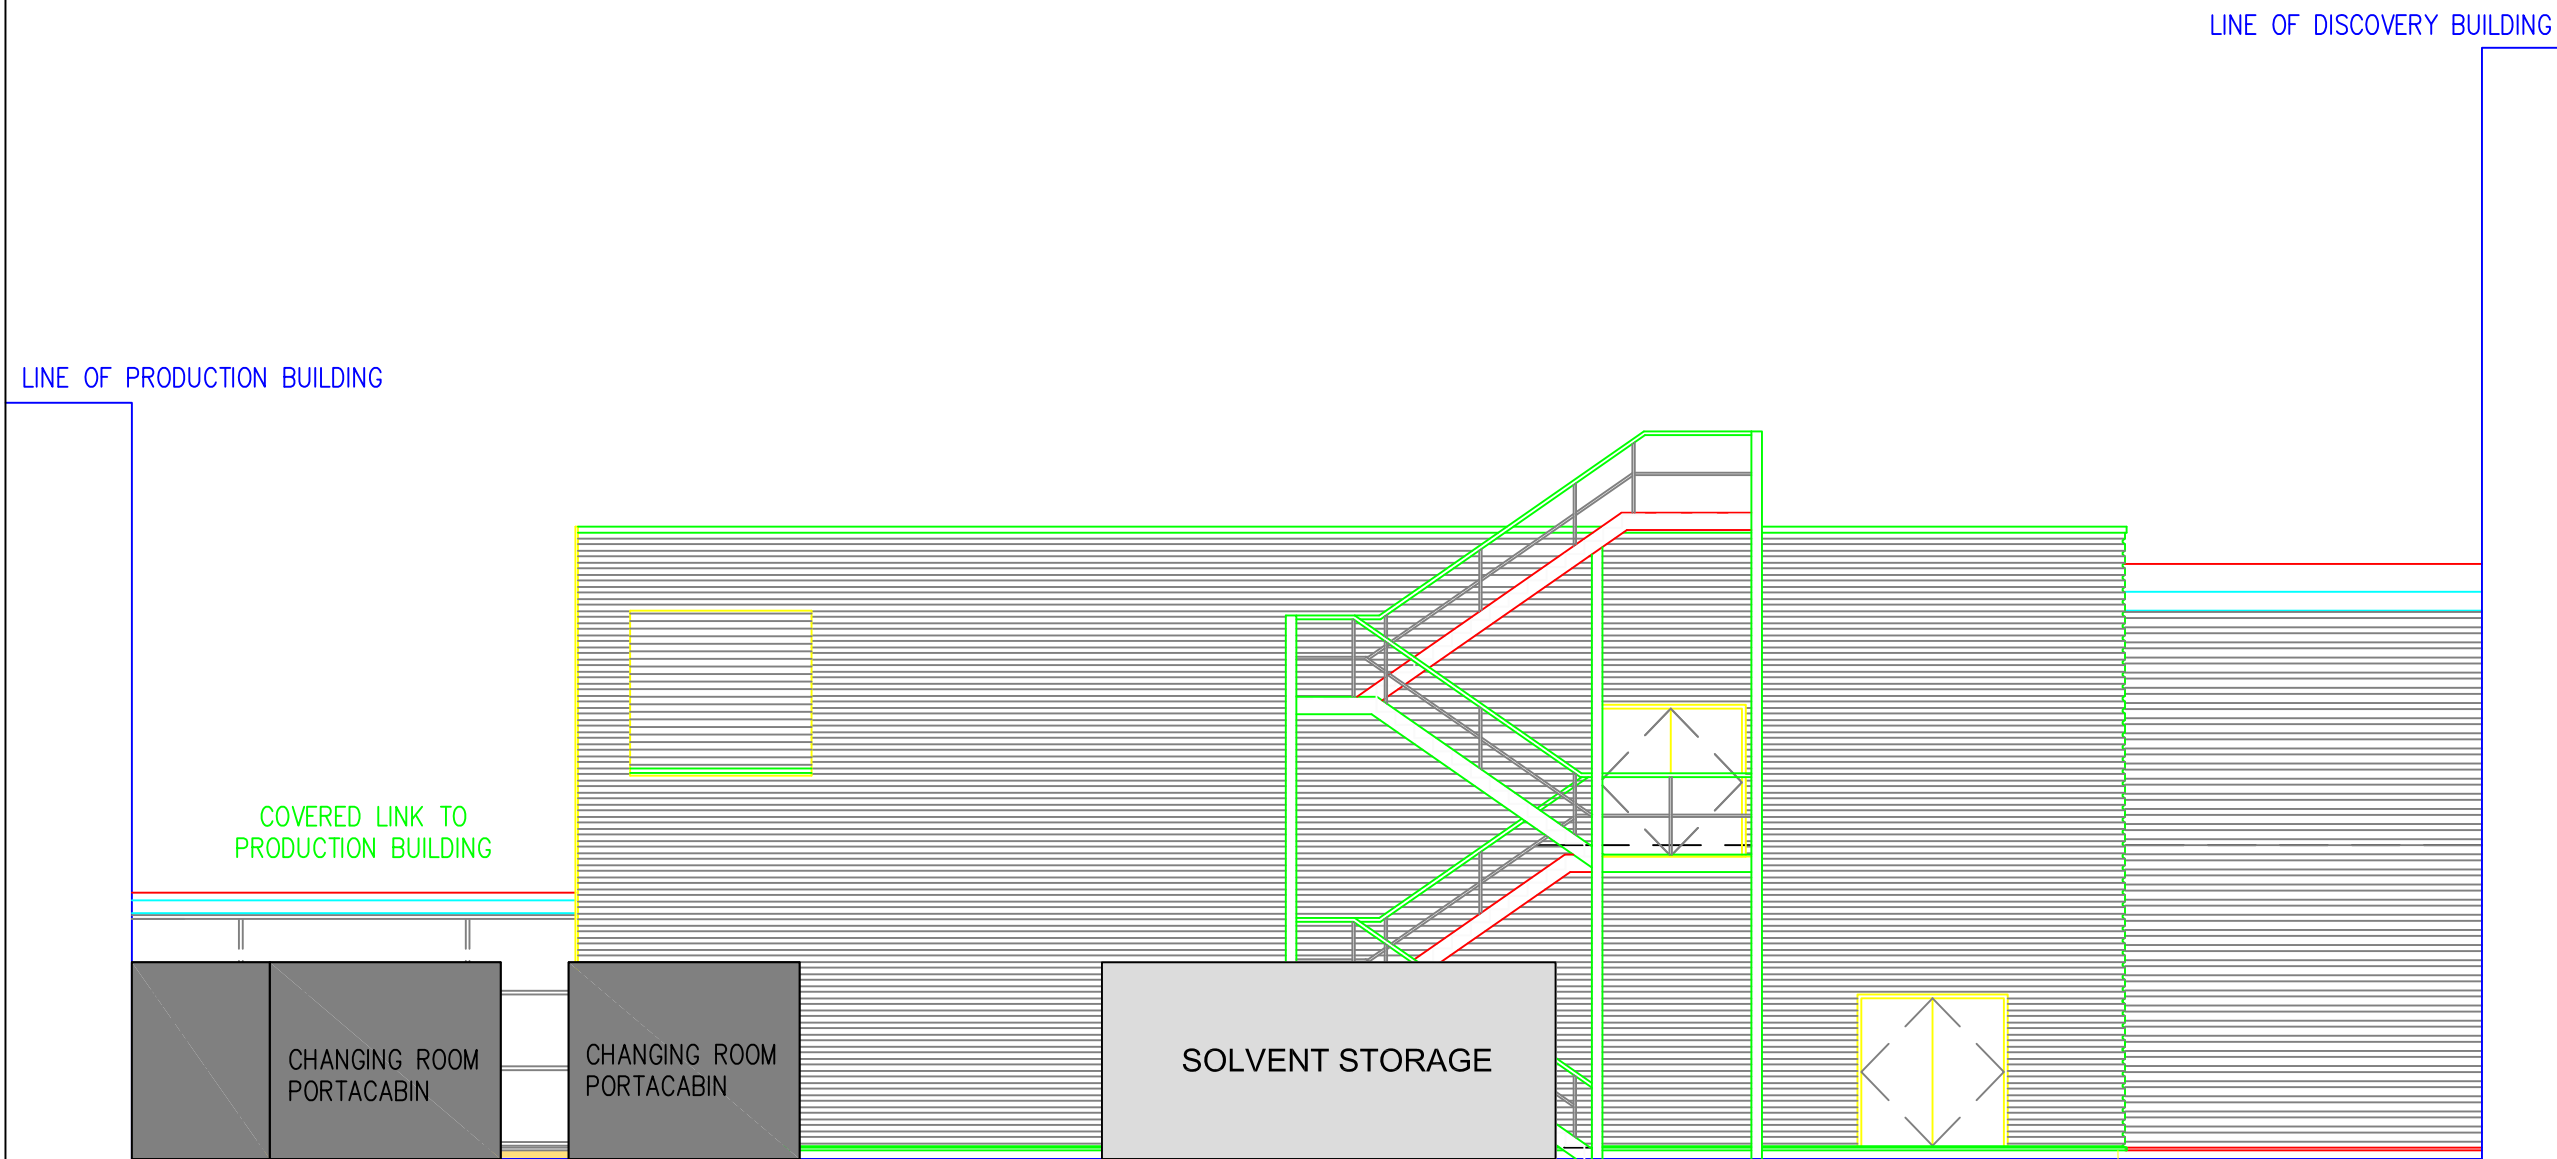

# SOUTH EAST ELEVATION

 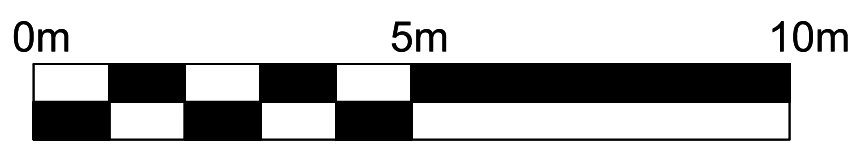



Rev:	CCR:	Date:	Description:
Created	ENG. Reviewed 1	ENG. Reviewed 2 (P&ID Only)	ENG. Approved
Name	Name	Name	Name
Sign	Sign	Sign	Sign
Date	Date	Date	Date



European Knowledge Centre  
 Mosquito Way  
 Hatfield  
 Hertfordshire, AL10 9SN  
 Tel :- 0845 676 1400  
 Fax :- 0845 676 5050  
 Website :- www.eisai.co.uk

Updated from original vendor drawing:		
Drawing No.	Revision:	Date:



Project:  
 EML  
 EISAI

Drawing Title:  
 CHEMICAL STORAGE UNIT  
 PROPOSED SOUTH EAST ELEVATION

Drawn:	Date:	Scale:	Sheet:
		1:100	
Checked:	Date:	Size:	Revision:
		A3	
Drawing No. CS11			