



Copyright
 This drawing/specification is the property of Eisai Limited and may not be reproduced or disclosed to a third party in any form without written permission from the company.

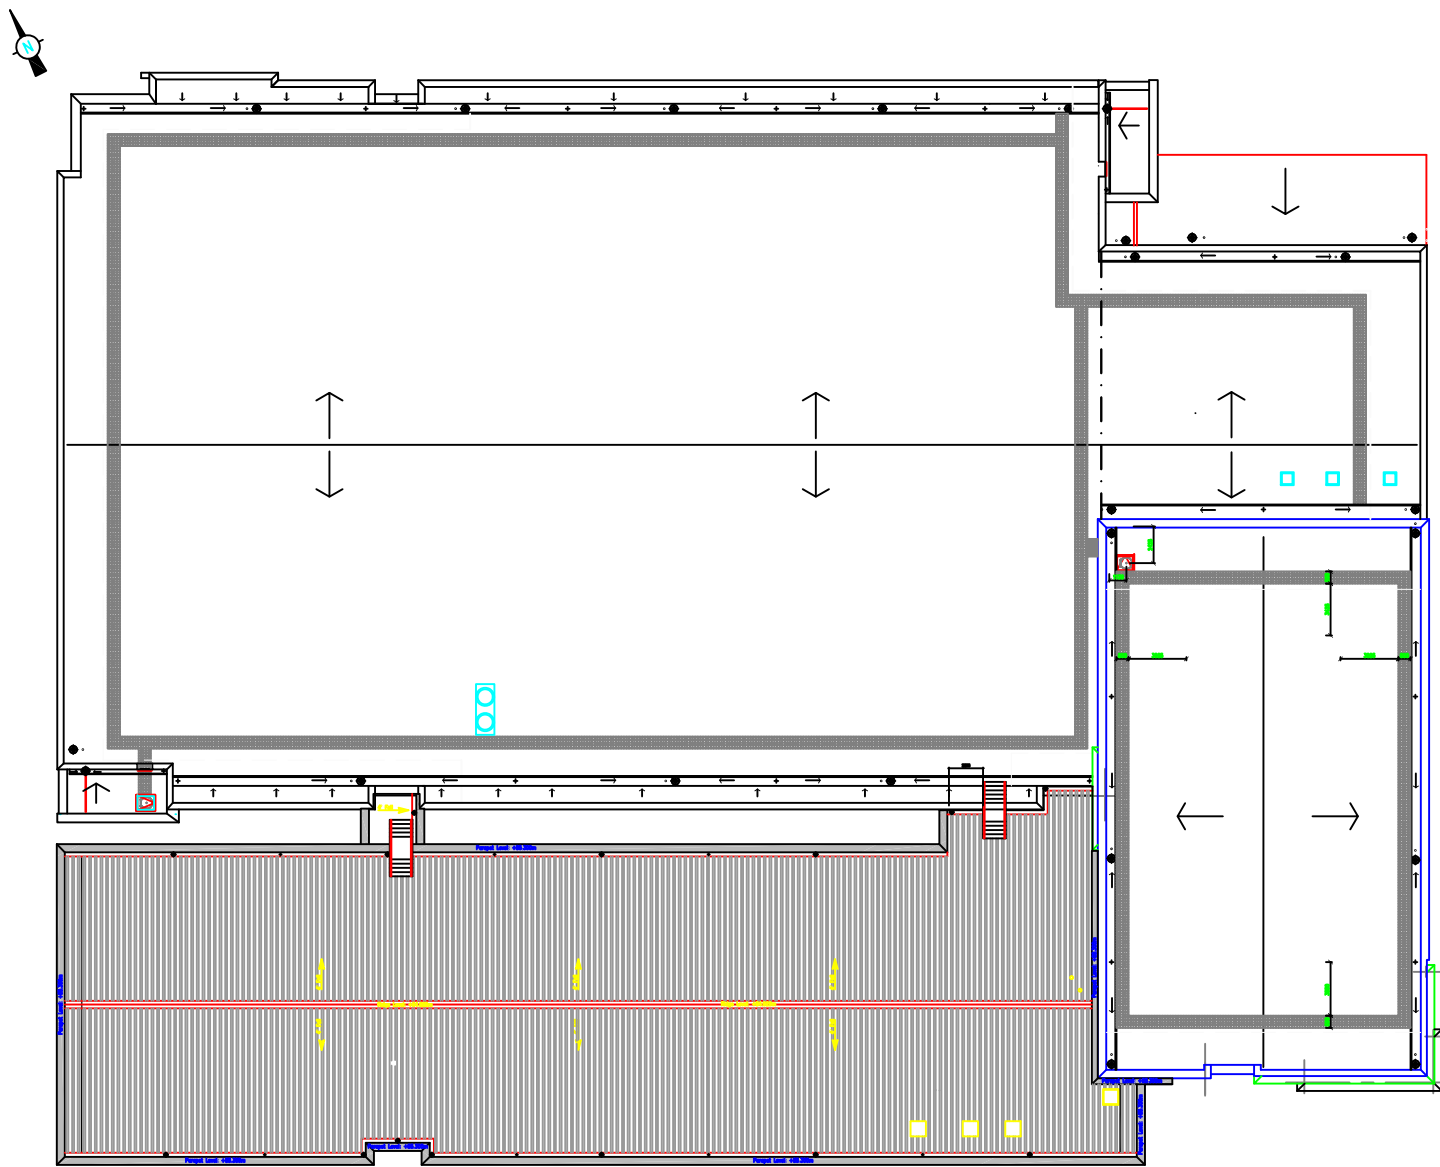


| Rev: | CCR: | Date: | Description: |
|------|------|-------|--------------|
| | | | |
| | | | |
| | | | |

| Created | ENG. Reviewed 1 | ENG. Reviewed 2 (P&ID Only) | ENG. Approved |
|---------|-----------------|-----------------------------|---------------|
| Name | Name | Name | Name |
| Sign | Sign | Sign | Sign |
| Date | Date | Date | Date |

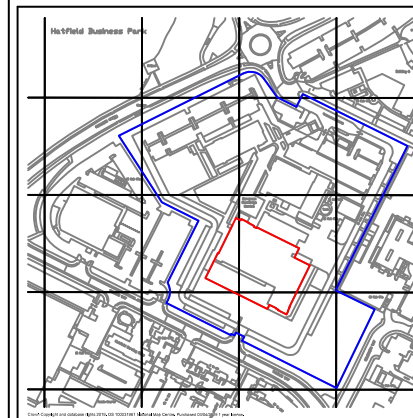

European Knowledge Centre
 Mosquito Way
 Hatfield
 Hertfordshire, AL10 9SN
 Tel :- 0845 676 1400
 Fax :- 0845 676 5050
 Website :- www.eisai.co.uk

 Updated from original vendor drawing:
 Drawing No. Revision: Date:



THIRD ANGLE PROJECTION

Project:
**EISAI
 PRODUCTION BUILDING
 ROOF CHILLER INSTALLATION**

Drawing Title:
**PRODUCTION BUILDING
 EXISTING ROOF PLAN**

Drawing Status:

| | | | |
|----------|-------|--------|----------|
| Drawn: | Date: | Scale: | Sheet |
| Checked: | Date: | Size | Revision |

Drawing No.
EISAI_PC_03