
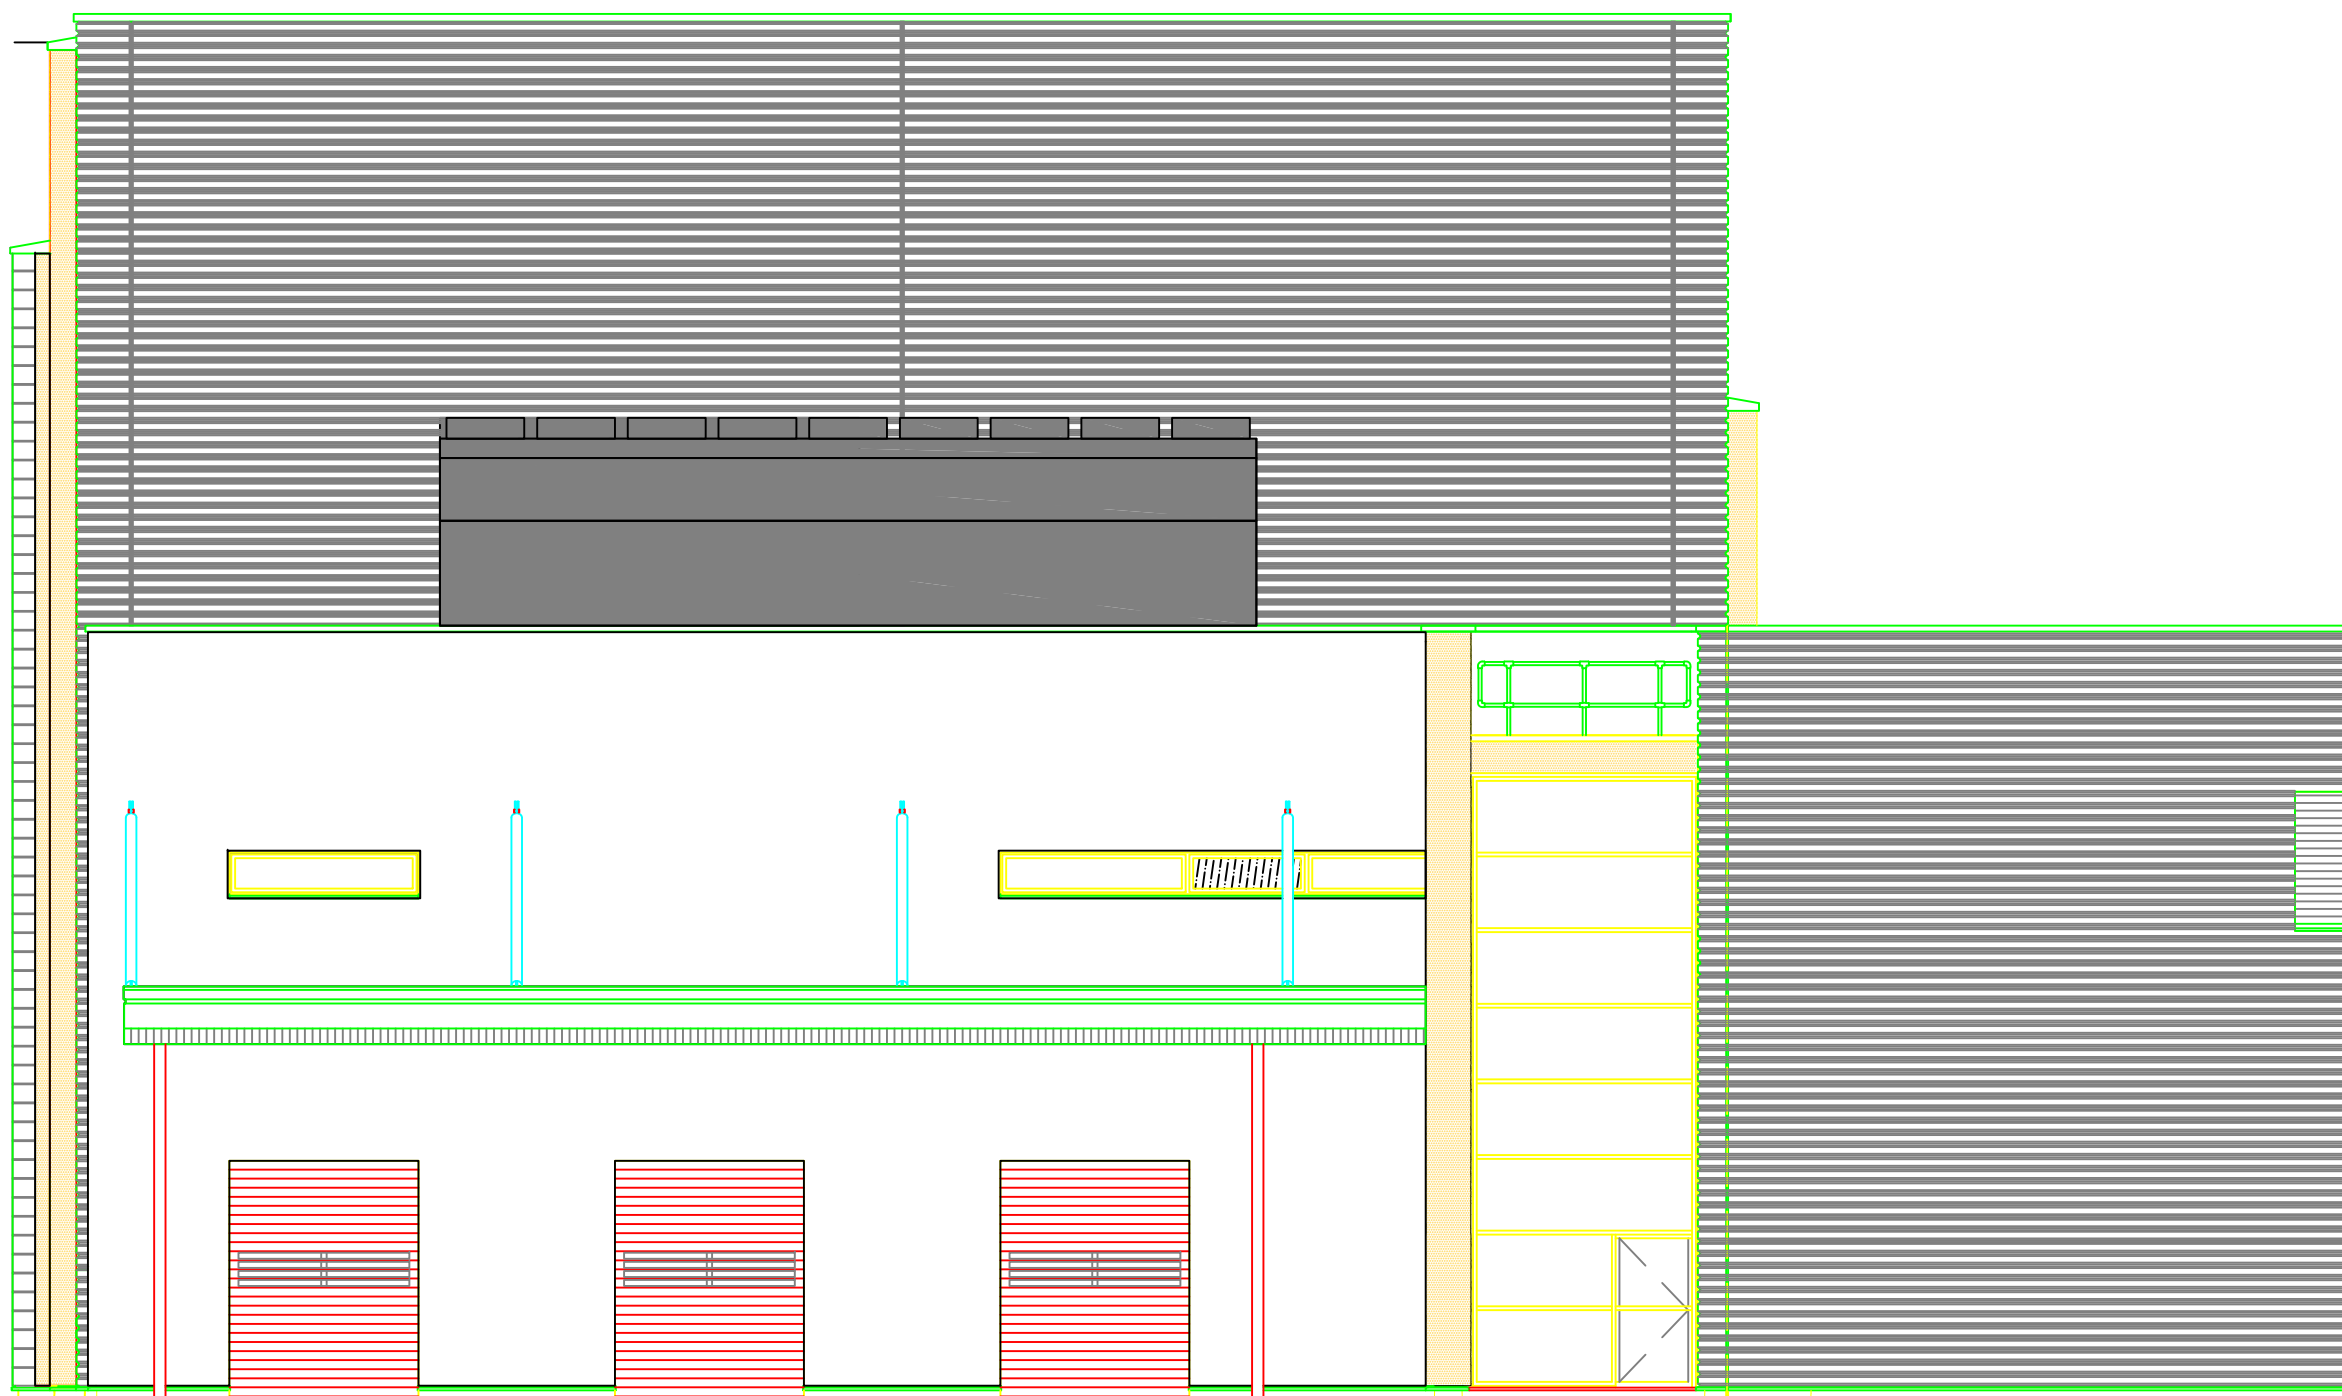


Copyright
 This drawing/specification is the property of Eisai Limited and may not be reproduced or disclosed to a third party in any form without written permission from the company.

 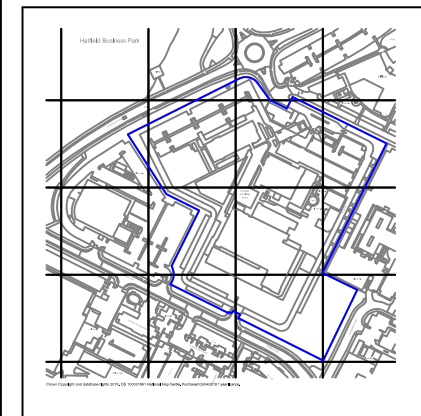


NORTH EAST ELEVATION

Rev:	CCR:	Date:	Description:

Created	ENG. Reviewed 1	ENG. Reviewed 2 (P&ID Only)	ENG. Approved
Name	Name	Name	Name
Sign	Sign	Sign	Sign
Date	Date	Date	Date

Eisai Ltd.
 European Knowledge Centre
 Mosquito Way
 Hatfield
 Hertfordshire, AL10 9SN
 Tel :- 0845 676 1400
 Fax :- 0845 676 5050
 Website :- www.eisai.co.uk

Updated from original vendor drawing:
 Drawing No. Revision: Date:

 THIRD ANGLE PROJECTION

Project:
**EISAI
 PRODUCTION BUILDING
 ROOF CHILLER INSTALLATION**

Drawing Title:
**PRODUCTION BUILDING
 ELEVATION OF PROPOSED
 CHILLER INSTALLATION SCALE 1:100**

Drawn:	Date:	Scale: 1:100 @ A3	Sheet
Checked:	Date:	Size A3	Revision
Drawing No. EISAI_PC_06			