

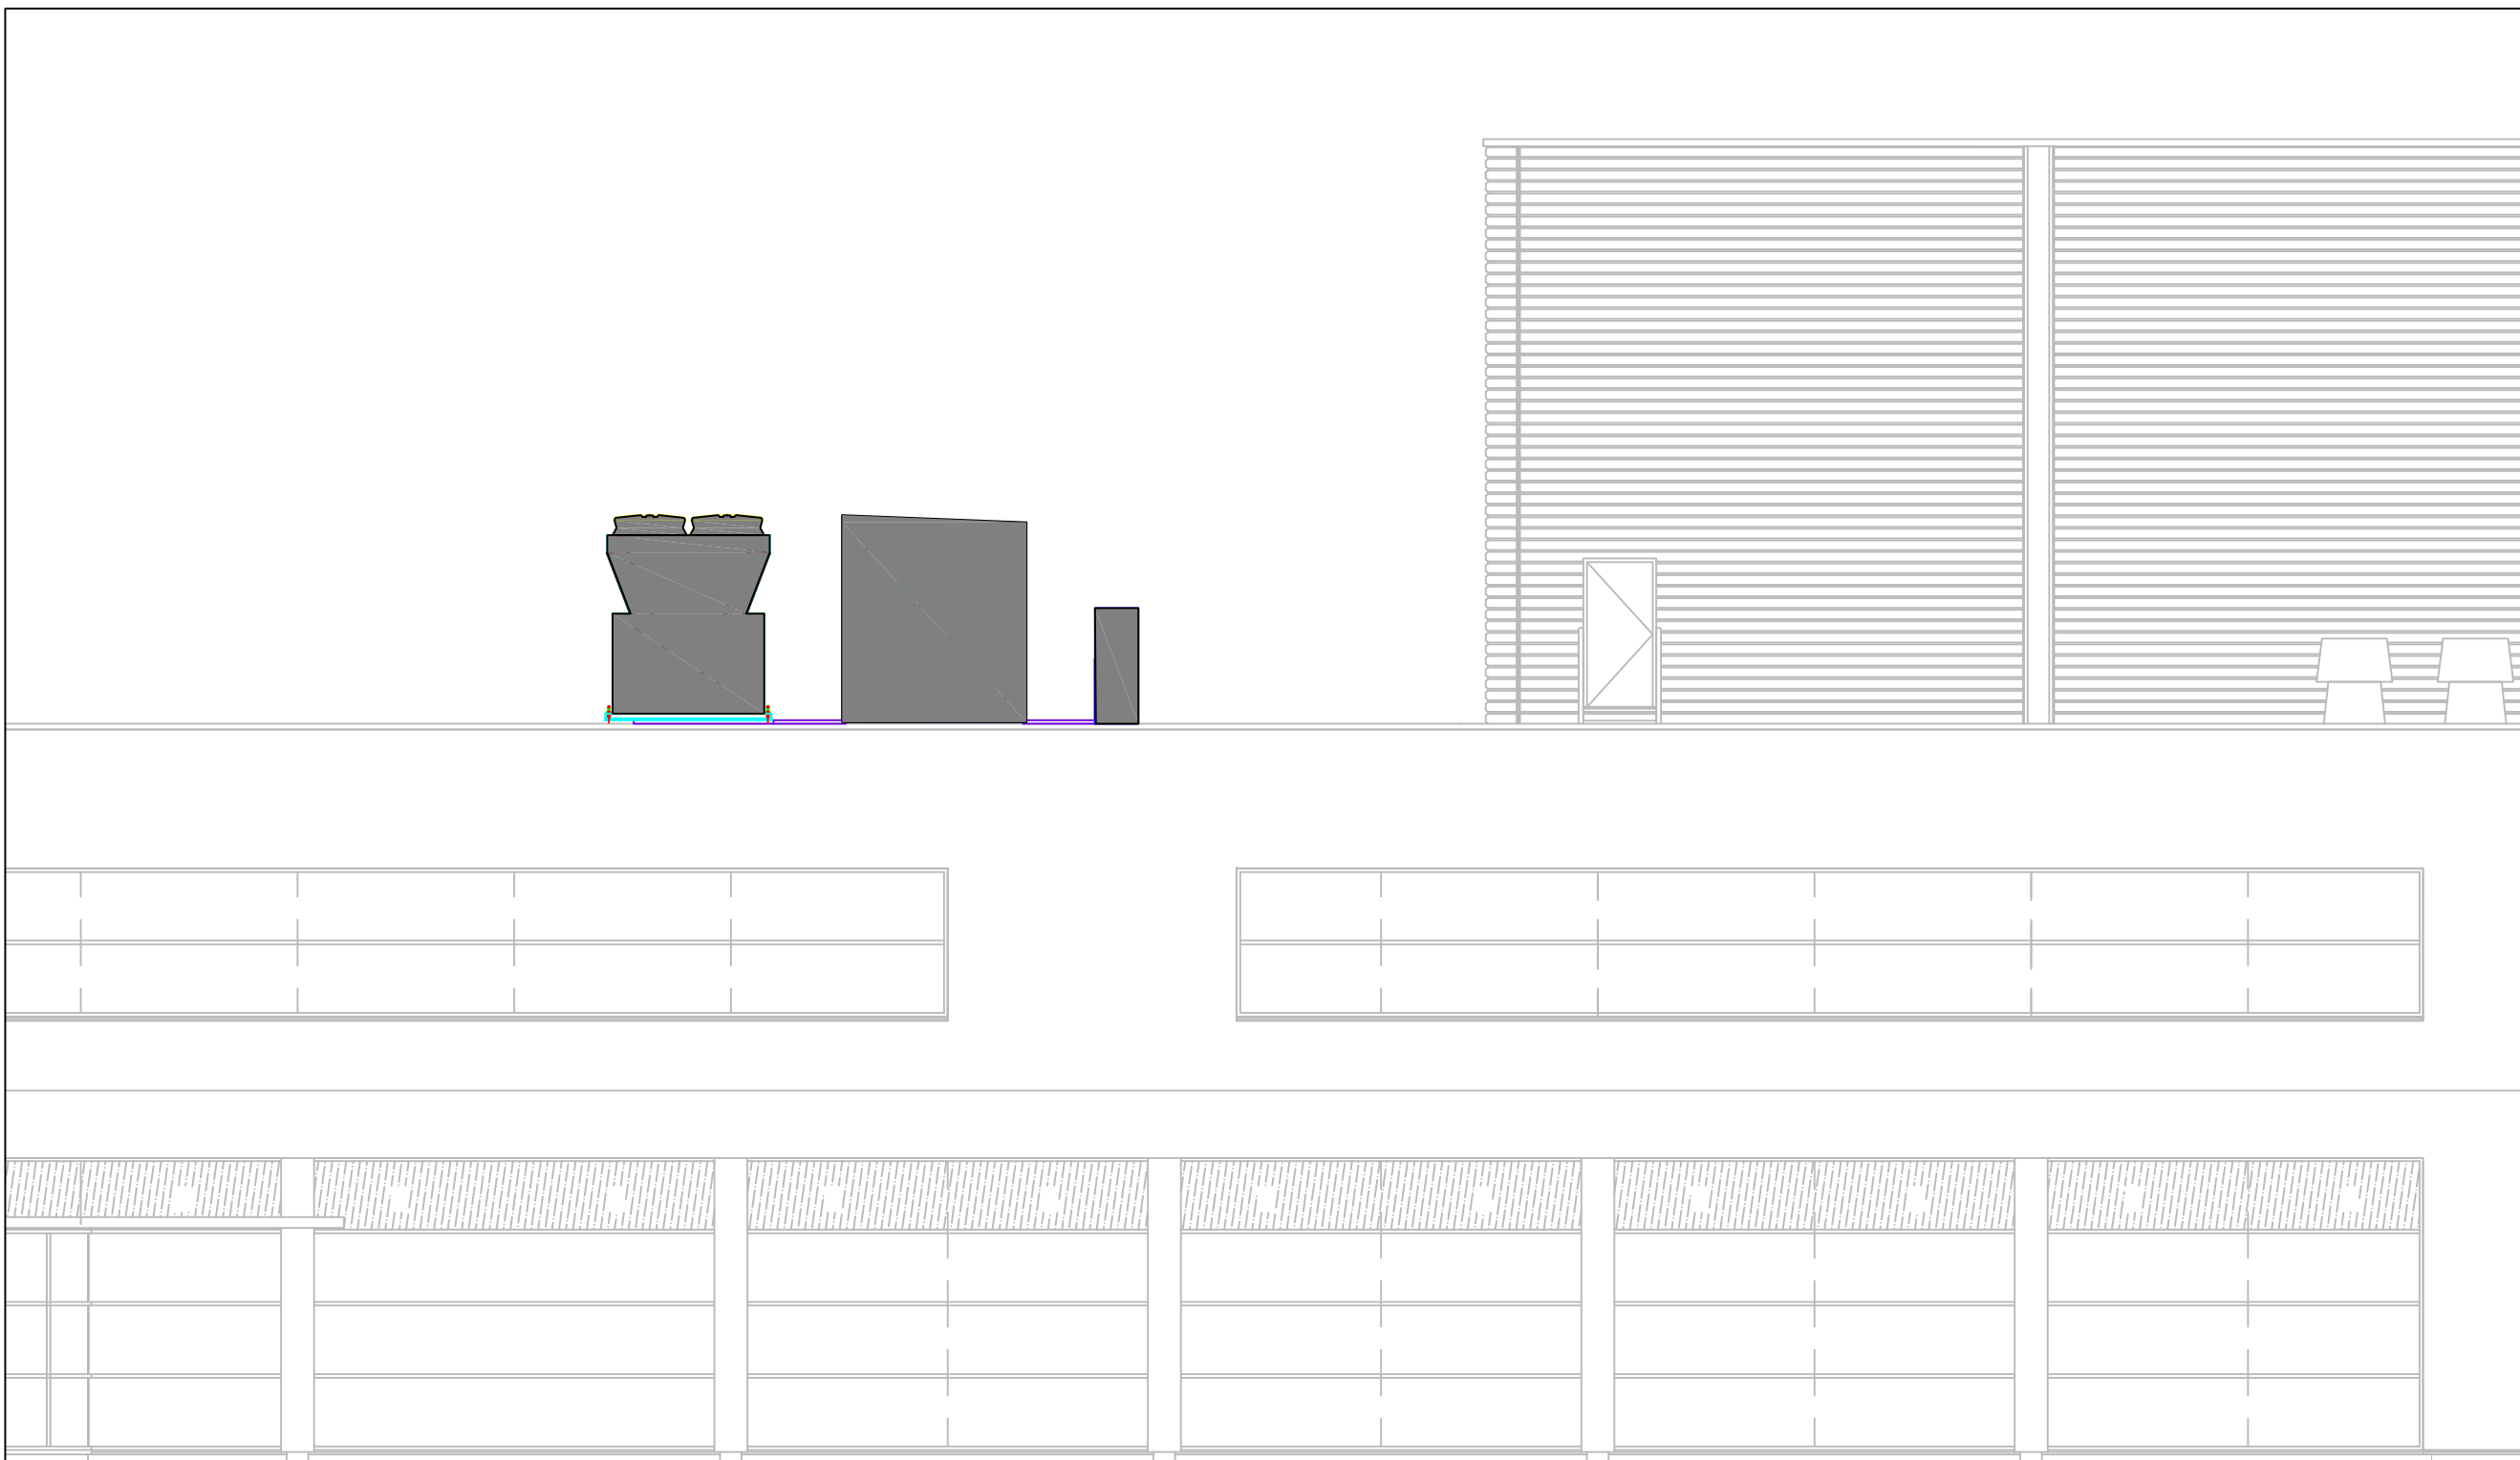


Copyright
This drawing/specification is the property of Elsal Limited and may not be reproduced or disclosed to a third party in any form without written permission from the company.

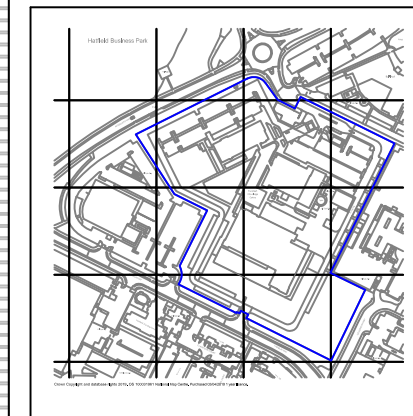

NORTH WEST ELEVATION

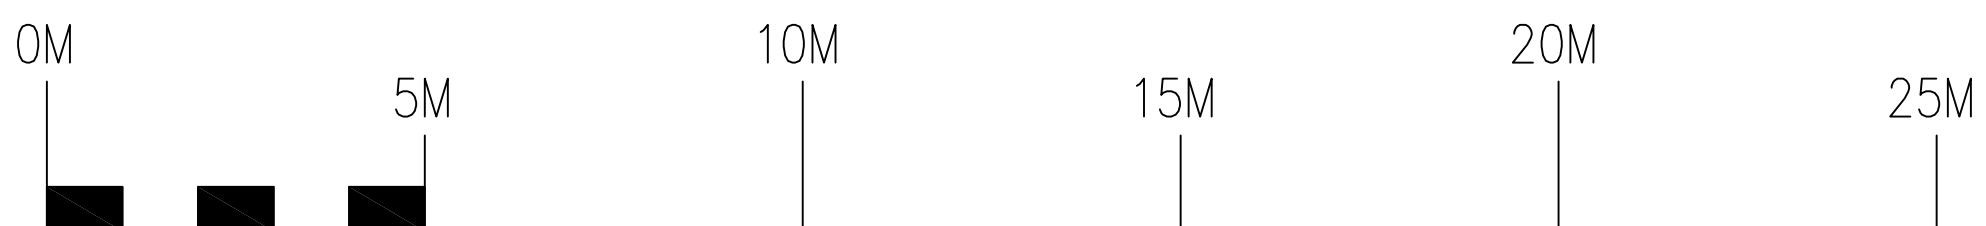


Rev:	CCR:	Date:	Description:
Created	ENG. Reviewed 1	ENG. Reviewed 2 (P&ID Only)	ENG. Approved
Name	Name	Name	Name
Sign	Sign	Sign	Sign
Date	Date	Date	Date



European Knowledge Centre
Mosquito Way
Hatfield
Hertfordshire, AL10 9SN

Tel :- 0845 676 1400
Fax :- 0845 676 5050
Website :- www.eisai.co.uk

Updated from original vendor drawing:			 THIRD ANGLE PROJECTION
Drawing No.	Revision;	Date;	

Project:
EISAI
PRODUCTION BUILDING
ROOF CHILLER INSTALLATION

3 Drawing Title:
PRODUCTION BUILDING
NW ELEVATION OF PROPOSED
CHILLER INSTALLATION SCALE 1:100

Drawing Status:			
Drawn:	Date :	Scale:	Sheet:
		1:100 @ A3	
Checked :	Date :	Size	Revision
		A3	
Drawing No.			
EISAI_PC_07			