



Copyright  
 This drawing/specification is the property of Eisai Limited and may not be reproduced or disclosed to a third party in any form without written permission from the company.

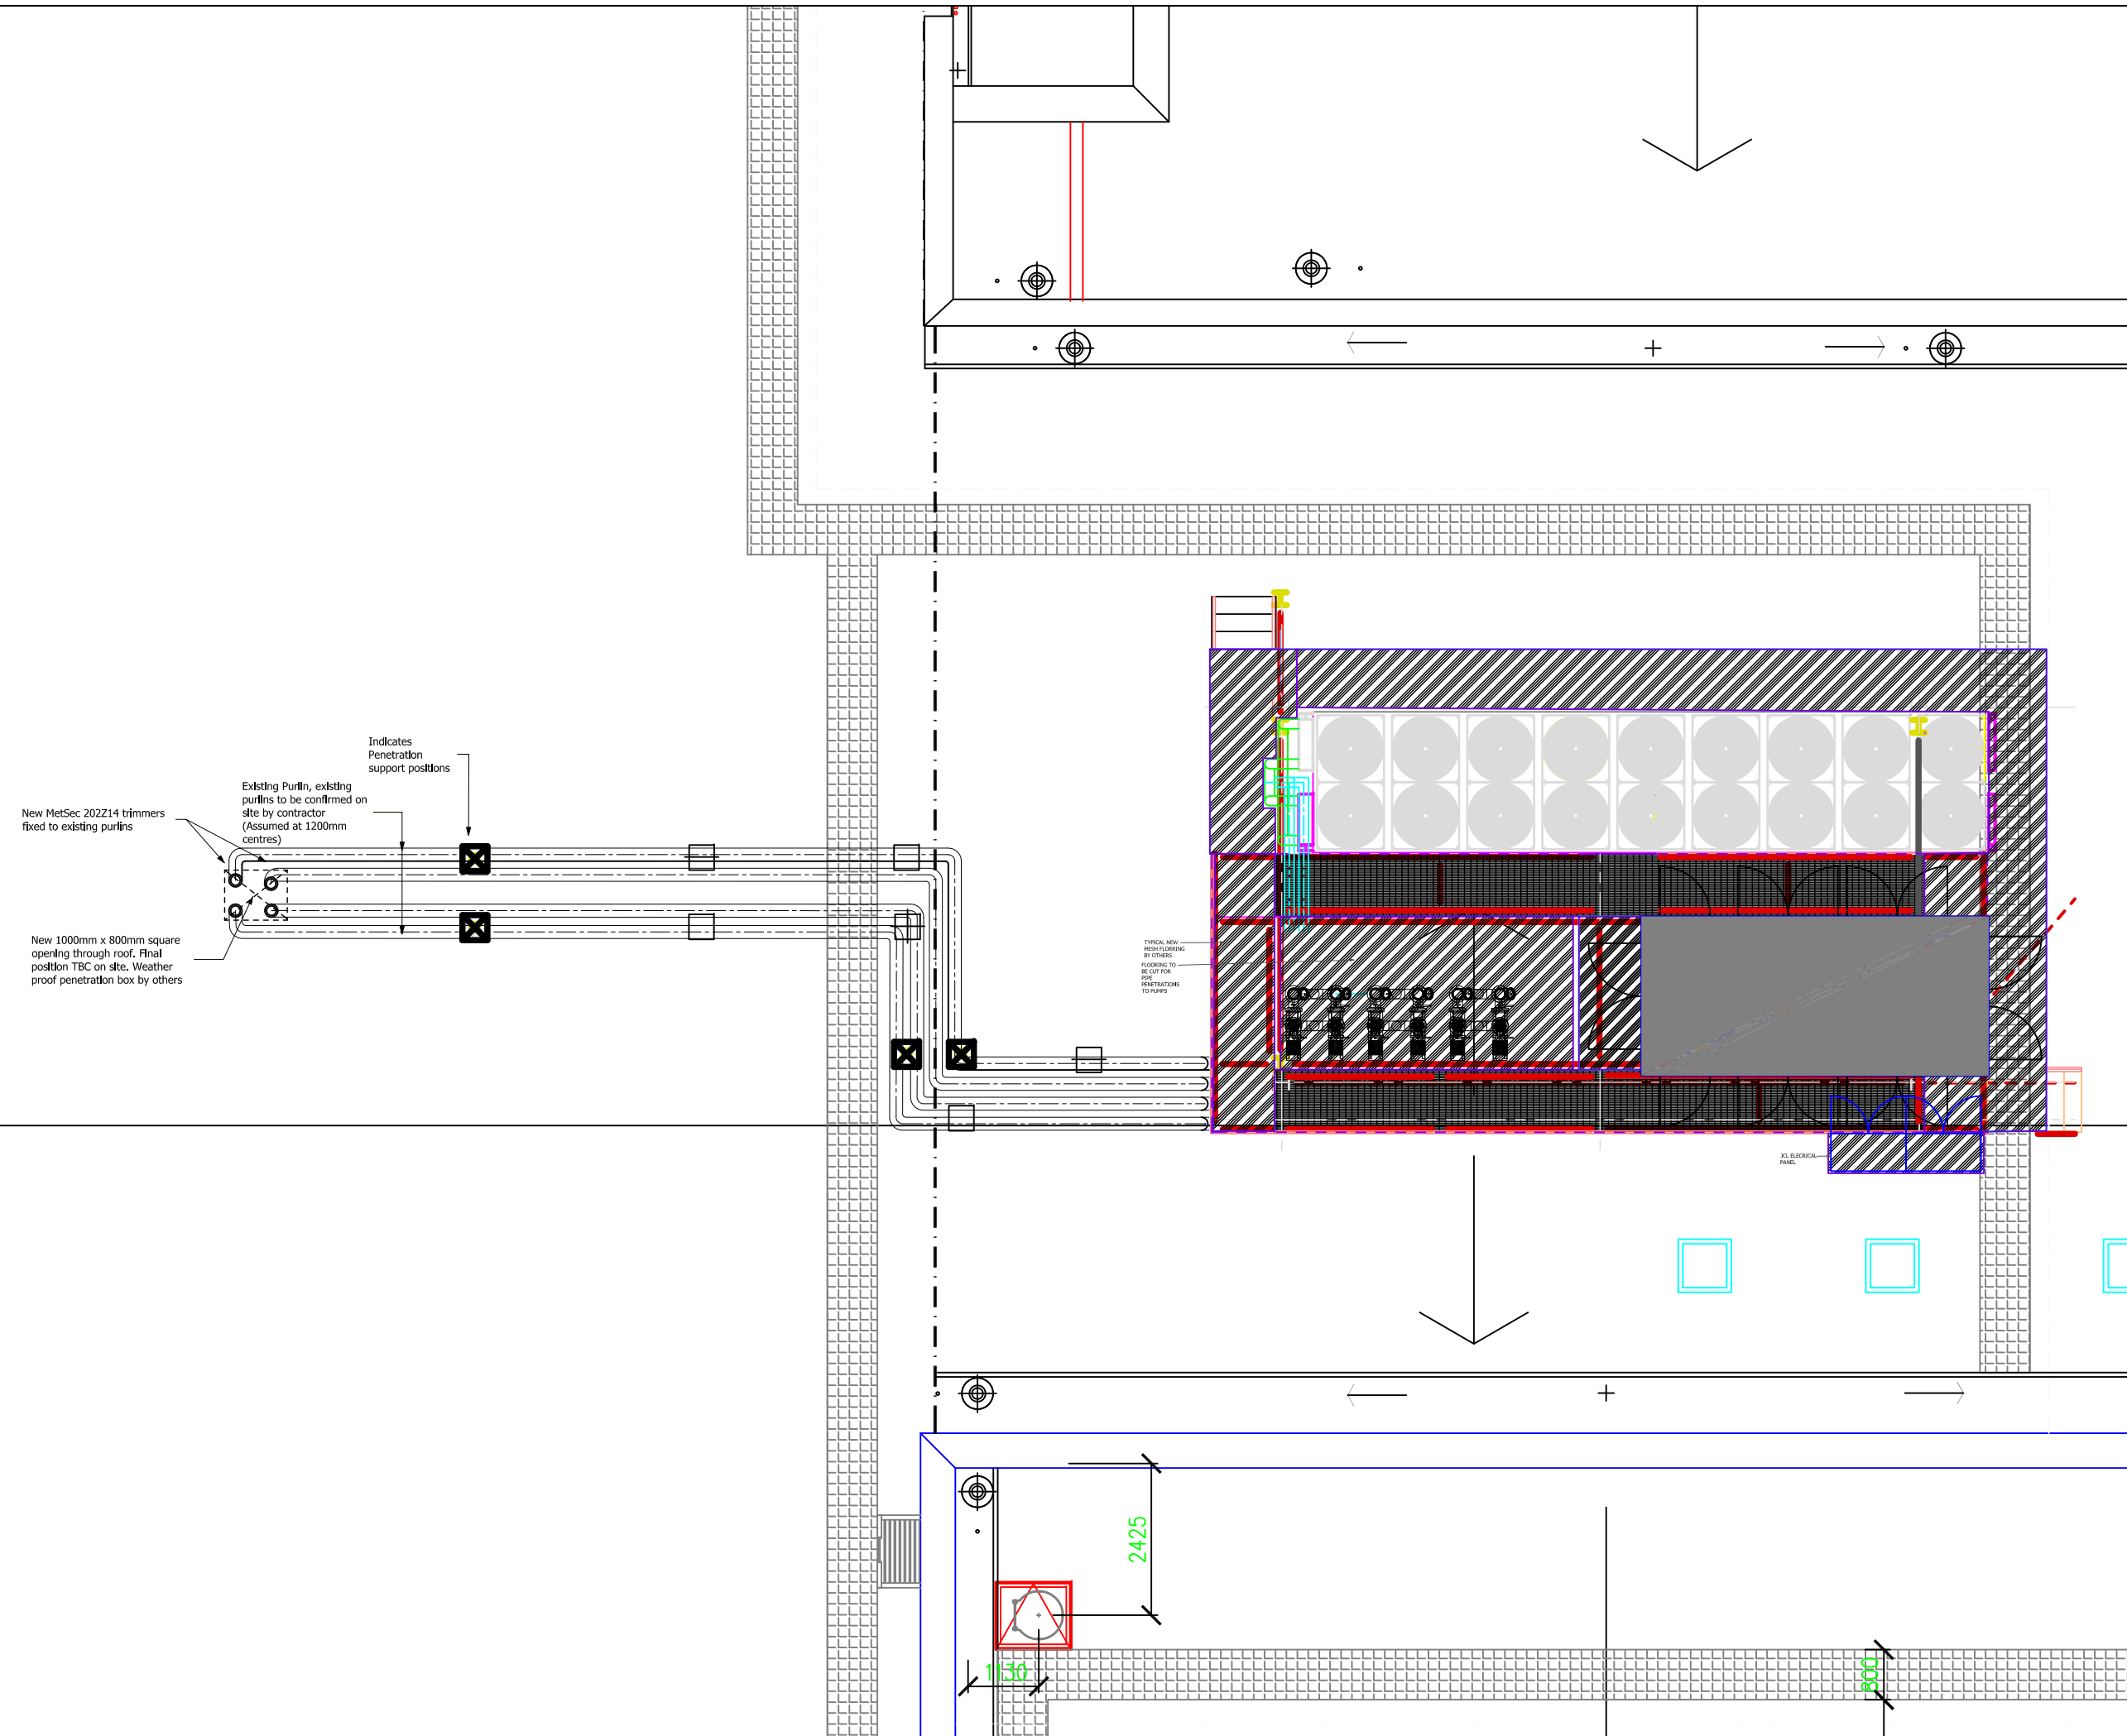

| Created | ENG. Reviewed 1 | ENG. Reviewed 2 (P&ID Only) | ENG. Approved |
|---------|-----------------|-----------------------------|---------------|
| Name    | Name            | Name                        | Name          |
| Sign    | Sign            | Sign                        | Sign          |
| Date    | Date            | Date                        | Date          |

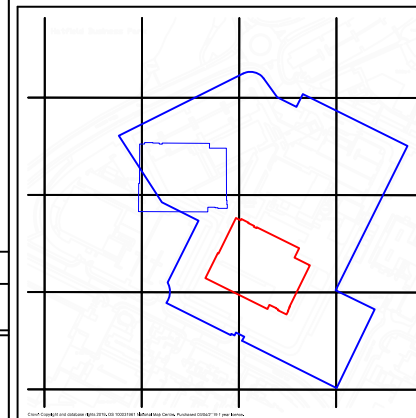

European Knowledge Centre  
 Mosquito Way  
 Hatfield  
 Hertfordshire, AL10 9SN

Tel :- 0845 676 1400  
 Fax :- 0845 676 5050  
 Website :- www.eisai.co.uk

|                                       |           |       |
|---------------------------------------|-----------|-------|
| Updated from original vendor drawing: |           |       |
| Drawing No.                           | Revision: | Date: |

THIRD ANGLE PROJECTION

Project:  
**Eisai  
 PRODUCTION BUILDING  
 ROOF CHILLER INSTALLATION**

Drawing Title:  
**PRODUCTION BUILDING  
 ROOF PLAN OF PROPOSED  
 CHILLER INSTALLATION SCALE 1:100**

|             |       |             |           |
|-------------|-------|-------------|-----------|
| Drawn:      | Date: | Scale:      | Sheet:    |
| Checked:    | Date: | Size:       | Revision: |
| Drawing No. |       | EISAI_PC_09 |           |