

03 SMOKING SHELTER NTS

Delta light - Riva 304 - 21-01 - Stainless steel down lights set @ 2.1m high





A IMAGE REFERENCE

Estead Lighting - UT/Negra Ground LED Floodlight 6170



B IMAGE REFERENCE

For drainage layout please refer to drawing nos. 7127-404, 7127-405 (Latest revisions)

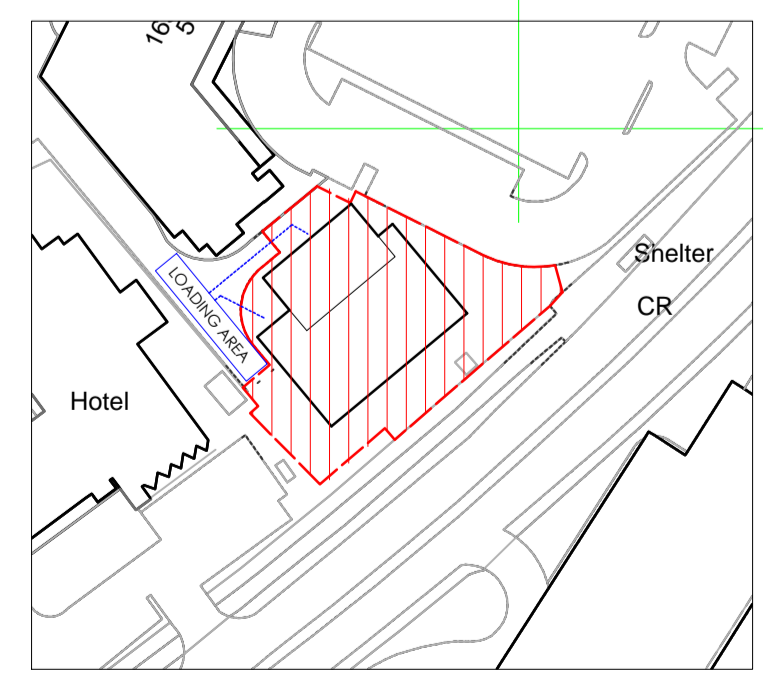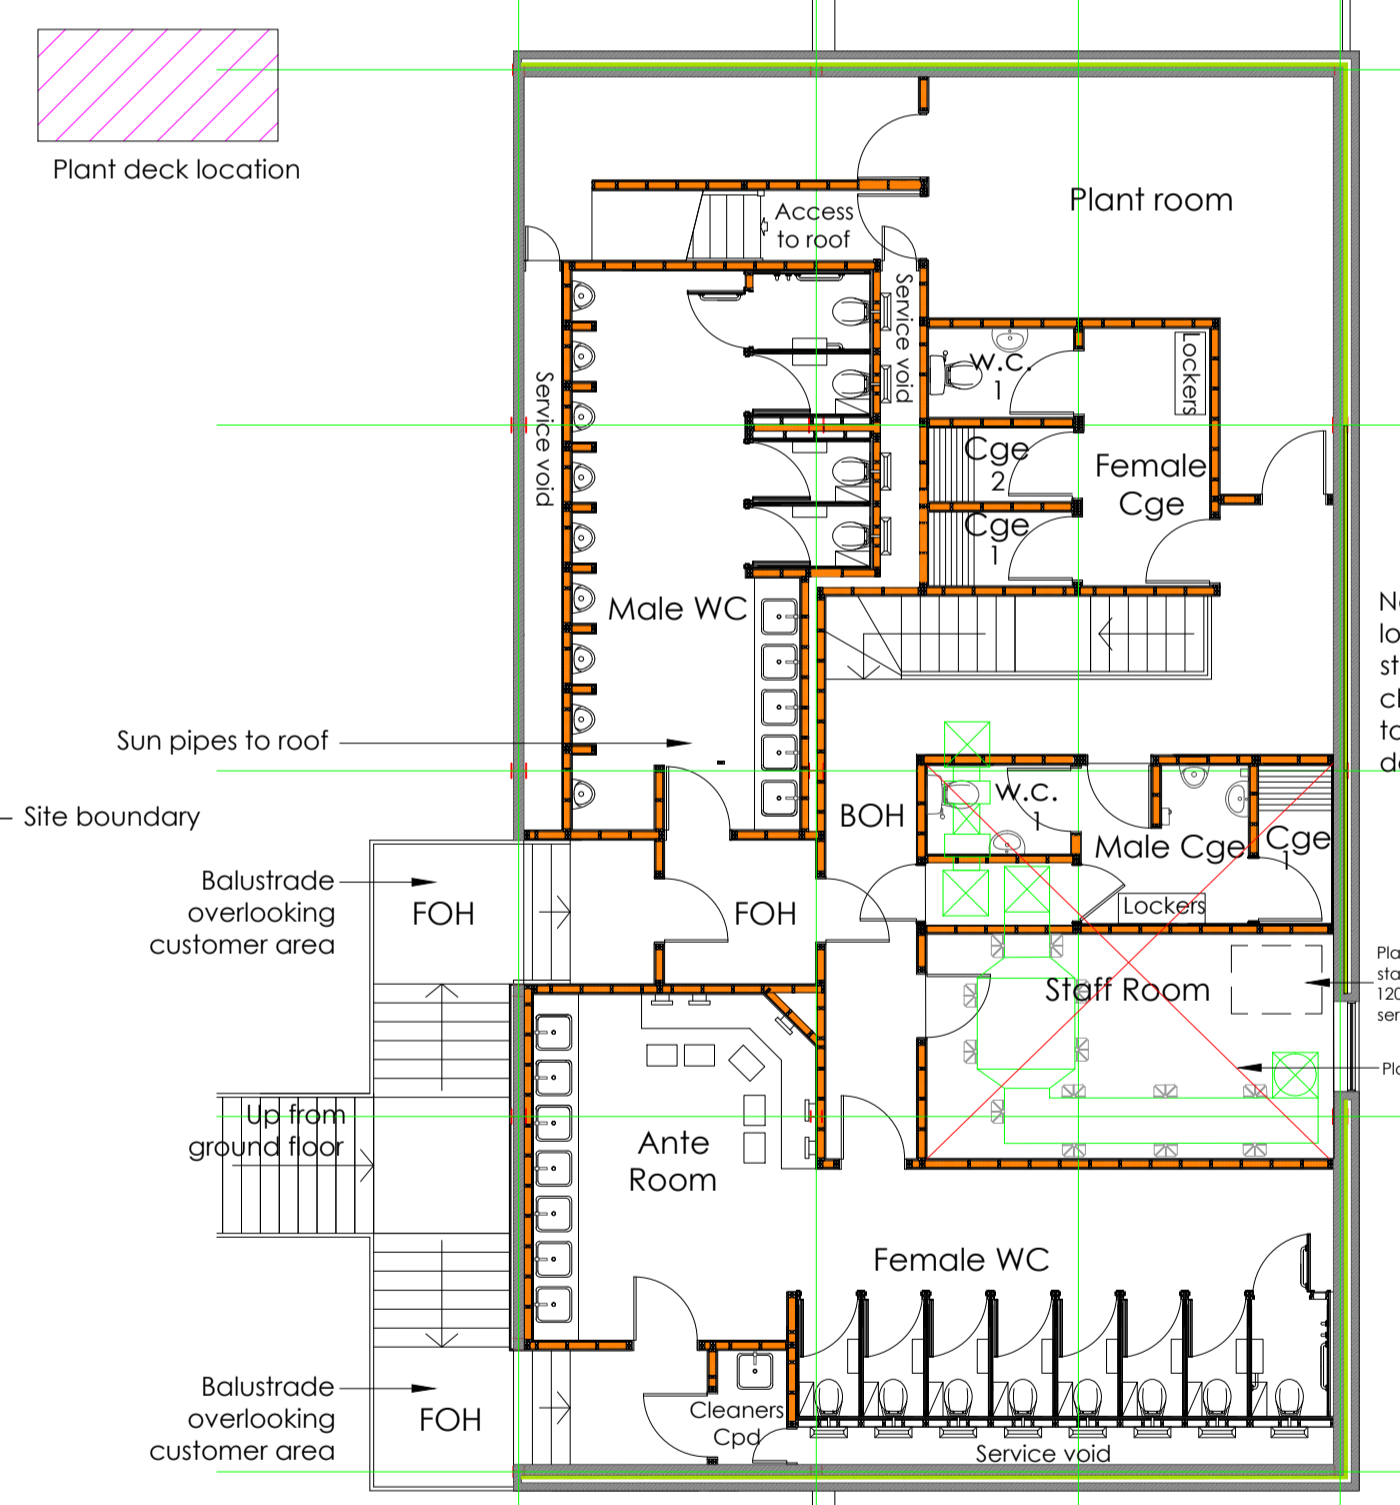

C IMAGE REFERENCE

Anti-crash car park bollards @ 1.5m cts 1.100m high (stainless steel finish)




ABSOLUTE.

Riverside Studios, Newham Road, Truro, Cornwall, TR1 2SU
+44 (0)1872 264775 | weareabsoluteuk.com

GENERAL NOTES:
THE CONTRACTOR SHALL CHECK AND VERIFY ALL DIMENSIONS ON SITE AND REPORT ANY DISCREPANCIES IN WRITING TO ABSOLUTE DESIGN BEFORE COMMENCING WITH THE WORK.
ALL DRAWINGS ARE THE PROPERTY OF ABSOLUTE DESIGN AND SHALL NOT BE REPRODUCED WITHOUT THE CONSENT OF THE DESIGNERS.
THIS DRAWING IS TO BE READ IN CONJUNCTION WITH THE RELEVANT SPECIFICATION OF BUILDING WORKS.
ALL DIMENSIONS ARE IN mm UNLESS OTHERWISE NOTED.
THIS DRAWING MAY INCORPORATE INFORMATION FROM OTHER PROFESSIONS. ABSOLUTE DESIGN CANNOT ACCEPT RESPONSIBILITY FOR THE INTEGRITY AND ACCURACY OF SUCH INFORMATION.

IF IN DOUBT ASK!

original drawn by	date	
A	25-6-14	NJB
B	02-7-14	NJB
C	08-08-14	NJB
D	13-08-14	NJB
E	21-08-14	JP
F	16-09-14	JP
G	17-09-14	NJB
H	24-11-14	NJB
I	01-12-14	NJB
J	06-01-15	JP
K	06-05-15	NJB
L	01-06-15	NAW
M	18-06-15	NAW
N	26-06-15	NAW
O	01-07-15	NAW
P	02-07-15	NAW
Q	10-07-15	NAW
U	13-07-15	NAW
R	16-07-15	NAW
S	29-07-15	NAW
T	27-08-15	NJB
U	05-10-15	NAW
V	11-11-15	NAW

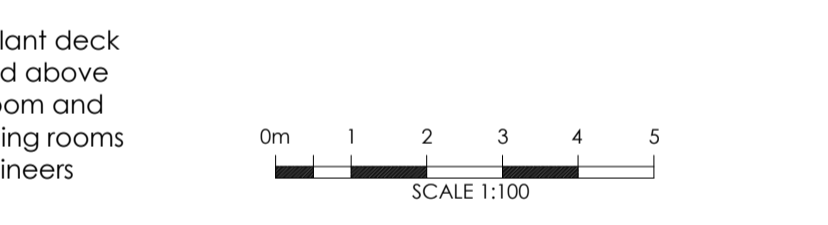

Drawing status: **CONSTRUCTION**

Drawing Title:
Proposed Floor Plans

Contract Name:
New Build
Hatfield
AL10 OXY

Drawing No. & Revision:
7127 - 200-V

Scale @ A1:
1: 100
Drawn By: NJB
Date: 11-06-14
Pub: 5480