


For Construction Notes,  
see drawing no 244.300

Mains wired combined smoke detectors/fire alarm sounders are to be installed in the positions marked. These are to be interlinked and wired directly back to the main electrical distribution board.

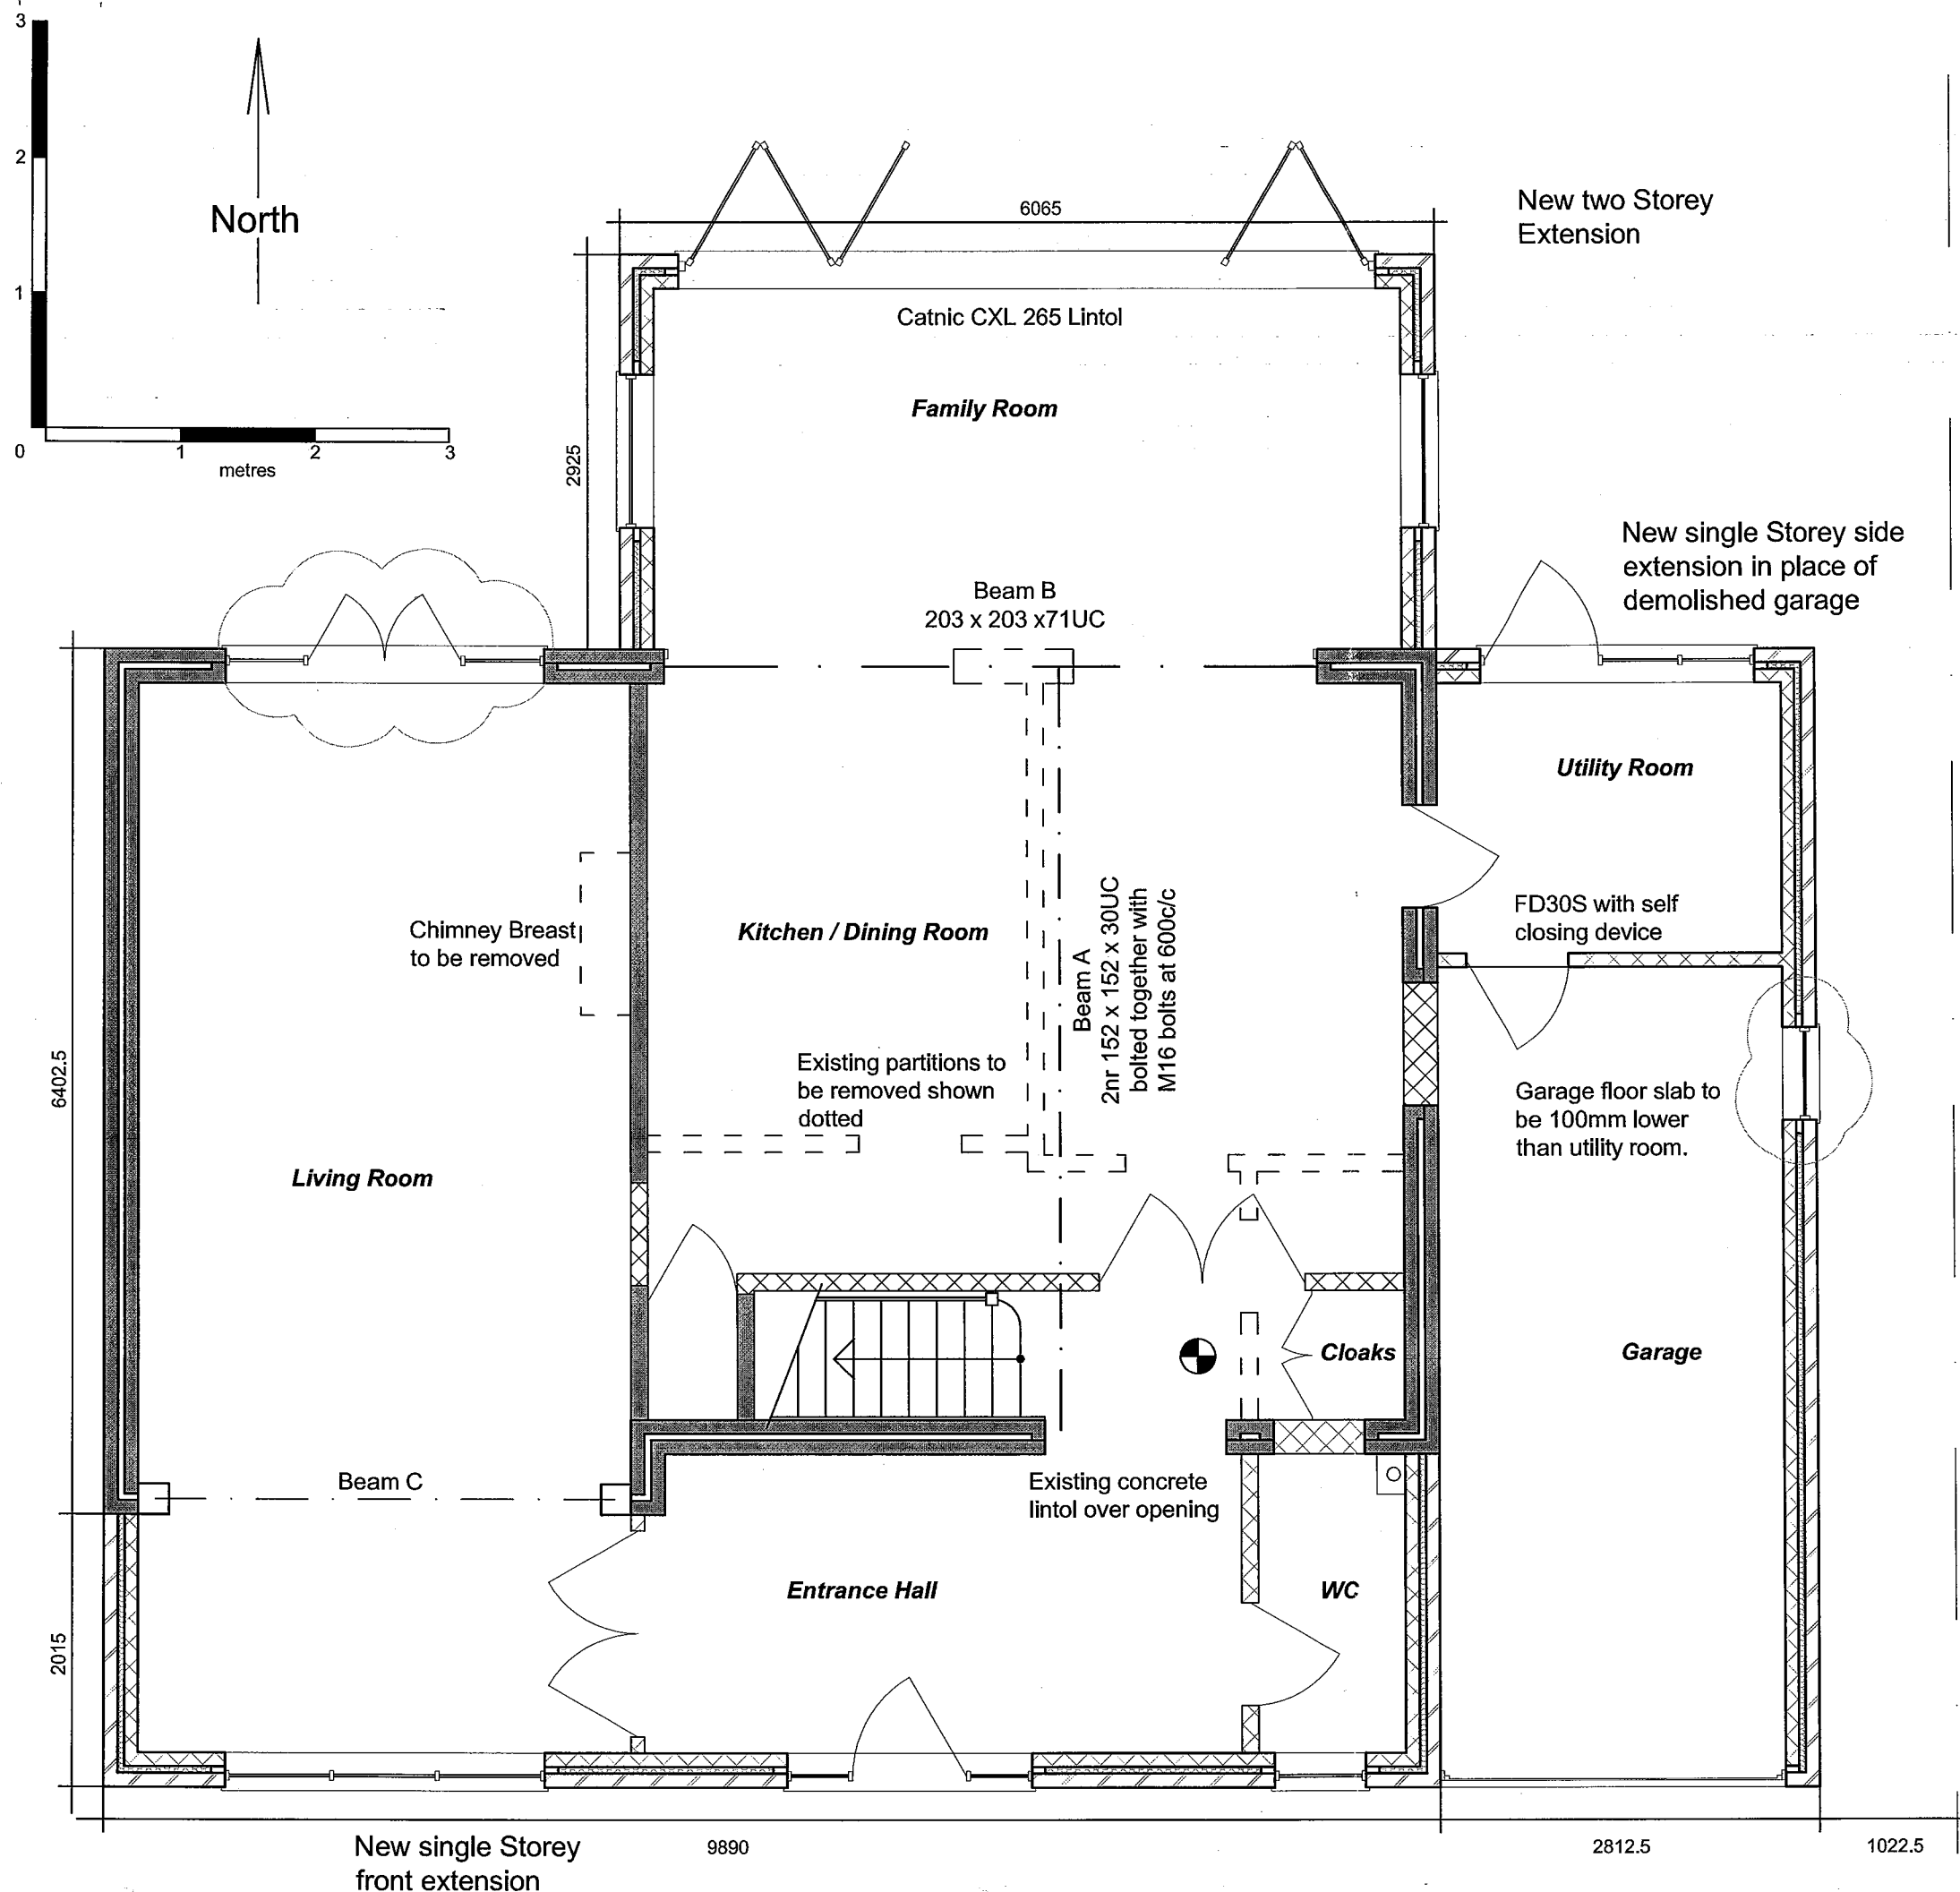

SITE BOUNDARY

- REVISIONS
- A NOV13 Scheme revised
  - B JAN 14 Minor amendment to layout and Beam A added
  - C JAN 14 Details of Beams added.
  - D FEB14 Revised for Building Regulation Approval
  - E FEB14 Beam C added over Living Room
  - F JUL14 Garage Window added. Rear window to Living Room amended

Do not scale. This drawing must not be reproduced in whole or part without consent. Work only to figured dimensions which are to be checked on site. Advise of any discrepancies.

Project:

12 Ramsey Close  
Brookmans Park

Drawing:

Ground Floor Plan  
Proposed



Gordon Marshall Building Surveying  
46 Cotton Road  
Potters Bar, Hertfordshire EN6 5JG  
t: 01707 658068  
m: 07825 586000  
e: gmbs46@btinternet.com

Scale: 1:50 @ A3  
Date: OCT 13  
Job No: 244  
Drg No: 201F