




PLANNING
DEPARTMENT
OFFICE COPY
15 OCT 2007
NO: S612007/1519 AD

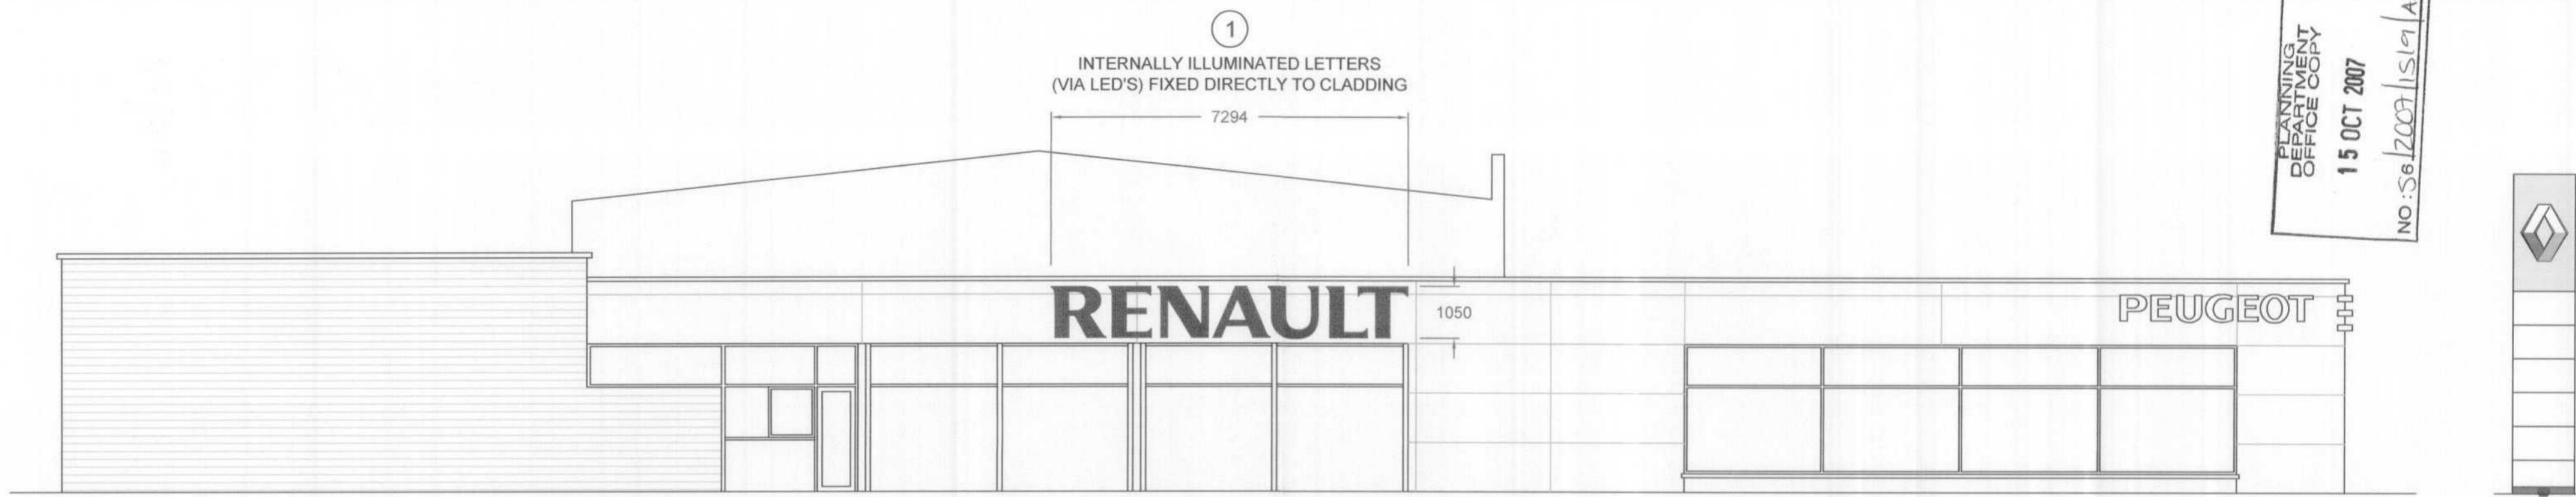


SOUTH WEST ELEVATION

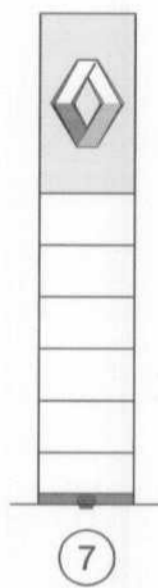

SOUTH EAST ELEVATION

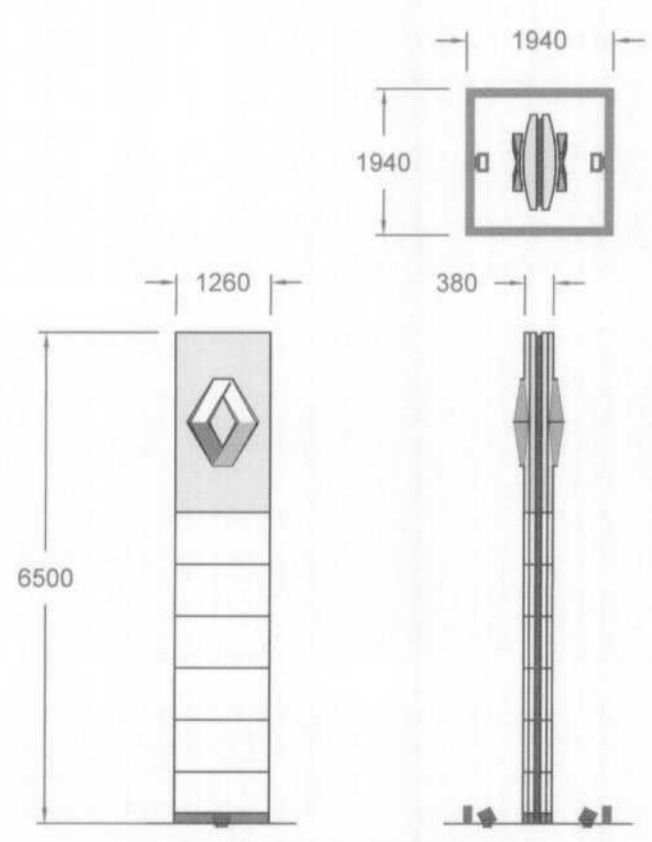

NEW 6.5M ILLUMINATED PYLON HALO ILLUMINATION AROUND LOGO. PANELS TO BE LIT BY GROUND MOUNTED 150 WATT HALIDE SPOT LIGHTS ENCLOSED IN KERB SURROUND

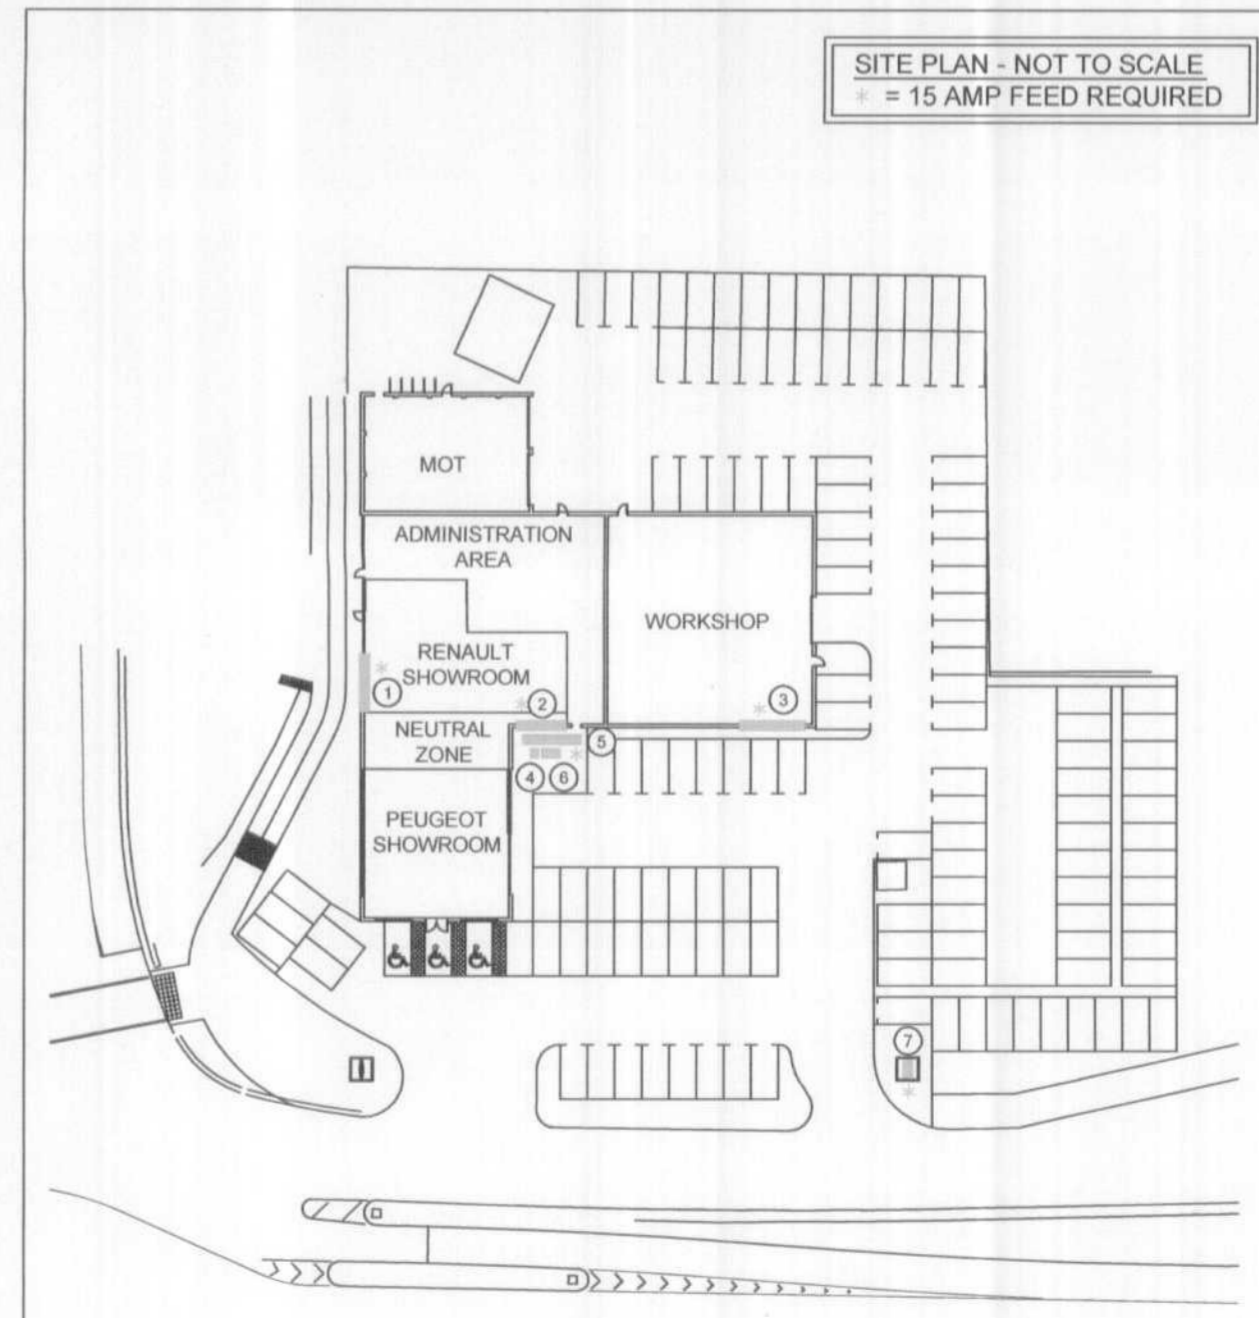

Tara Signs
St. Peters Place, Western Road,
Lancing, Sussex, BN15 8SB
Tel : 01903 750710
Fax : 01903 754008
Copyright Tara Signs Ltd.

Scale 1:100
Tolerance +-
Drg No Ren0748 planning
Date 9.10.07
Drawn By AHW
Checked By

Revisions	Date

	RENAULT	DEALER
Date		
Signature		
Signed By		

Project:
WATERS
COMET WAY
HATFIELD
AL10 9TF