


7m MONOLITH PYLON SIGN

Logo panel text to be confirmed but will reference site facilities i.e. ATM, 24Hrs, LPG, Sandwiches etc

Shell Monolith Pylon sign comprising of a steel frame structure with ACM profile panels (Colour Shell White) with laser cut lettering & symbols fitted with vacuum moulded opal acrylic.

The Pecten emblem is a one piece moulding. Outer case White ACM with vacuum moulded opal acrylic emblem facing decorated with Yellow / Red vinyl. Outer edge are raised to cast White light halo.

Surface illumination varies between 13cd/m² to 186cd/m² (Internally illuminated) refer to light data sheet

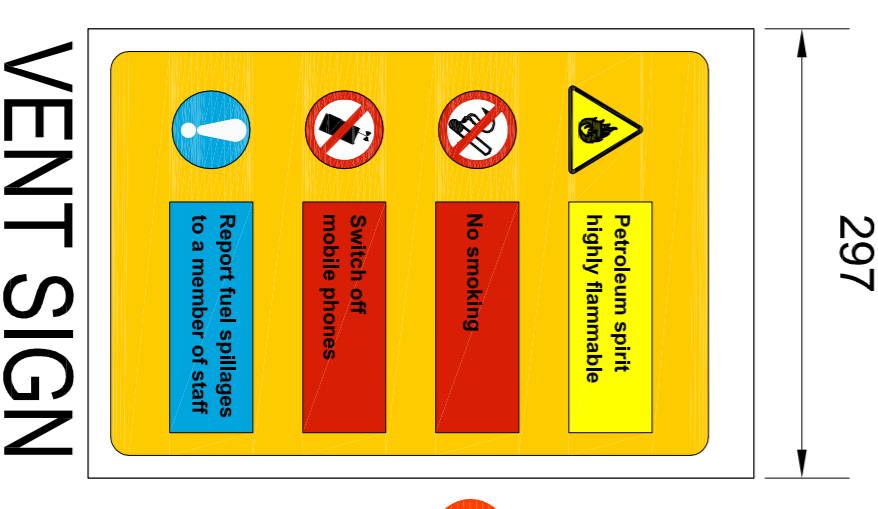


VENT SIGN

Health and Safety warning signage vinyl applied onto FOAMEX weather resistant board fitted to vent pipes. Non illuminated

Fascia Level 1 - Shell White ACM backing panels fixed to canopy fascia. With Yellow ACM curved profile fitted over the White fascia. LED Red bar strip provides both red illumination to the bar and face illumination to the Yellow field. Yellow surface of fascia to have illumination value of 80cd/m². Red surface of fascia to have illumination value of 60cd/m²

Shell canopy Pecten emblem is a one piece moulding. Outer case White ACM with vacuum moulded opal acrylic emblem facing decorated with Yellow / Red vinyl. Outer edge is raised to cast White light halo. Surface of Shell pecten to have illumination value varies between 14 cd/m² to 241cd/m² (Internally illuminated) refer to light data sheet

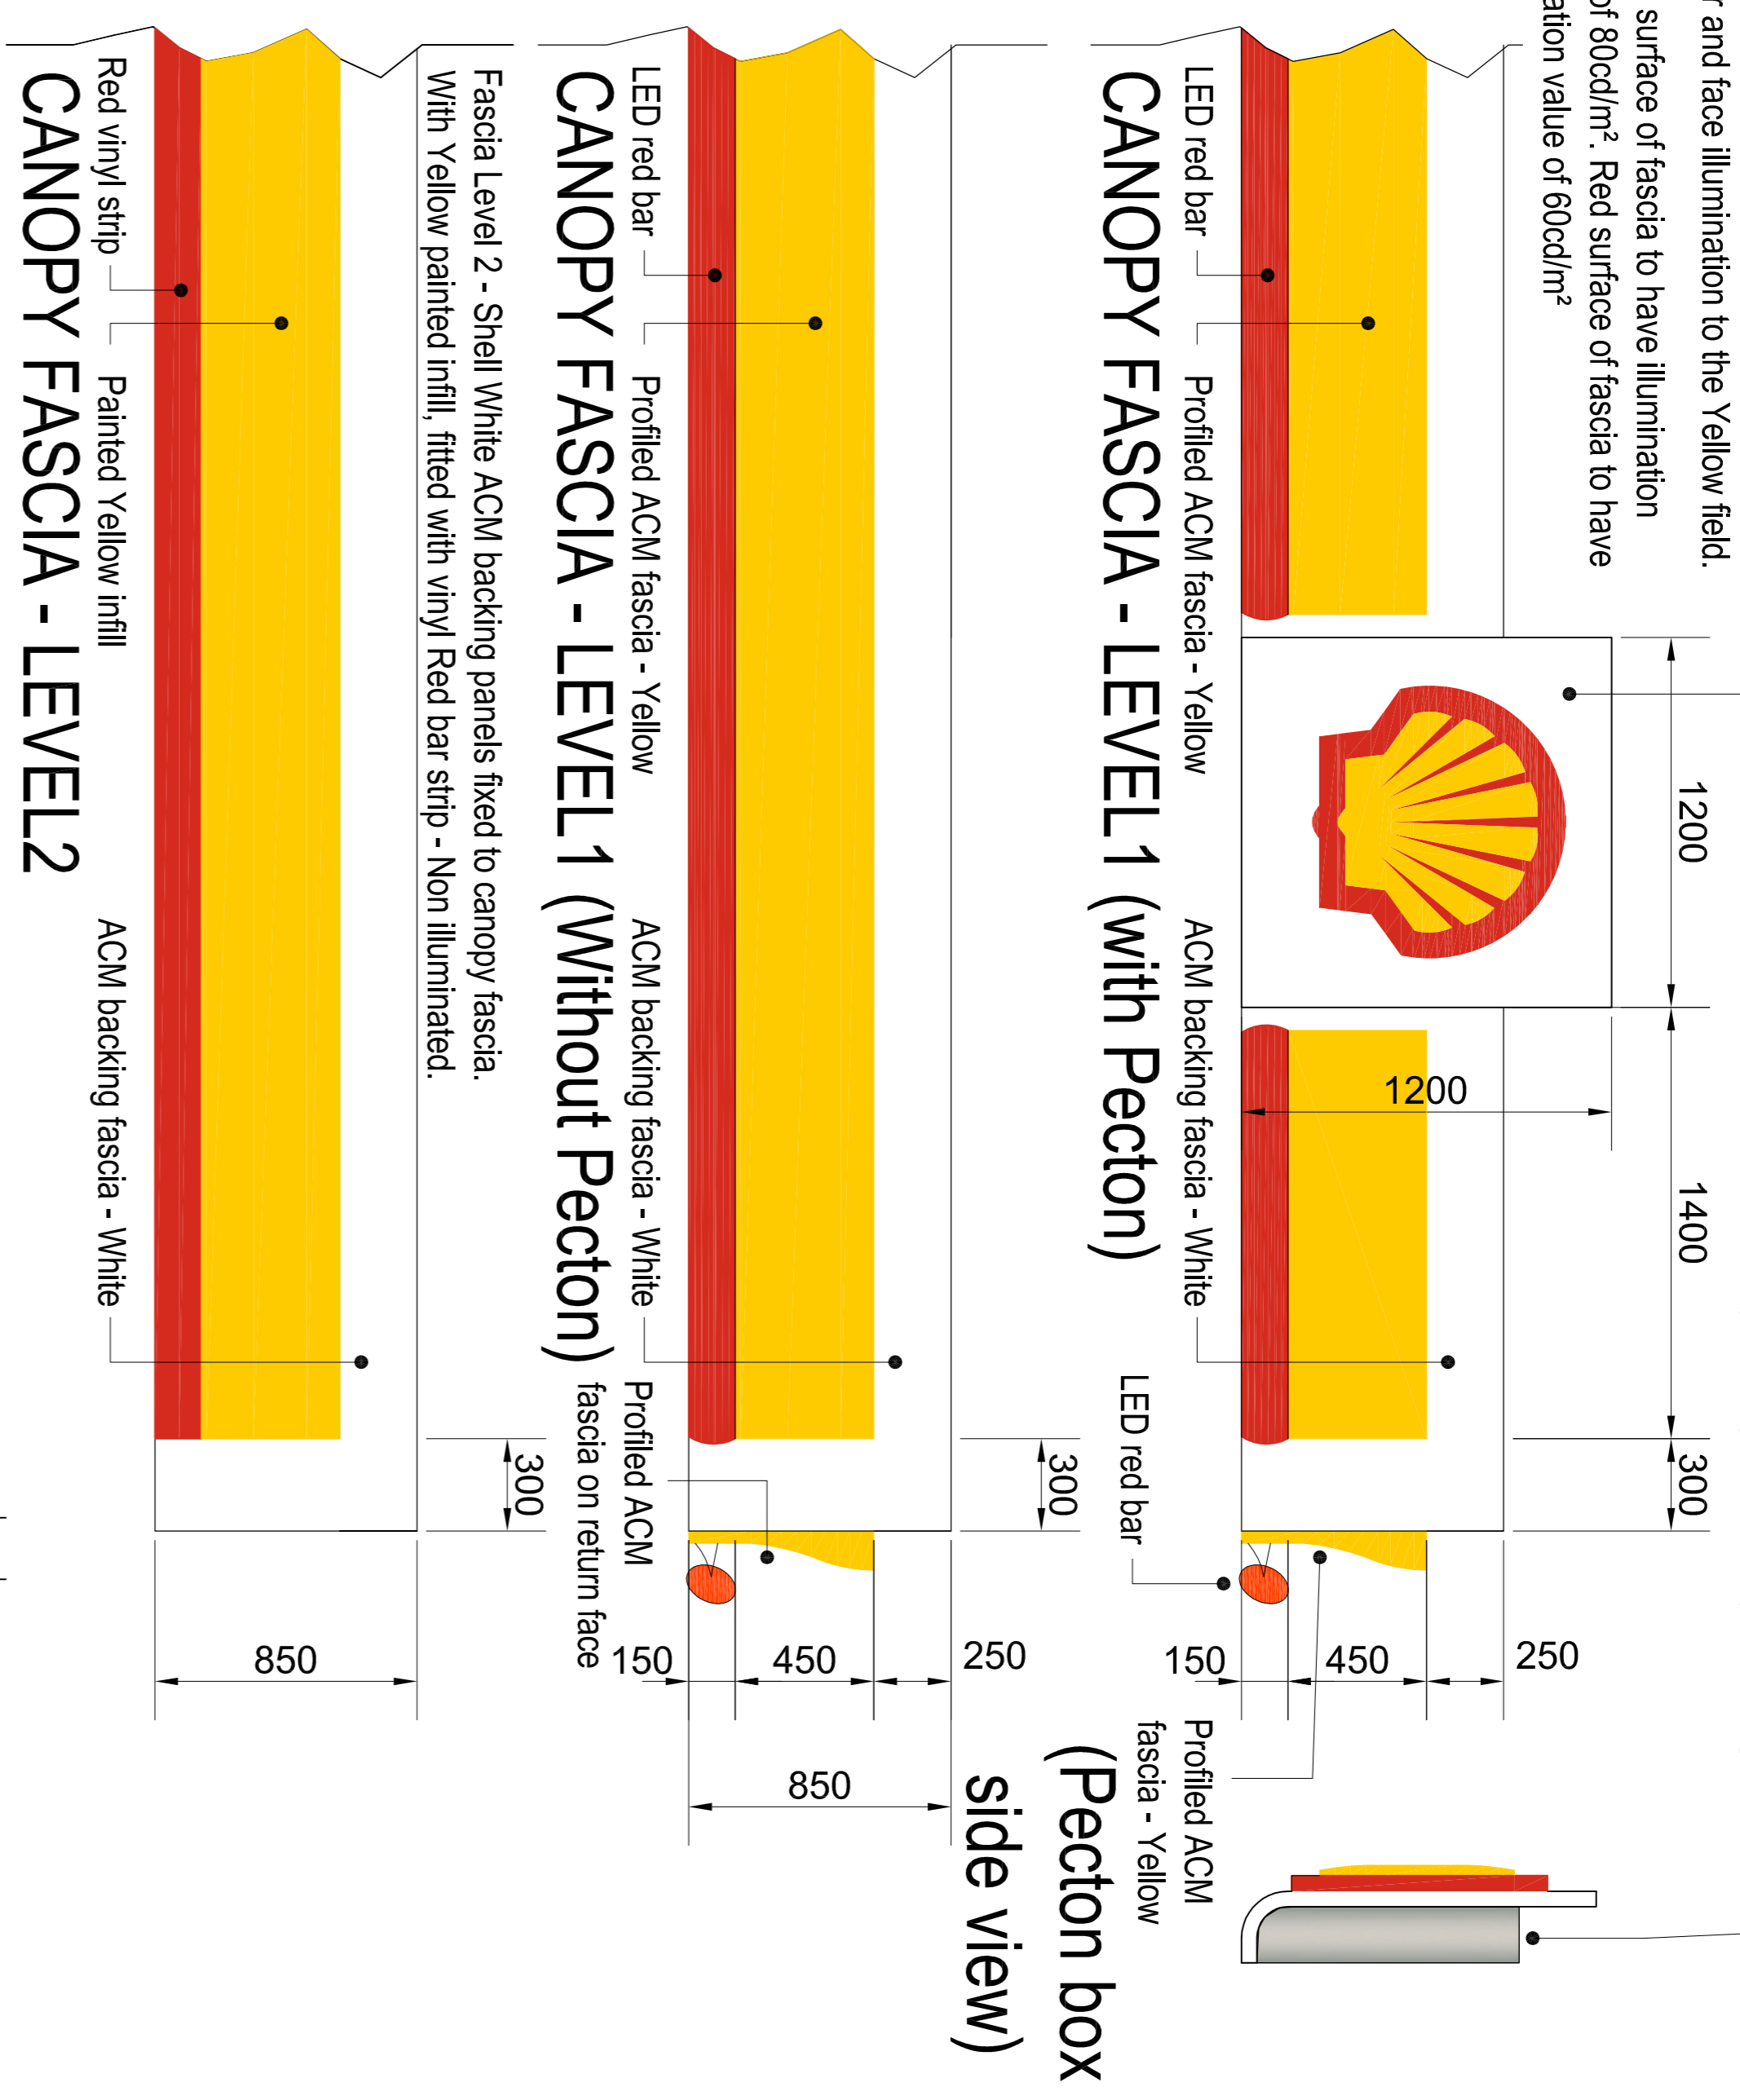


SIDE ELEVATION

Spreader panel positioned 2700mm from ground level
Typical pump dispenser shown for reference not necessarily representative of actual model on site

FRONT ELEVATION

Spreader sign positioned 2700mm from ground level

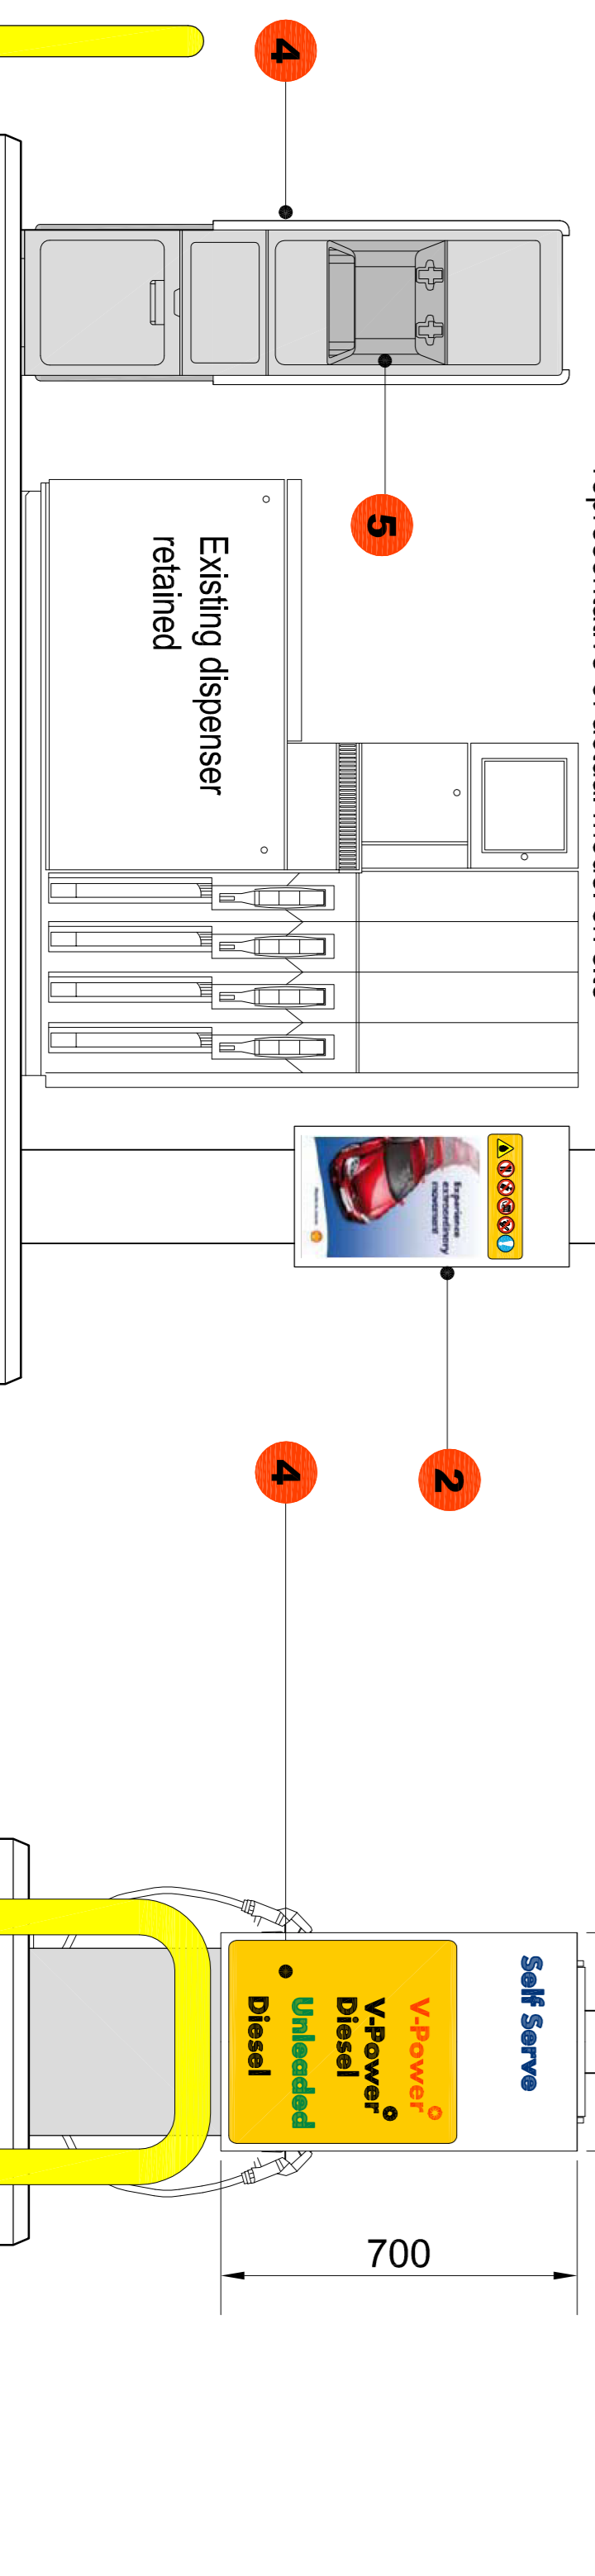

REFUELLING SIGNAGE

All Refuelling signs are formed from powder coated ACM colour Shell White (sizes as shown) with vinyl applied text, logos and symbols. All items are Non illuminated

SITE SIGNAGE KEY

- A** ELEVATION A: LEVEL 1 CANOPY FASCIA WITH INTERNALLY ILLUMINATED PECTEN & RED LED BAR (ILLUMINATED)
- B** ELEVATION B: LEVEL 1 CANOPY FASCIA WITH INTERNALLY ILLUMINATED RED LED BAR (ILLUMINATED)
- C** ELEVATION C: LEVEL 2 CANOPY FASCIA (NON-ILLUMINATED)
- D** ELEVATION D: LEVEL 2 CANOPY FASCIA (NON-ILLUMINATED)
- E** ELEVATION E: LEVEL 2 CANOPY FASCIA (NON-ILLUMINATED)
- F** ELEVATION F: LEVEL 2 CANOPY FASCIA (NON-ILLUMINATED)

REFUELLING AREA

- 1** SPREADER PANEL - 4 No (NON - ILLUMINATED)
- 2** STANCHION POSTER UNITS - 8 No (NON - ILLUMINATED)
- 3** STANCHION PUMP NUMBERS - 8 No (NON - ILLUMINATED)
- 4** CUSTOMER SERVICE UNIT (CSU) WITH BIN, TOWEL HOLDER & GLOVE DISPENSER - 4 No (NON - ILLUMINATED)
- 5** STANDARD SQUARE BINS - 2 No (NON - ILLUMINATED)
- 6** VENT STACK SIGN - 1 No (NON - ILLUMINATED)

PRIME / PRICE SIGN

7 METRE PYLON SIGN WITH 2 LED PRICE DISPLAYS (EITHER SIDE), SHELL PECTON & DISPLAY PANELS - 1 No (ILLUMINATED ONLY)

SHOP FASCIA

ELEVATION S1: NON-ILLUMINATED YELLOW ACM FASCIA WITH RED VINYL BOTTOM STRIP AND WHITE ACM PANEL WITH RED VINYL LETTERING FORMING SHOP TEXT


ADVERTS DRAWING

RL dm
architects

REV	DATE	BY

PROJECT : SHELL WEIWN GARDEN CITY,
STANBOROUGH ROAD,
HERTFORDSHIRE, AL8 6XA.

TITLE : TYPICAL SIGNAGE DETAILS (SHEET2)

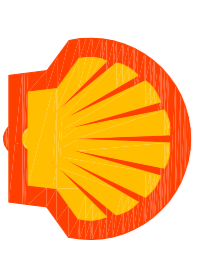

SHELL UK RETAIL
PO BOX 430
STAINES
TW18 3ZB
UNITED KINGDOM

DRAWN BY :	JSL	SCALE :	1:20 & 1:5
DATE :	25.04.12	PLOT DATE :	25.04.12
CAD FILE :	E:\ARCHING\BIRMINGHAM\0017355_ARCHING_GARDEN_CITY_2012		
DWG No :	1355 - 04	PG	2012