


IR

TITLE NUMBER
HD430599

HERTFORDSHIRE : WELWYN HATFIELD


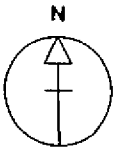


ORDNANCE SURVEY MAP REFERENCE:

TL2009NW

SCALE 1:1250 Enlarged from 1/2500

 ©CROWN COPYRIGHT. Produced by HMLR. Further reproduction in whole or in part is prohibited without the prior written permission of Ordnance Survey. Licence Number GD 272728.

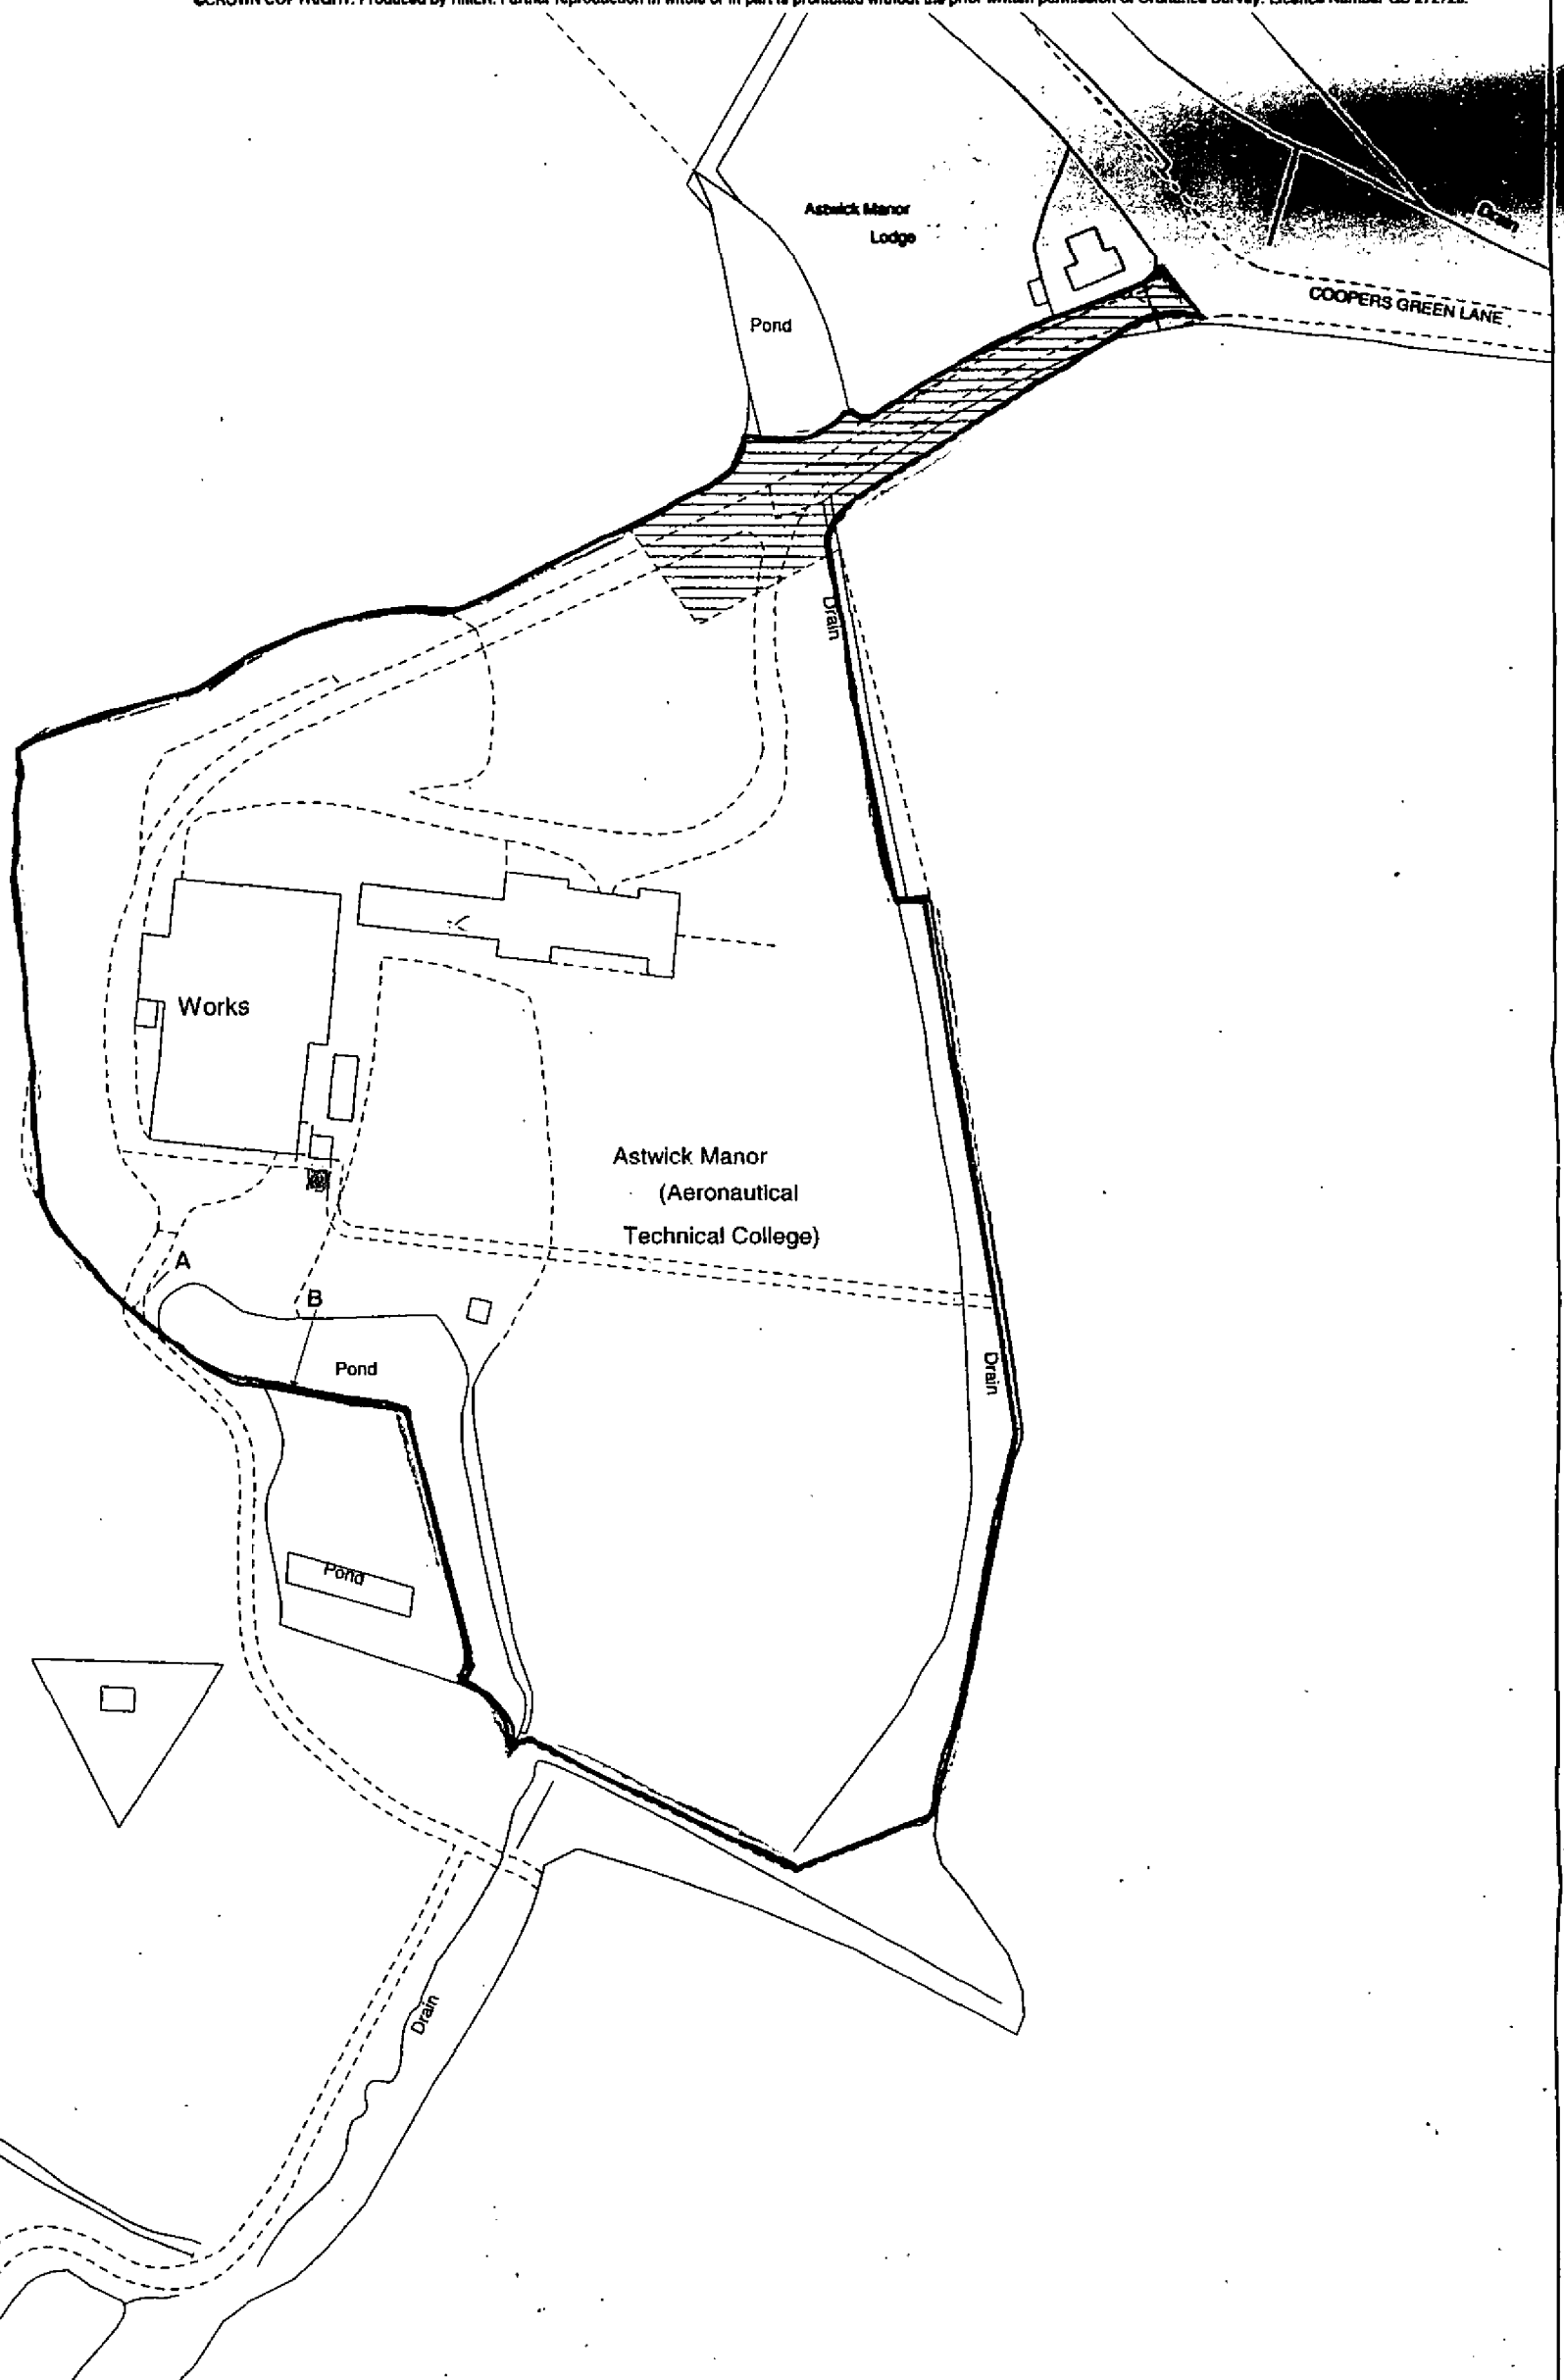


This title plan shows the general position of the boundaries: it does not show the exact line of the boundaries. Measurements scaled from this plan may not match measurements between the same points on the ground. For more information see Land Registry Public Guide 7 - *Scale Plans*.
This official copy shows the state of the title plan on 1 November 2004 at 15:54:11. It may be subject to distortions in scale.
Under s.67 of the Land Registration Act 2002, this copy is admissible in evidence to the same extent as the original.
Issued on 1 November 2004.
This title is dealt with by the Stevenage District Land Registry.

Andrew Laycock
County Secretary




1. All levels relate to the Hatfield aerodrome original survey
2. The coordinate grid is related to the Hatfield aerodrome original survey
3. All relevant levels to be checked on site before commencement of work.

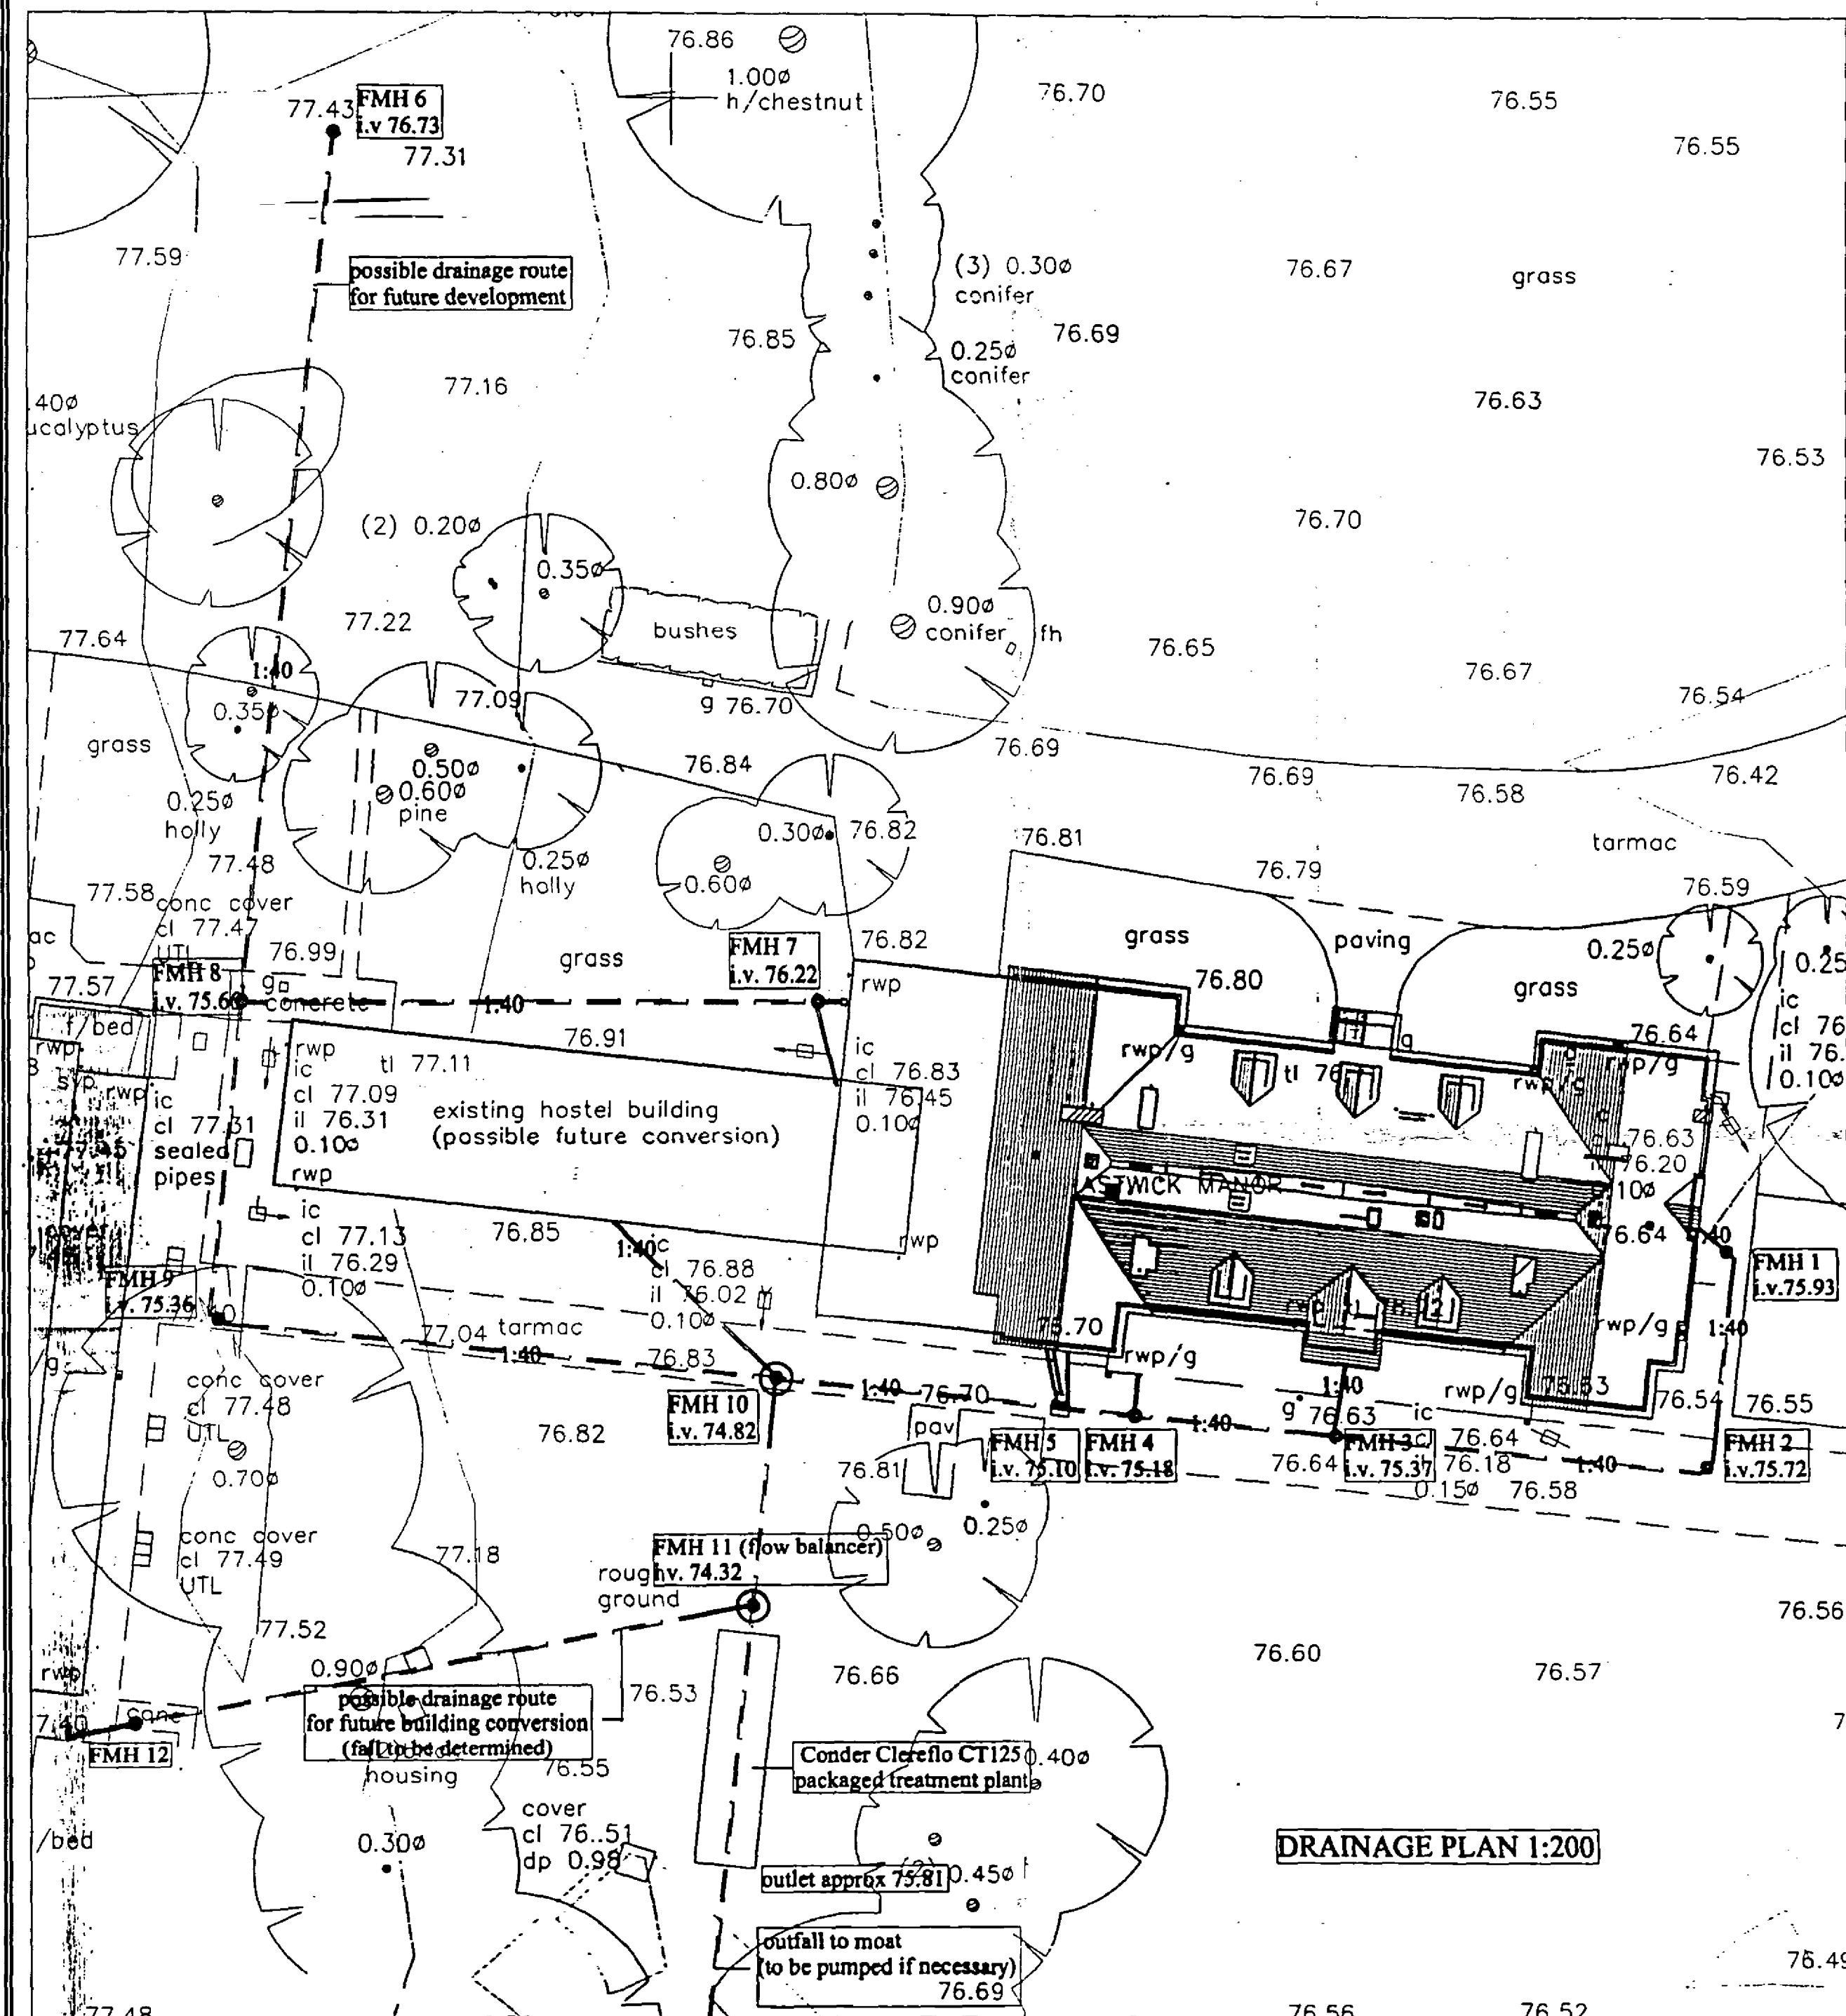

key

FOUL DRAINAGE ———

SURFACE DRAINAGE ———

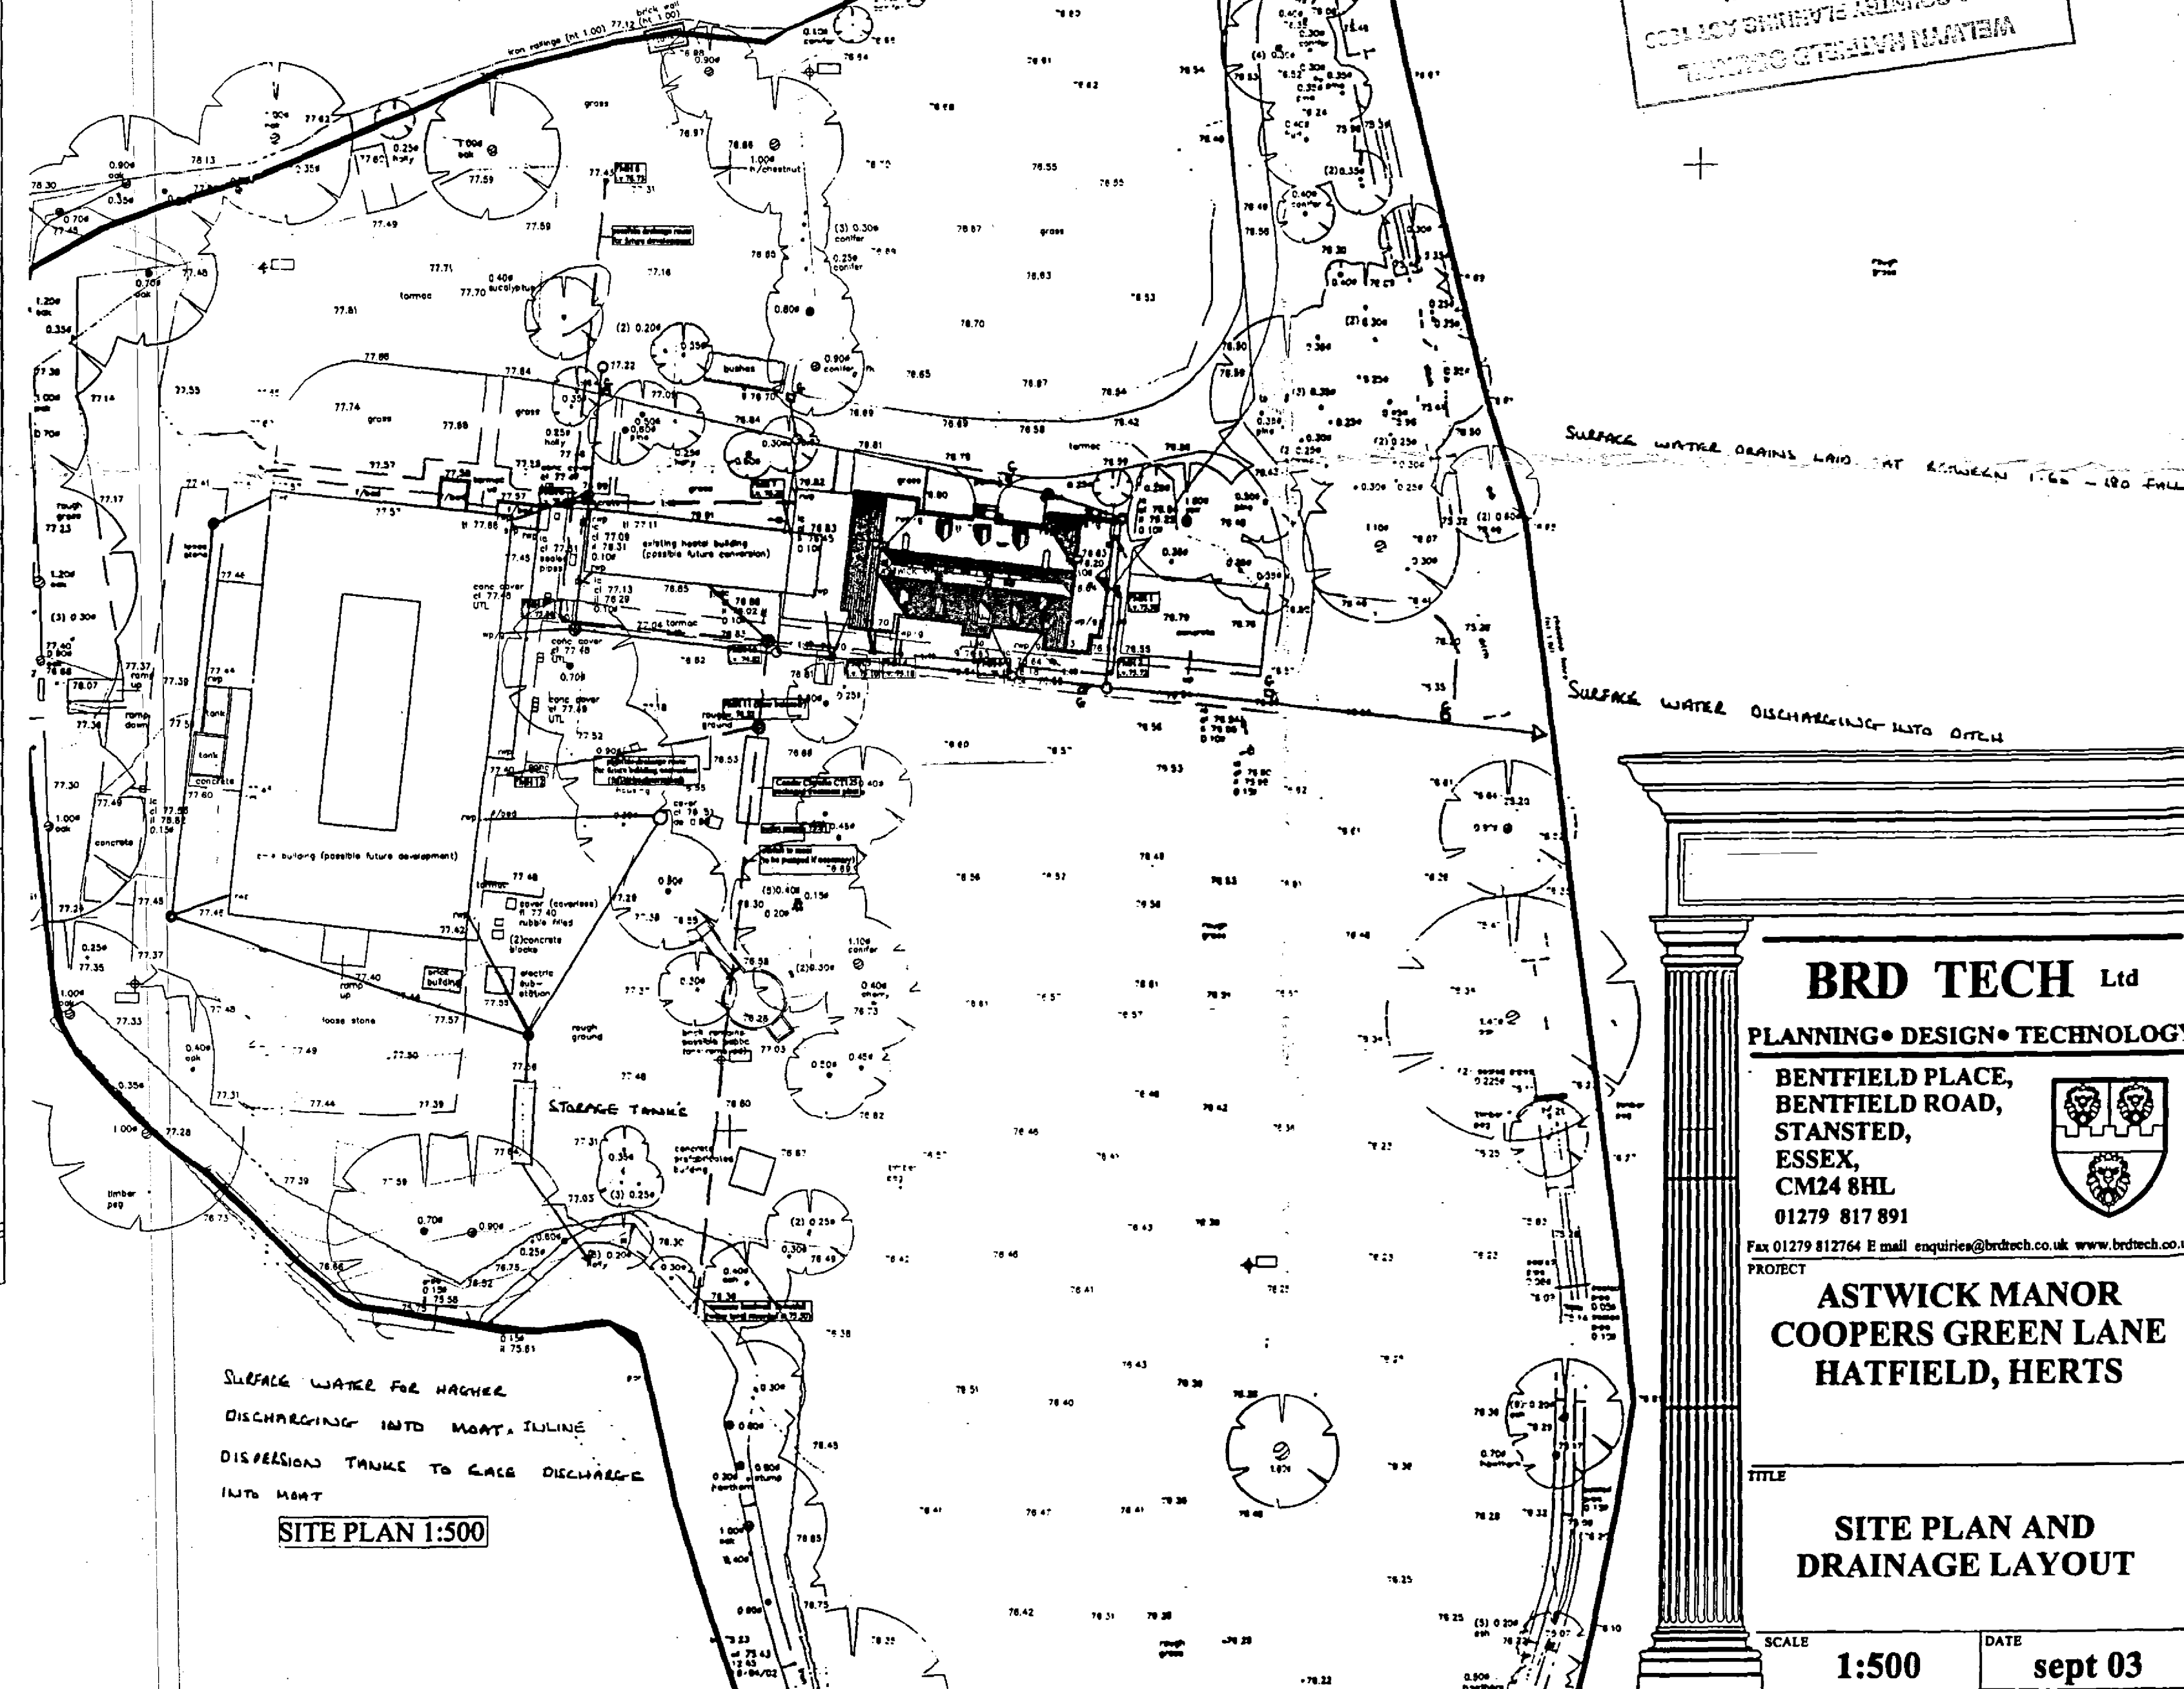

DATE: 1 NOV 2003
CONSENT / INSNOO
PLANNING & DESIGN
TECHNOLOGY

BRD TECH Ltd

PLANNING • DESIGN • TECHNOLOGY

BENTFIELD PLACE,
BENTFIELD ROAD,
ESSEX,
CM24 8HL
01279 817 891
Fax 01279 812764 E mail enquiries@brdtech.co.uk www.brdtech.co.uk

ASTWICK MANOR
COOPERS GREEN LANE
HATFIELD, HERTS


SITE PLAN AND
DRAINAGE LAYOUT

SCALE: 1:500 DATE: sept 03
REF: BRD/P/03/019/10


This drawing and design remains the property of BRD TECH LTD and should not be reproduced or altered in any way without their consent.
NO SCALE FROM THIS DRAWING.
Any information and/or interpretation indicated on this drawing is for the information of the client and is not to be used for any other purpose.

NOTES

1. ALL LEVELS ARE RELATED TO THE HATFIELD AERODROME ORIGINAL SURVEY.
2. THE COORDINATE GRID IS RELATED TO THE HATFIELD AERODROME ORIGINAL SURVEY.
3. THIS SURVEY HAS BEEN CARRIED OUT BY OTHERS THEREFORE THE ACCURACY CANNOT BE GUARANTEED.

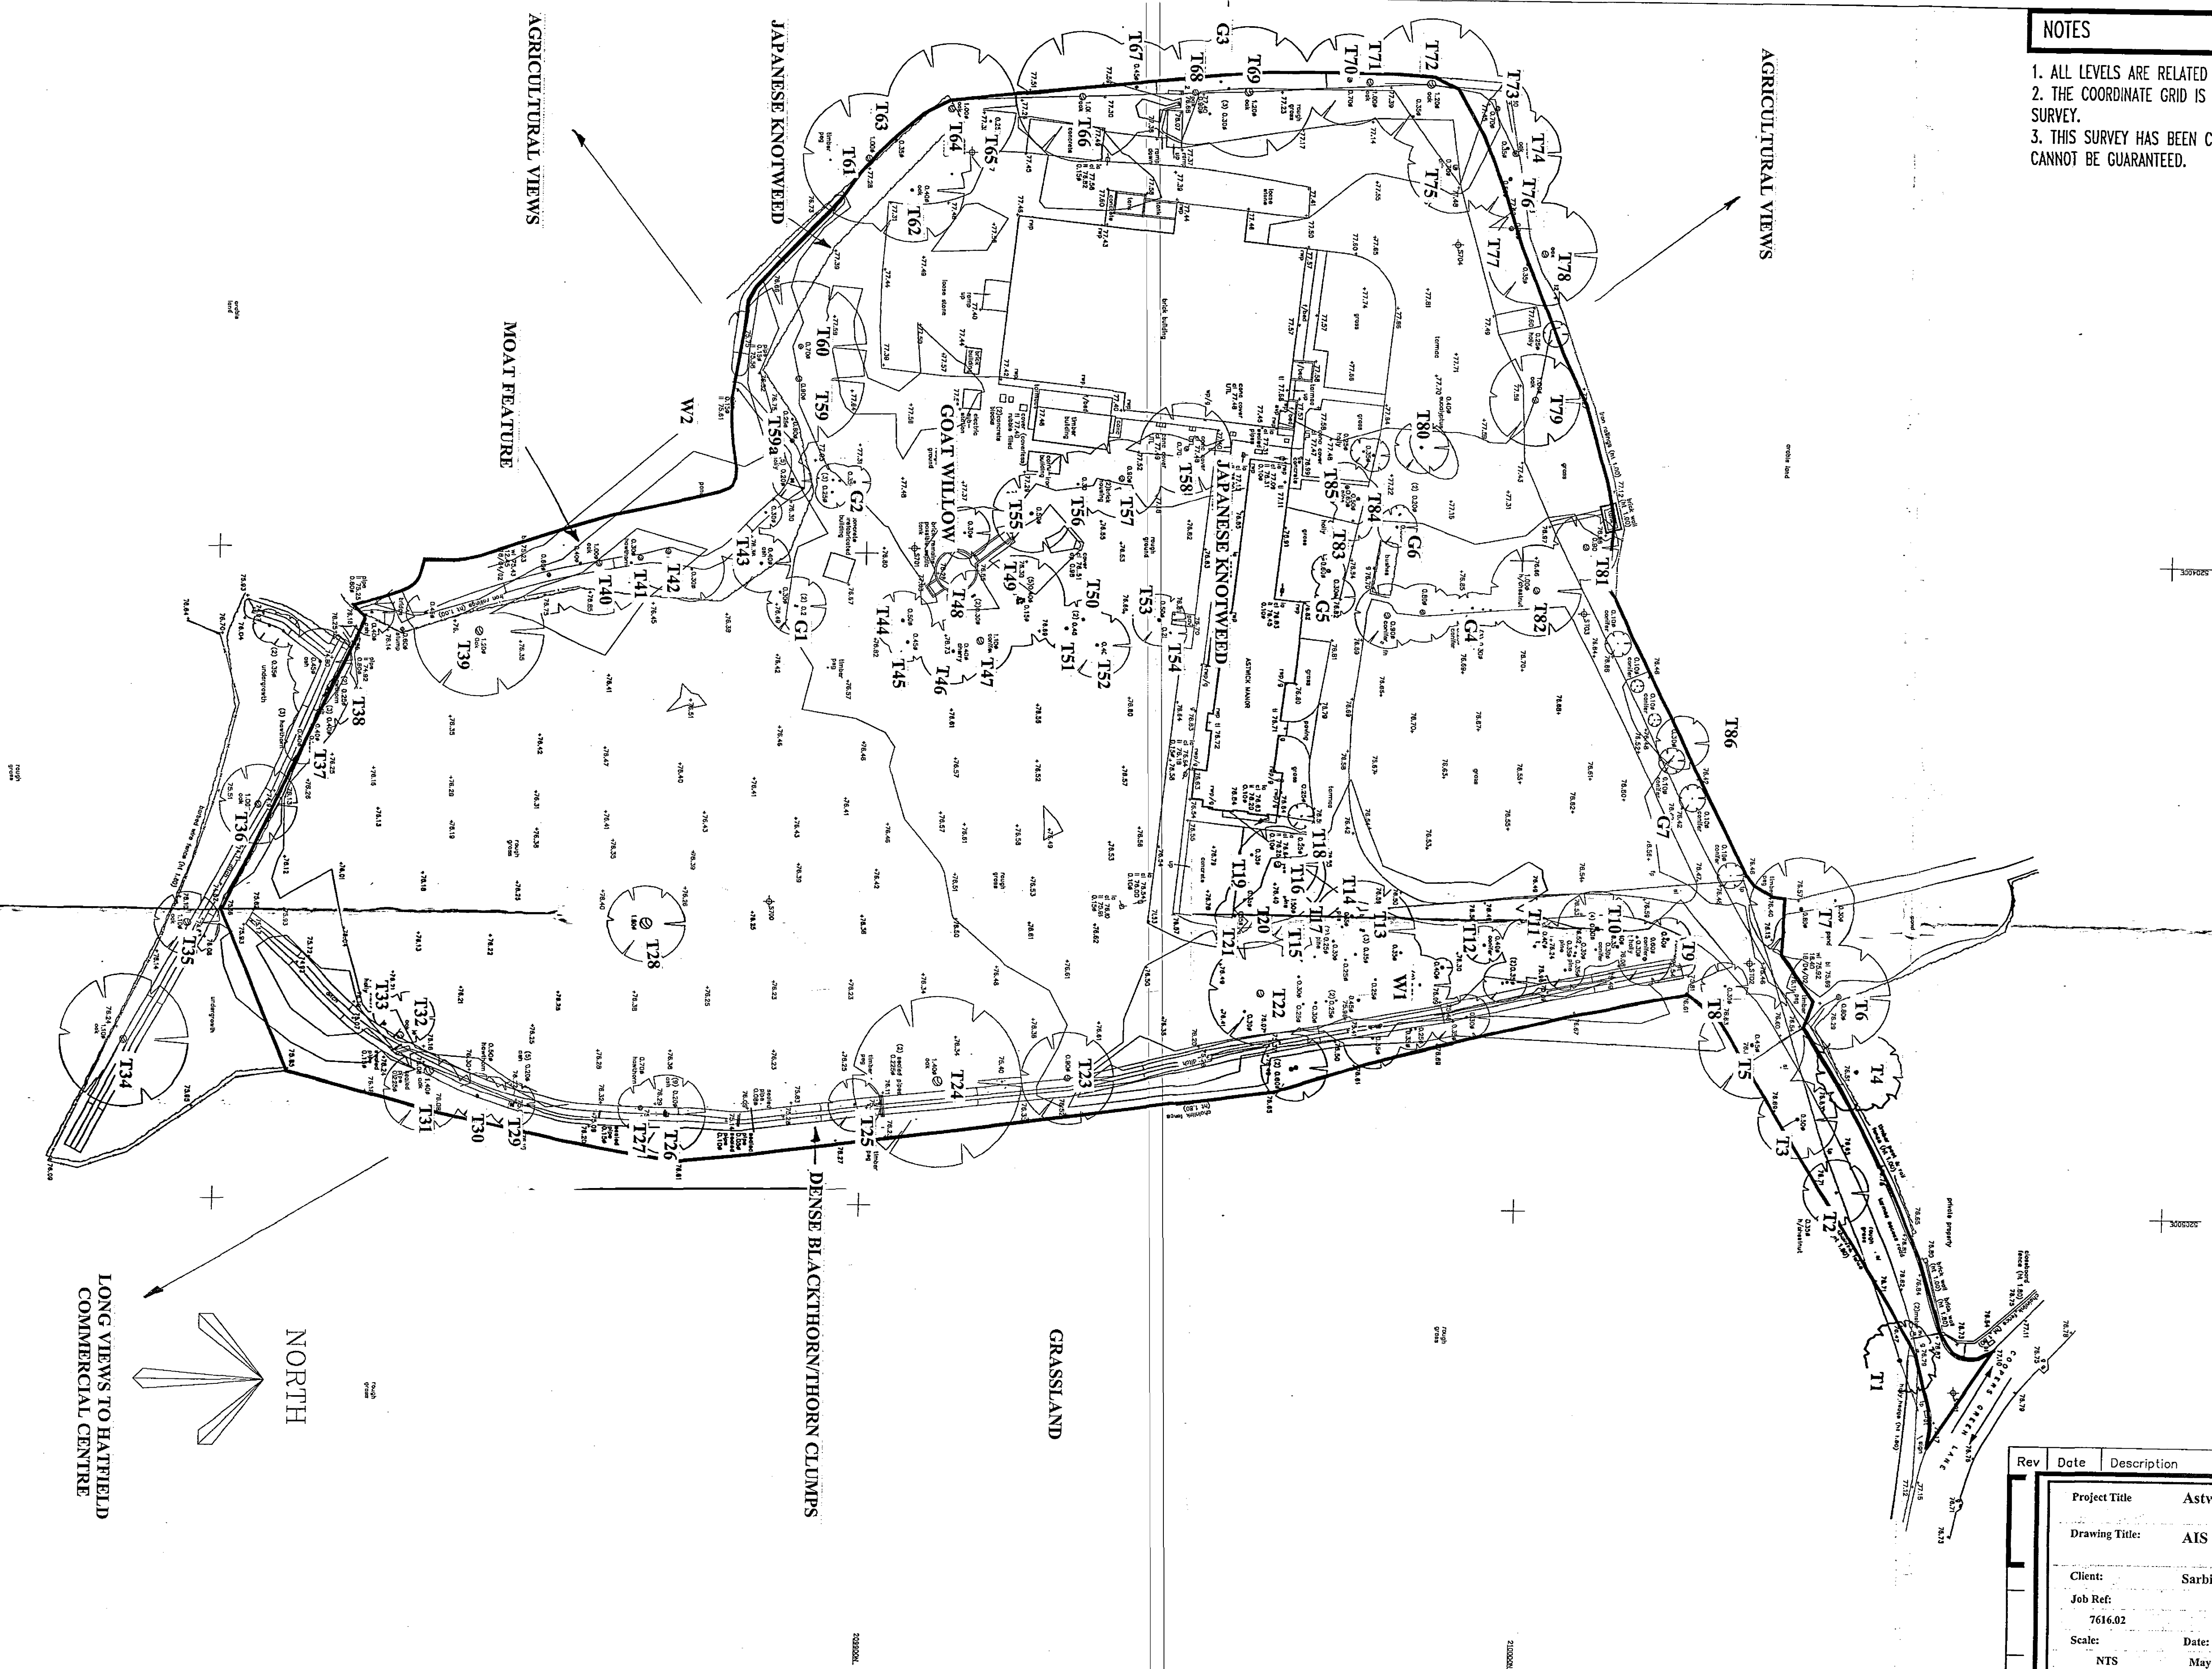

carriageway works
not to be resurfaced based on
Research Road drawing JK/93
and to the satisfaction of the local authority,
using an approved contractor.

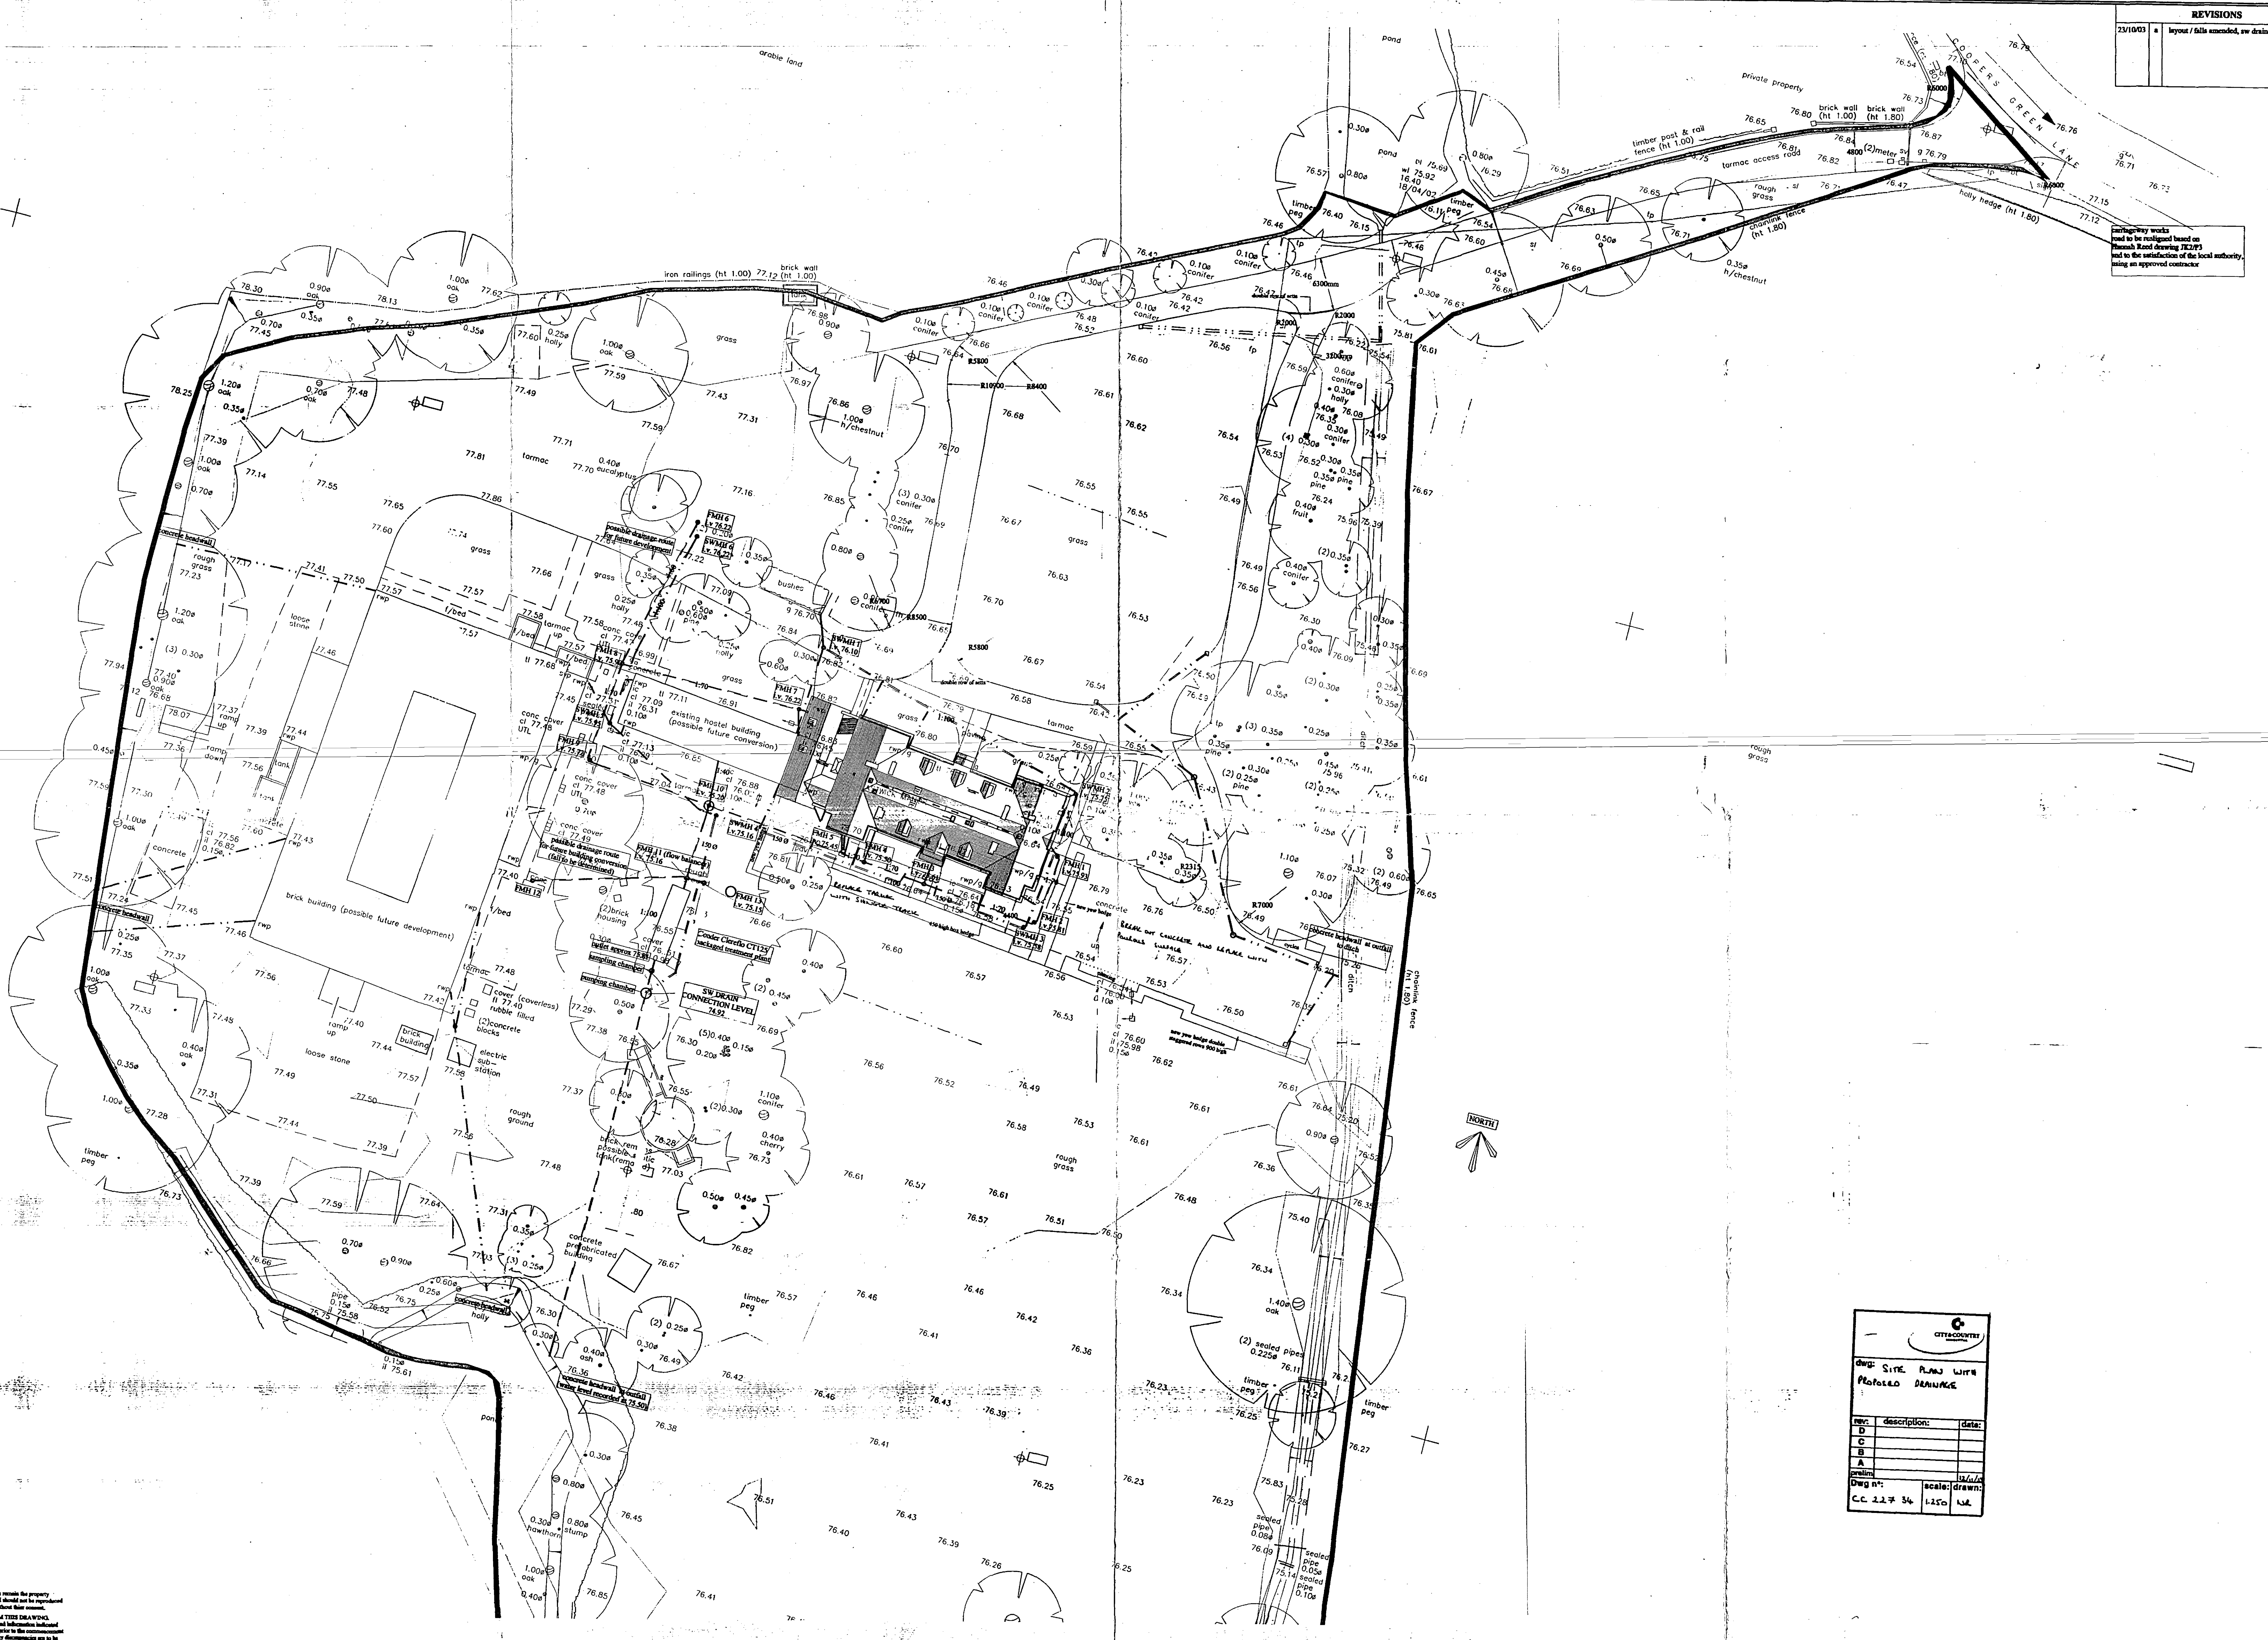

CITYSCAPES		
DWG: SITE PLAN WITH PROPOSED DRAINAGE		
REV:	DESCRIPTION:	DATE:
D		
C		
B		
A		
PRELIM:		
DWG NO:	SCALE:	DRAWN:
C.C. 2.27 34	1:250	WJ

The drawing and design remain the property of BMD TECH LTD and should not be reproduced or shared in any way without their consent.
DO NOT SCALE FROM THIS DRAWING.
All dimensions, levels and information indicated are to be verified on site prior to the commencement of any work on site. Any discrepancies are to be reported to BMD Tech Limited directly.