

COPYRIGHT IN THIS DRAWING IS THE PROPERTY OF N G BAILEY & CO LTD. IT MUST NOT BE REPRODUCED NOR AMENDED NOR USED FOR THE EXECUTION OF ANY WORKS WHETHER IN CONNECTION WITH THE PROPOSED WORKS FOR WHICH IT IS PREPARED OR OTHERWISE WITHOUT THE EXPRESS CONSENT OF N G BAILEY & CO LTD.



TS 14008
nicec

NATIONAL INSPECTION COUNCIL
FOR ELECTRICAL INSTALLATION CONTRACTING

APPROVED CONTRACTOR



ELECTRICAL CONTRACTORS ASSOCIATION

MEMBER



HEATING & VENTILATION CONTRACTORS
ASSOCIATION

MEMBER



THE COUNCIL FOR REGISTERED
GAS INSTALLERS


REGISTERED INSTALLER

NOTES

Lighting 2

LEGEND

- ① PHILIPS SCS 203 LANTERN
150W SON-T 8m COLUMN
- ② PHILIPS SWF TEMPO 3
250W SON-T
- ③ PHILIPS NIGHT GUARD KUMBI PAK
70W SON-T

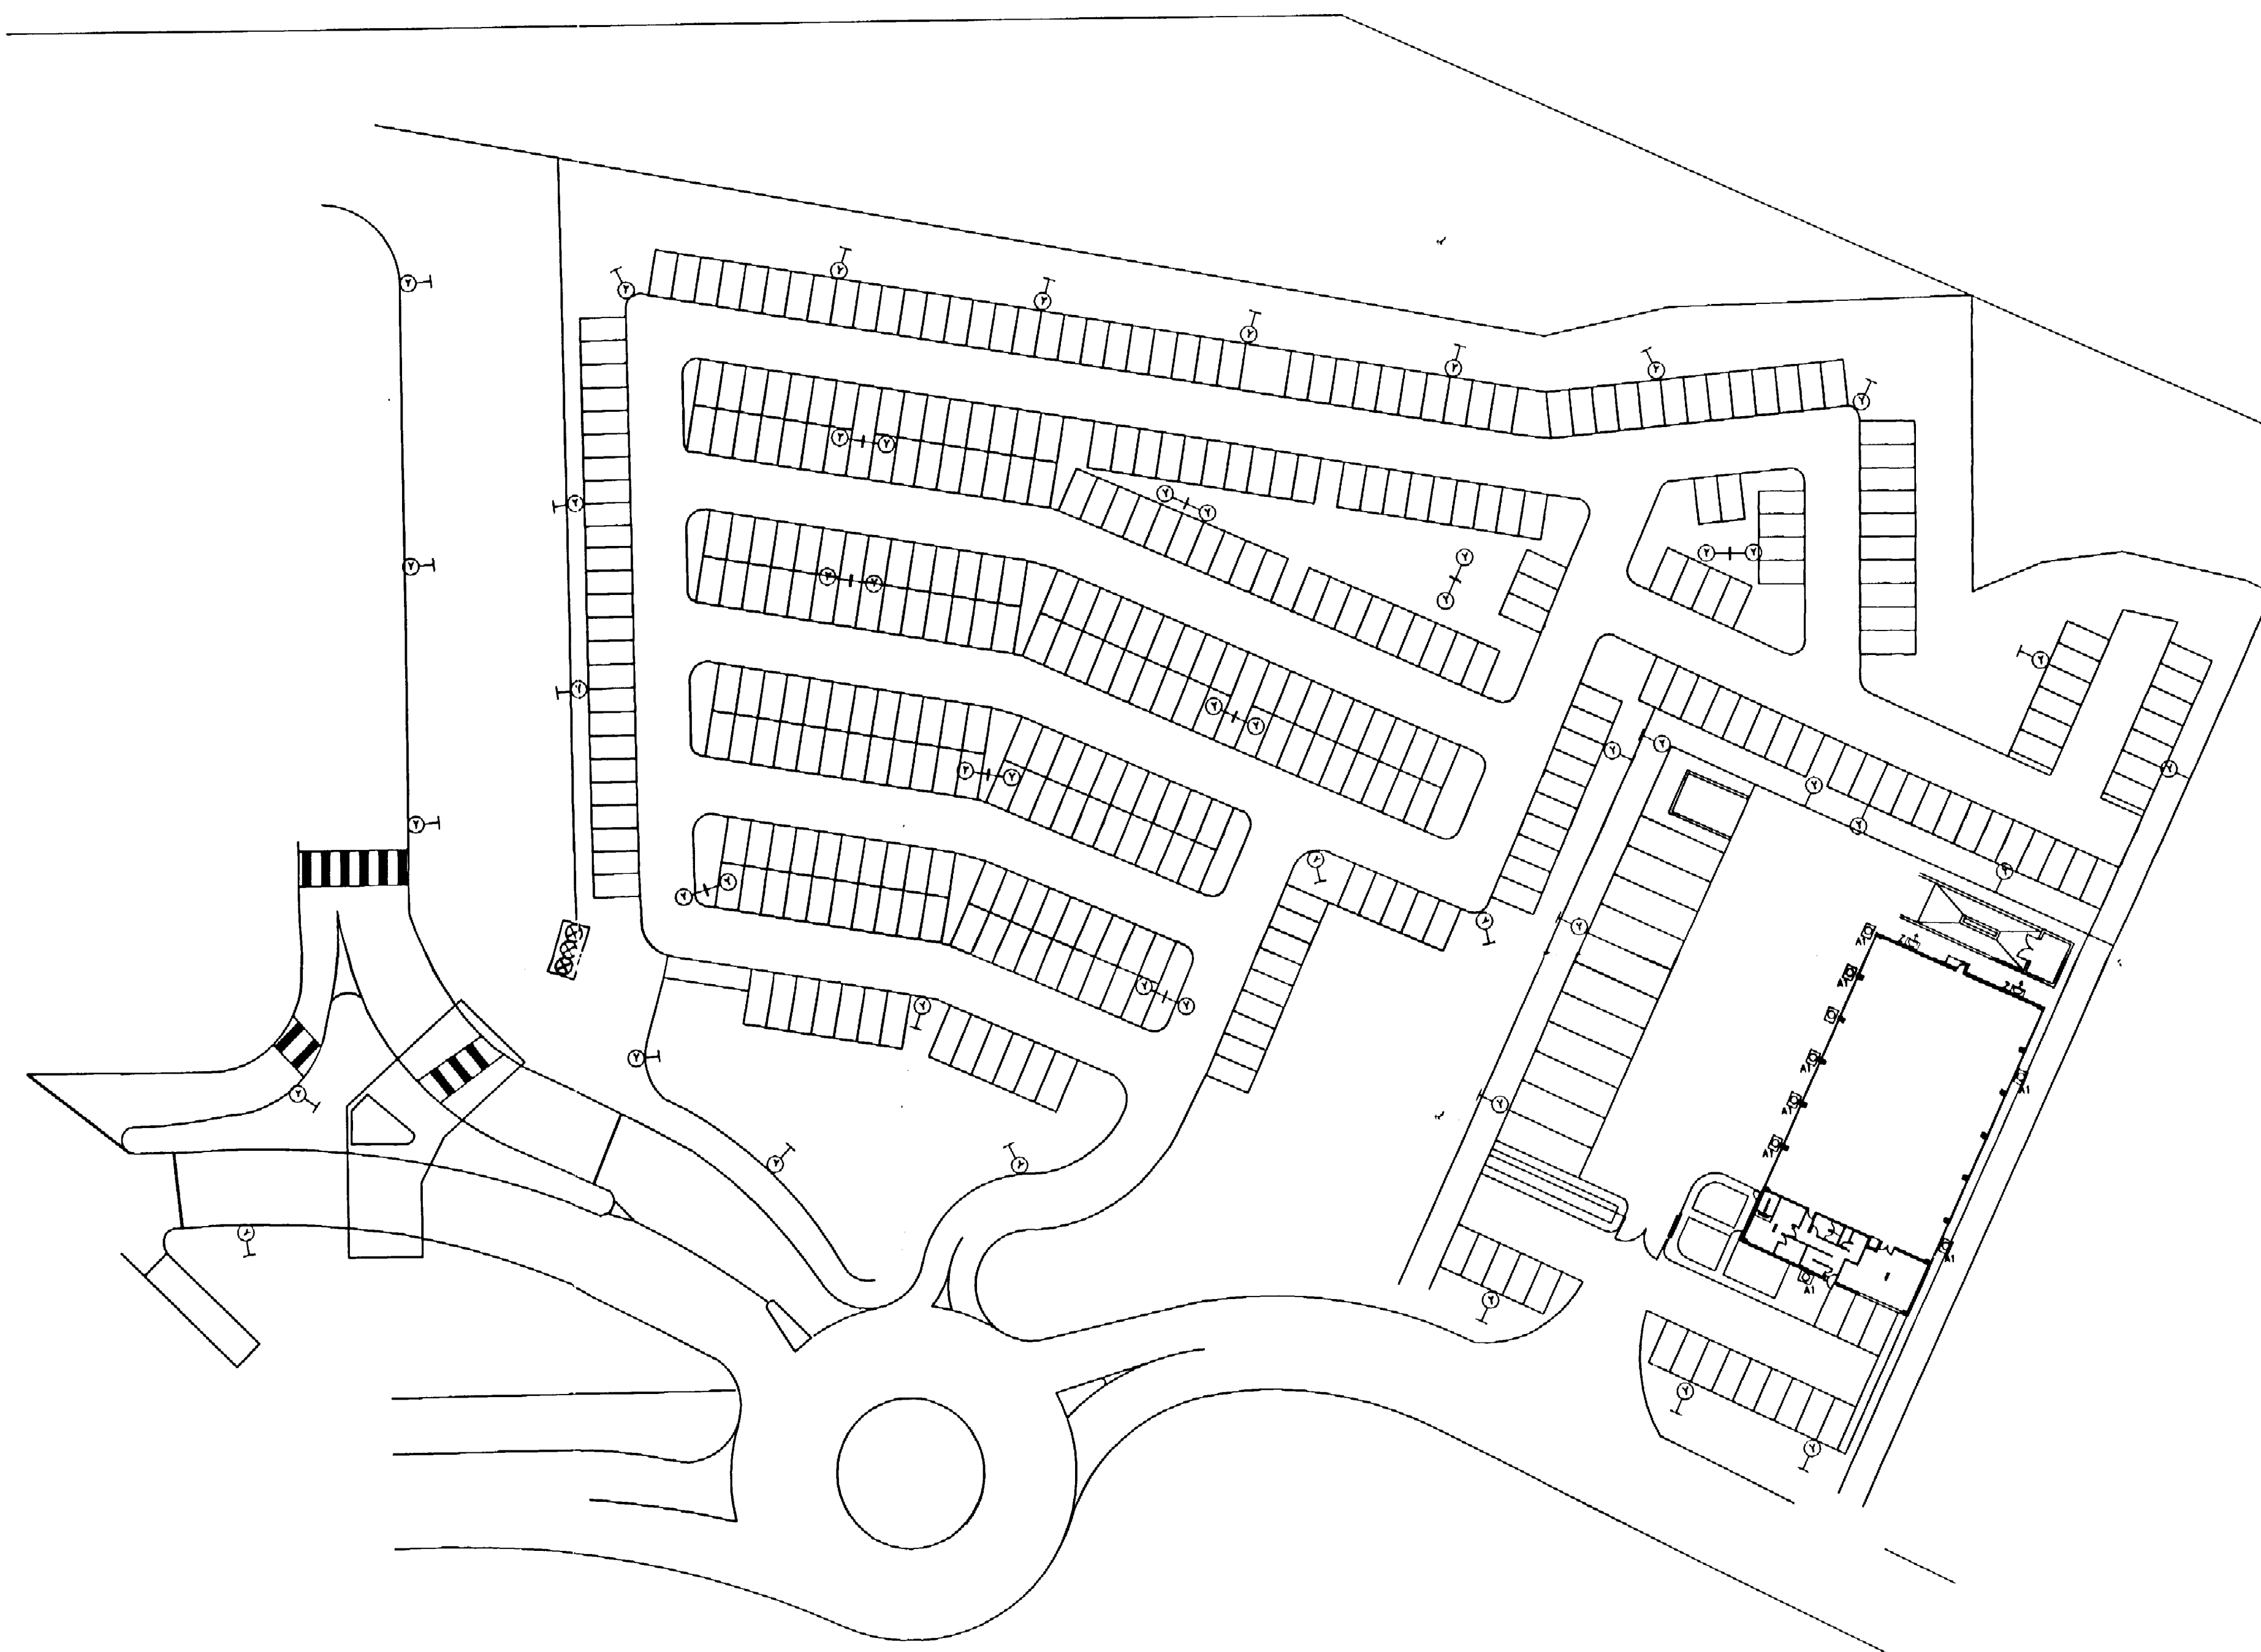

REV	DATE	DESCRIPTION	DWN	CHK'D
-----	------	-------------	-----	-------

CONTRACT
SECURICOR DISTRIBUTION
SUPER HUB
HATFIELD

CLIENT
P.S. TURNER
DESIGN & BUILD

TITLE
SITE PLAN
ELECTRICAL SERVICES
PART 2



Electrical & Mechanical Engineering Contractors

N G Bailey & Co Ltd

Rutland Road
Sheffield
S3 9PS

Tel. No. 0114 275 4678
Fax. No. 0114 273 8404



DESIGN & BUILD
Design Build, Green Bldg. Employer,
Unit 10, Turners Road, Hatfield,
Herts. AL9 9QJ
Tel: (01280) 800118

DESIGN STATUS	
STAGE 1	<input checked="" type="checkbox"/>
STAGE 2	<input checked="" type="checkbox"/>
STAGE 3	<input type="checkbox"/>

DRAWN BY			
NAME (PRINT)	SIGNATURE	DATE	
P.JONES	<i>P. Jones</i>	11/11/96	
CHECKED BY			
NAME (PRINT)	SIGNATURE	DATE	
J.G.O'NEIL			
SCALE 1/500	STATUS FOR APPROVAL		
DRG. NO. M4/34613/E2	REVISION		