

THIS DOCUMENT IS THE PROPERTY OF N. G. BAILEY & CO. LTD. IT IS NOT TO BE REPRODUCED OR USED FOR THE EXECUTION OF ANY WORKS WITHOUT THE EXPRESS CONSENT OF N. G. BAILEY & CO. LTD.



NATIONAL INSPECTION COUNCIL
FOR ELECTRICAL INSTALLATION CONTRACTORS

APPROVED CONTRACTOR



ELECTRICAL CONTRACTORS ASSOCIATION

MEMBER



HEATING & VENTILATION CONTRACTORS ASSOCIATION

MEMBER





THE QUALITY STANDARD
FOR ELECTRICAL
INSTALLATIONS

REGISTERED INSTALLER

NOTES

LEGEND

- PHILIPS SSS 203 LANTERN 150W
- SON-T 8m COLUMN
- PHILIPS SWF TUNPO 3 220W SON-T
- PHILIPS FLOODLIGHT SWF 705K 70W SON

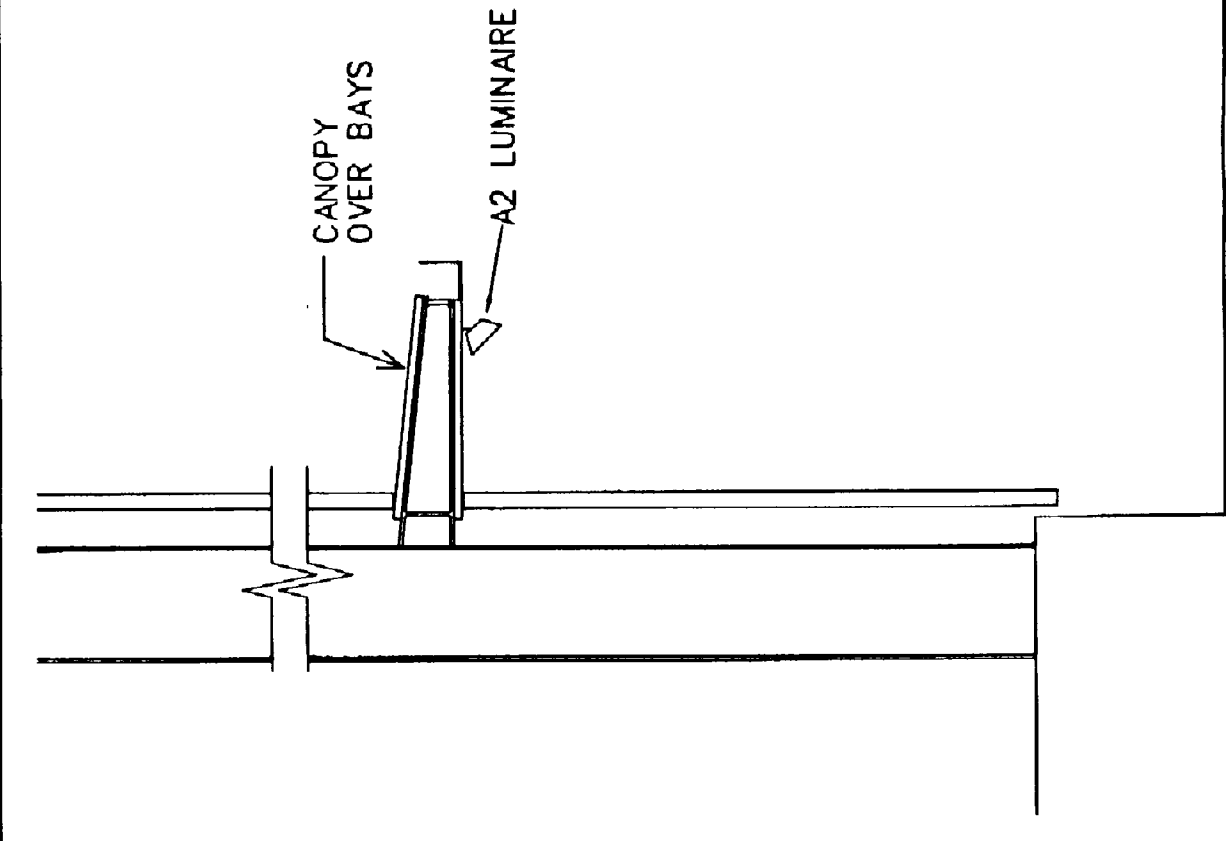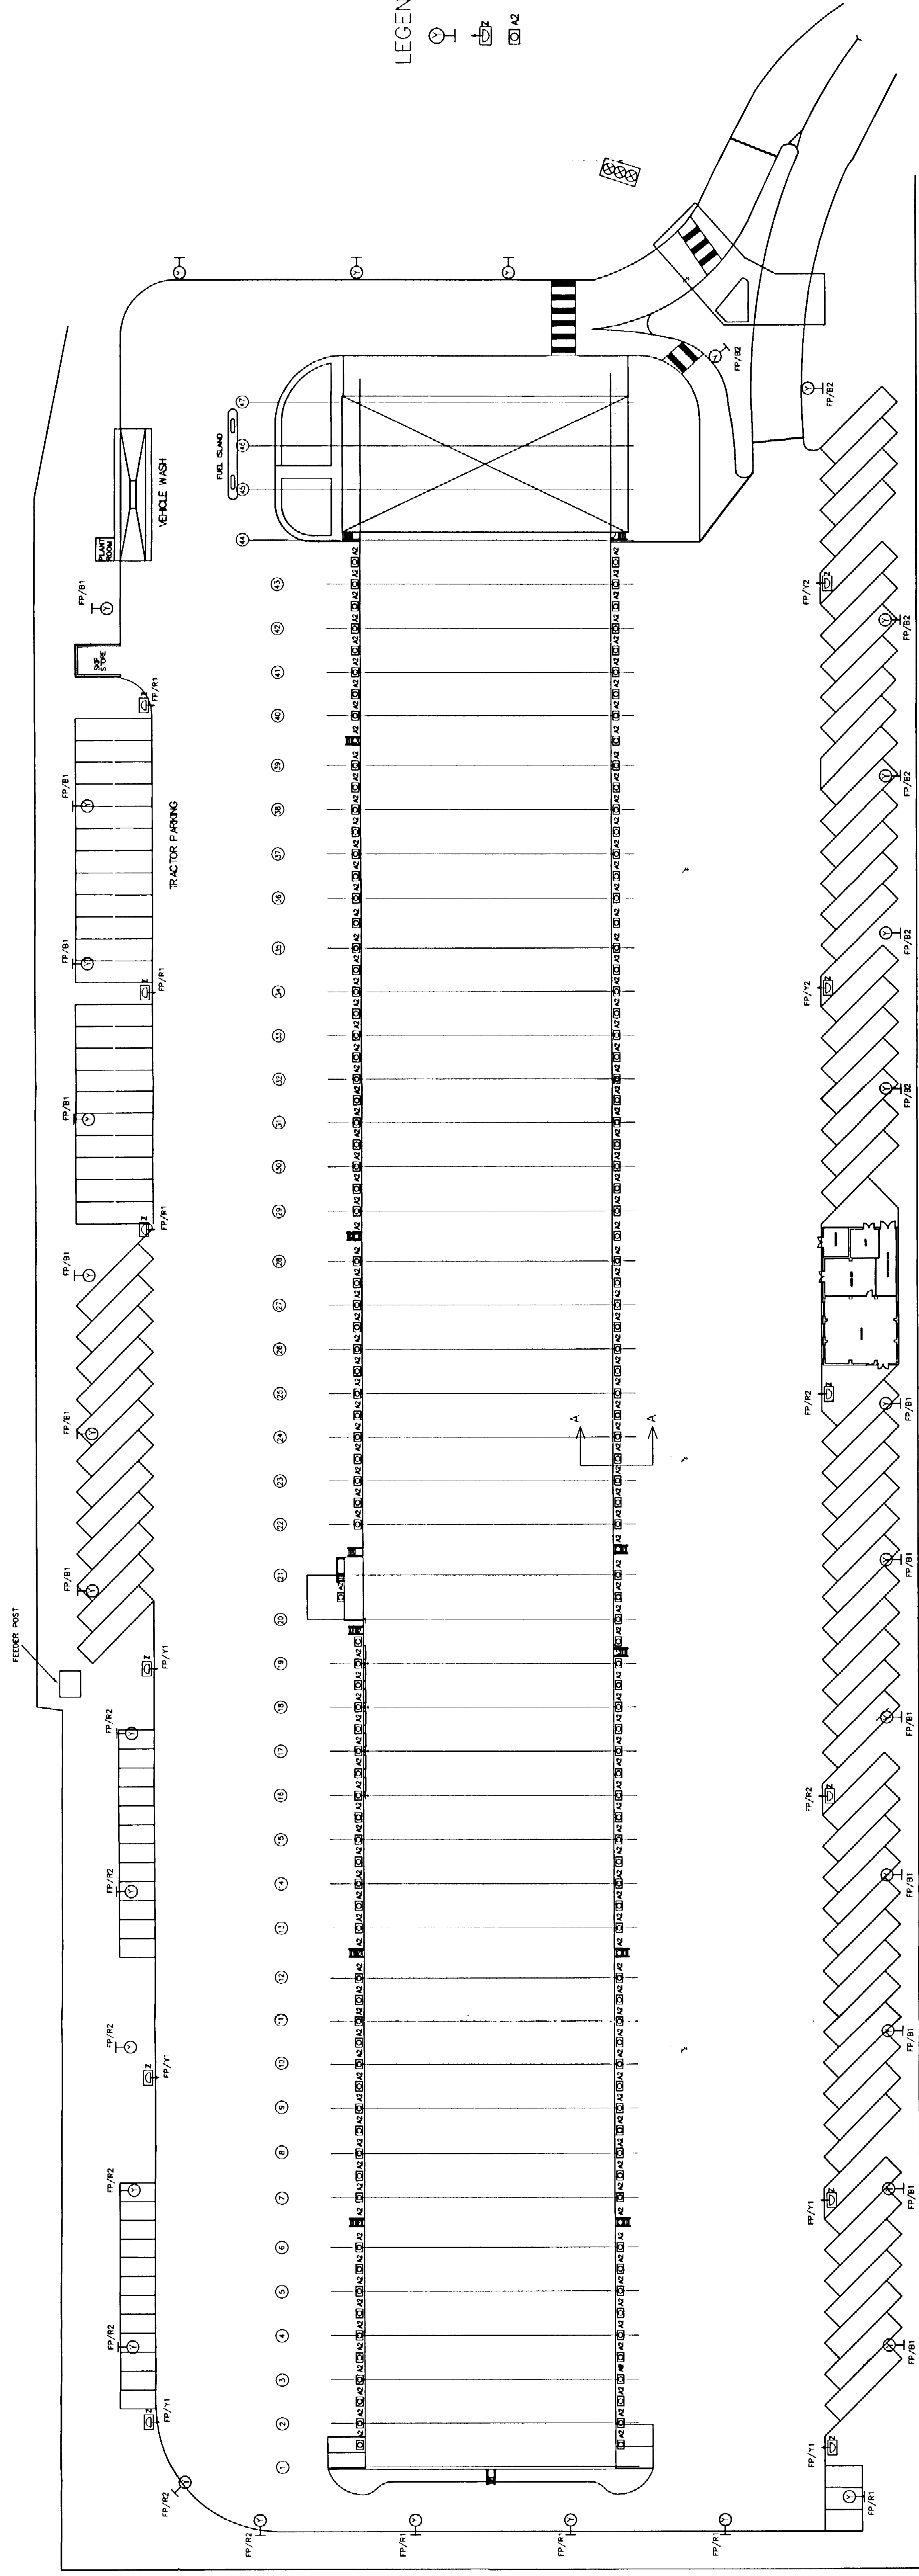


DETAIL 'A' - WAREHOUSE EXTERNAL BULKHEAD LIGHTING

REV.	DATE	DESCRIPTION	OWN. E.M.D.
1		SECURICOR DISTRIBUTION SUPER HUB HATFIELD	

CLIENT	P. S. TURNER DESIGN & BUILD
--------	--------------------------------

TITLE	SITE PLAN ELECTRICAL SERVICES PART 1
-------	--

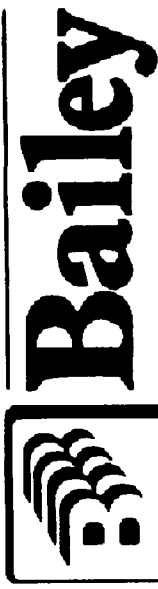

Electrical & Mechanical Engineering Contractors
N G Bailey & Co Ltd

Rutland Road
Sheffield
S3 9PS

Tel. No. 0114 275 4678
Fax. No. 0114 273 8404

NAME (PRINT)	DATE
P. JONES	11/11/96

NAME (PRINT)	DATE
J.C. O'NEIL	

SCALE 1:500	STATUS FOR APPROVAL	REGION
DOC. NO. M4/34613/E1		

DESIGN & BUILD	DESIGN STATUS
STAGE 1	
STAGE 2	
STAGE 3	