



INFORMATION ONLY

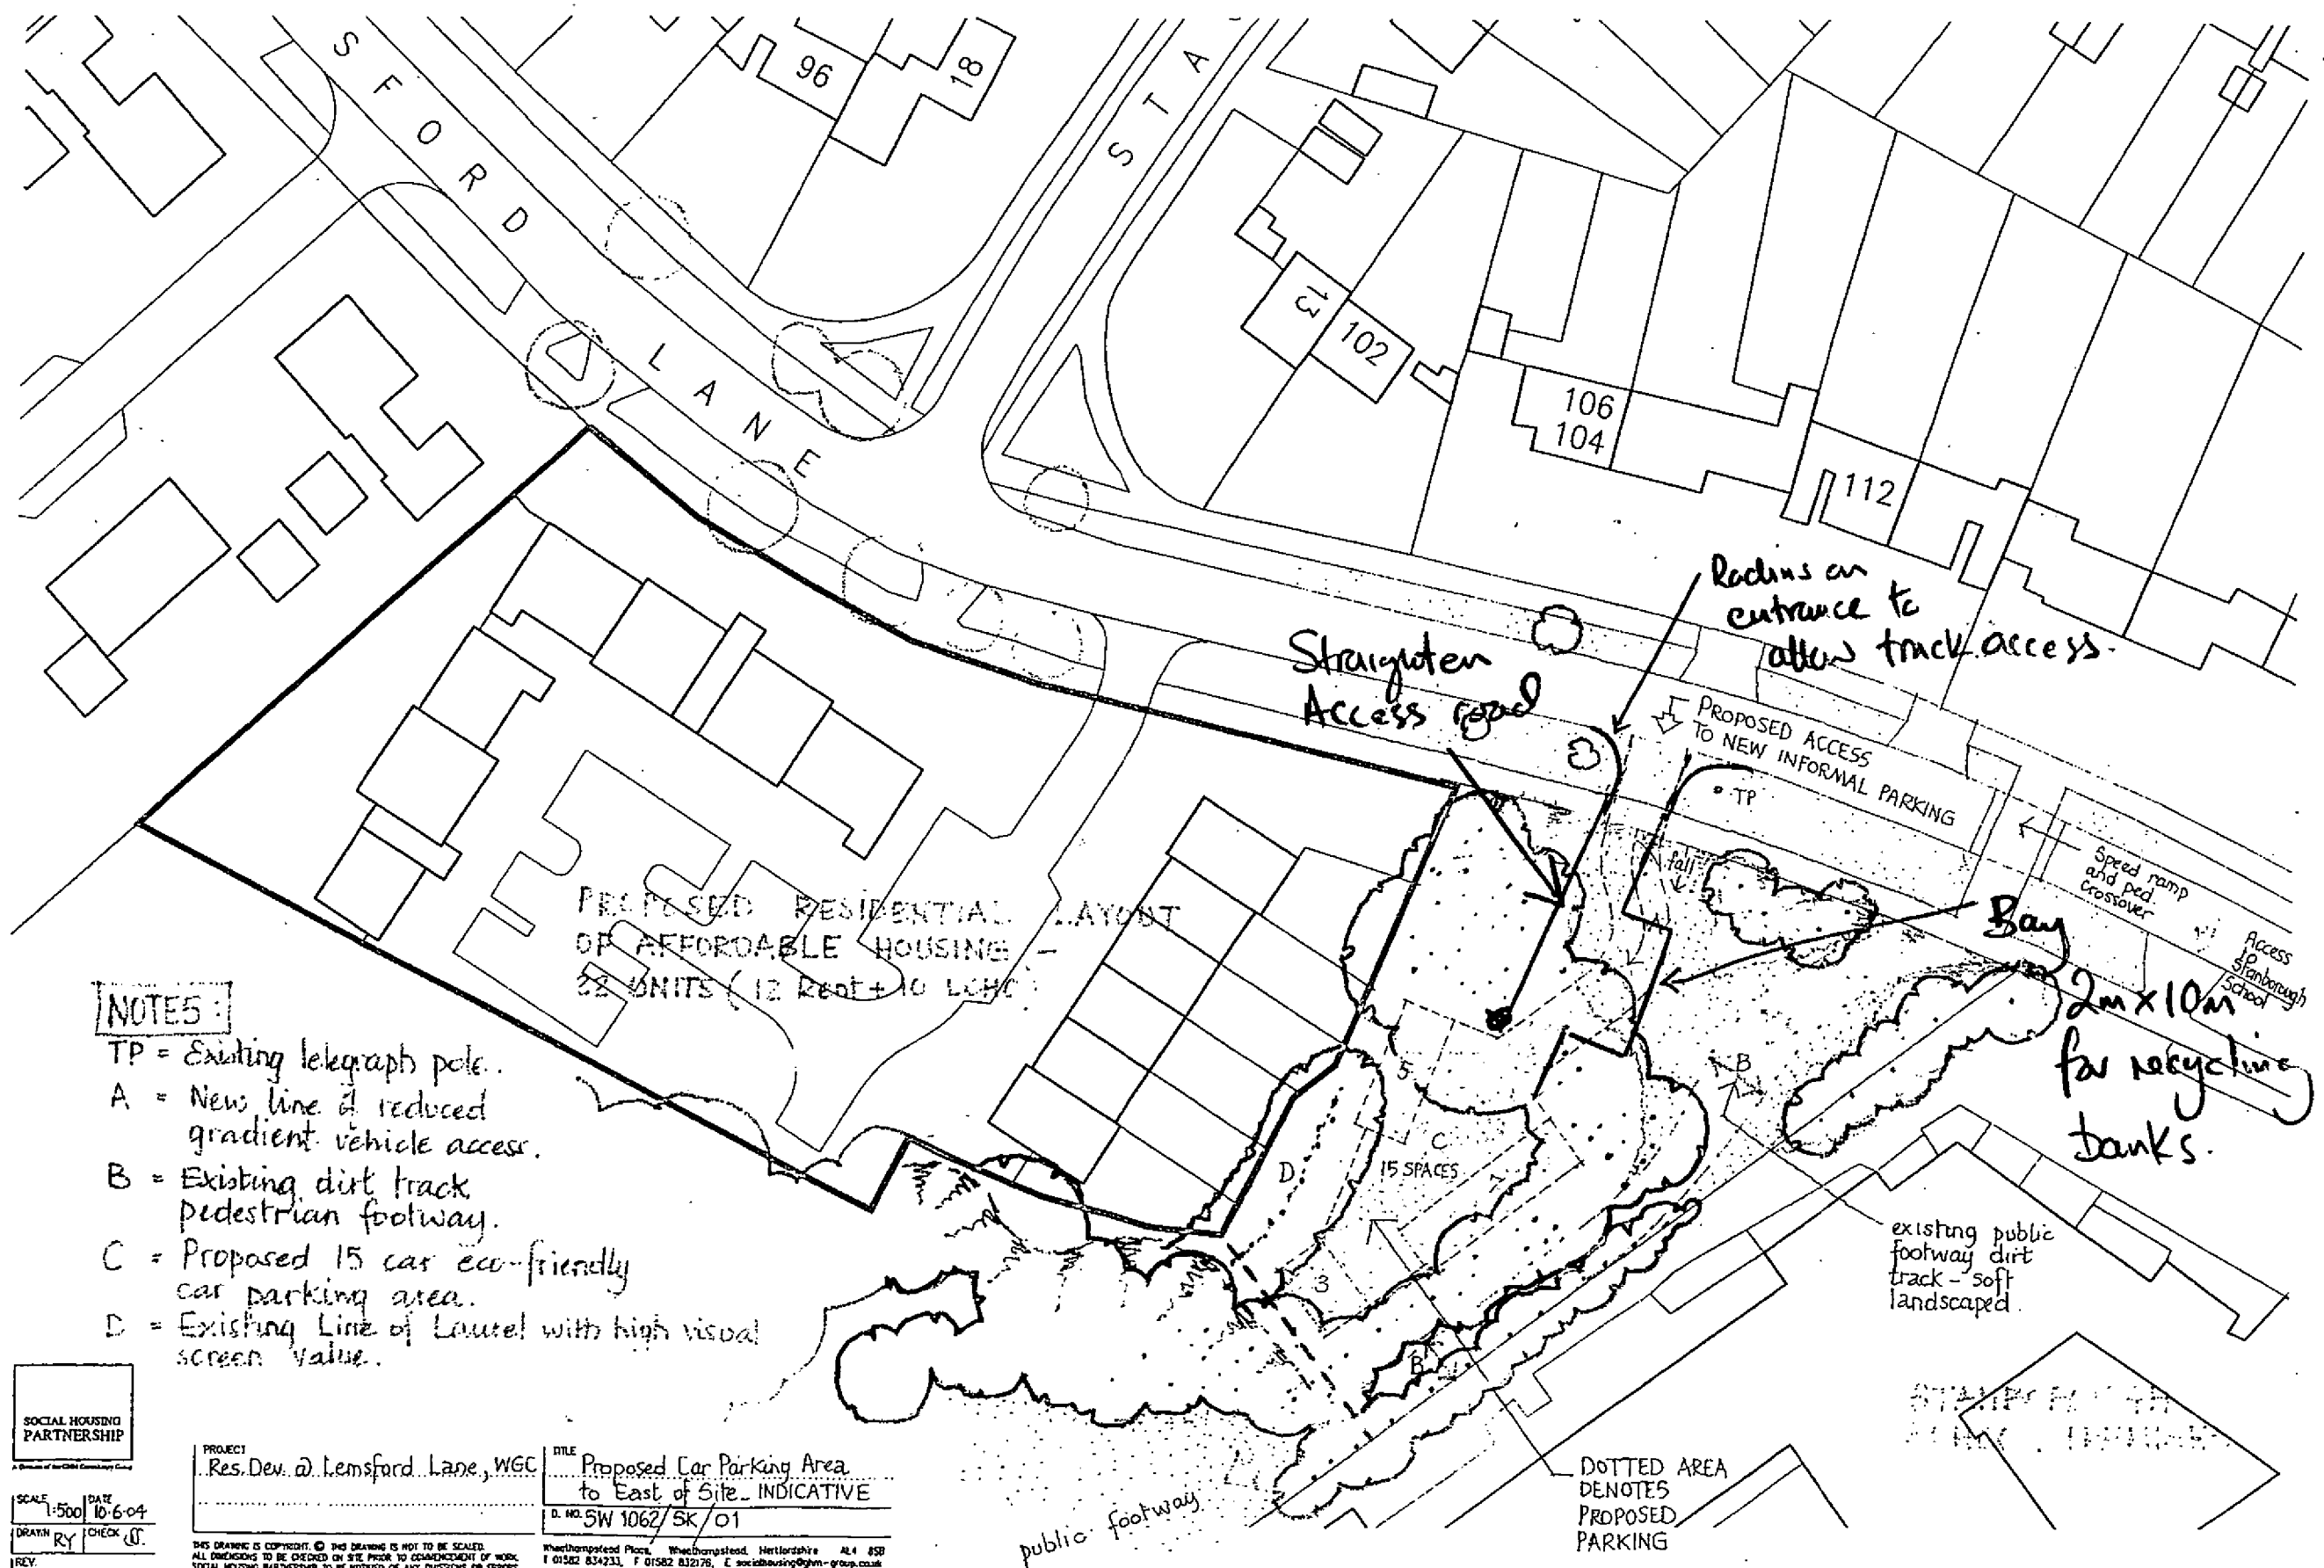

Maurice

Please see comments on this scheme
too.

Long

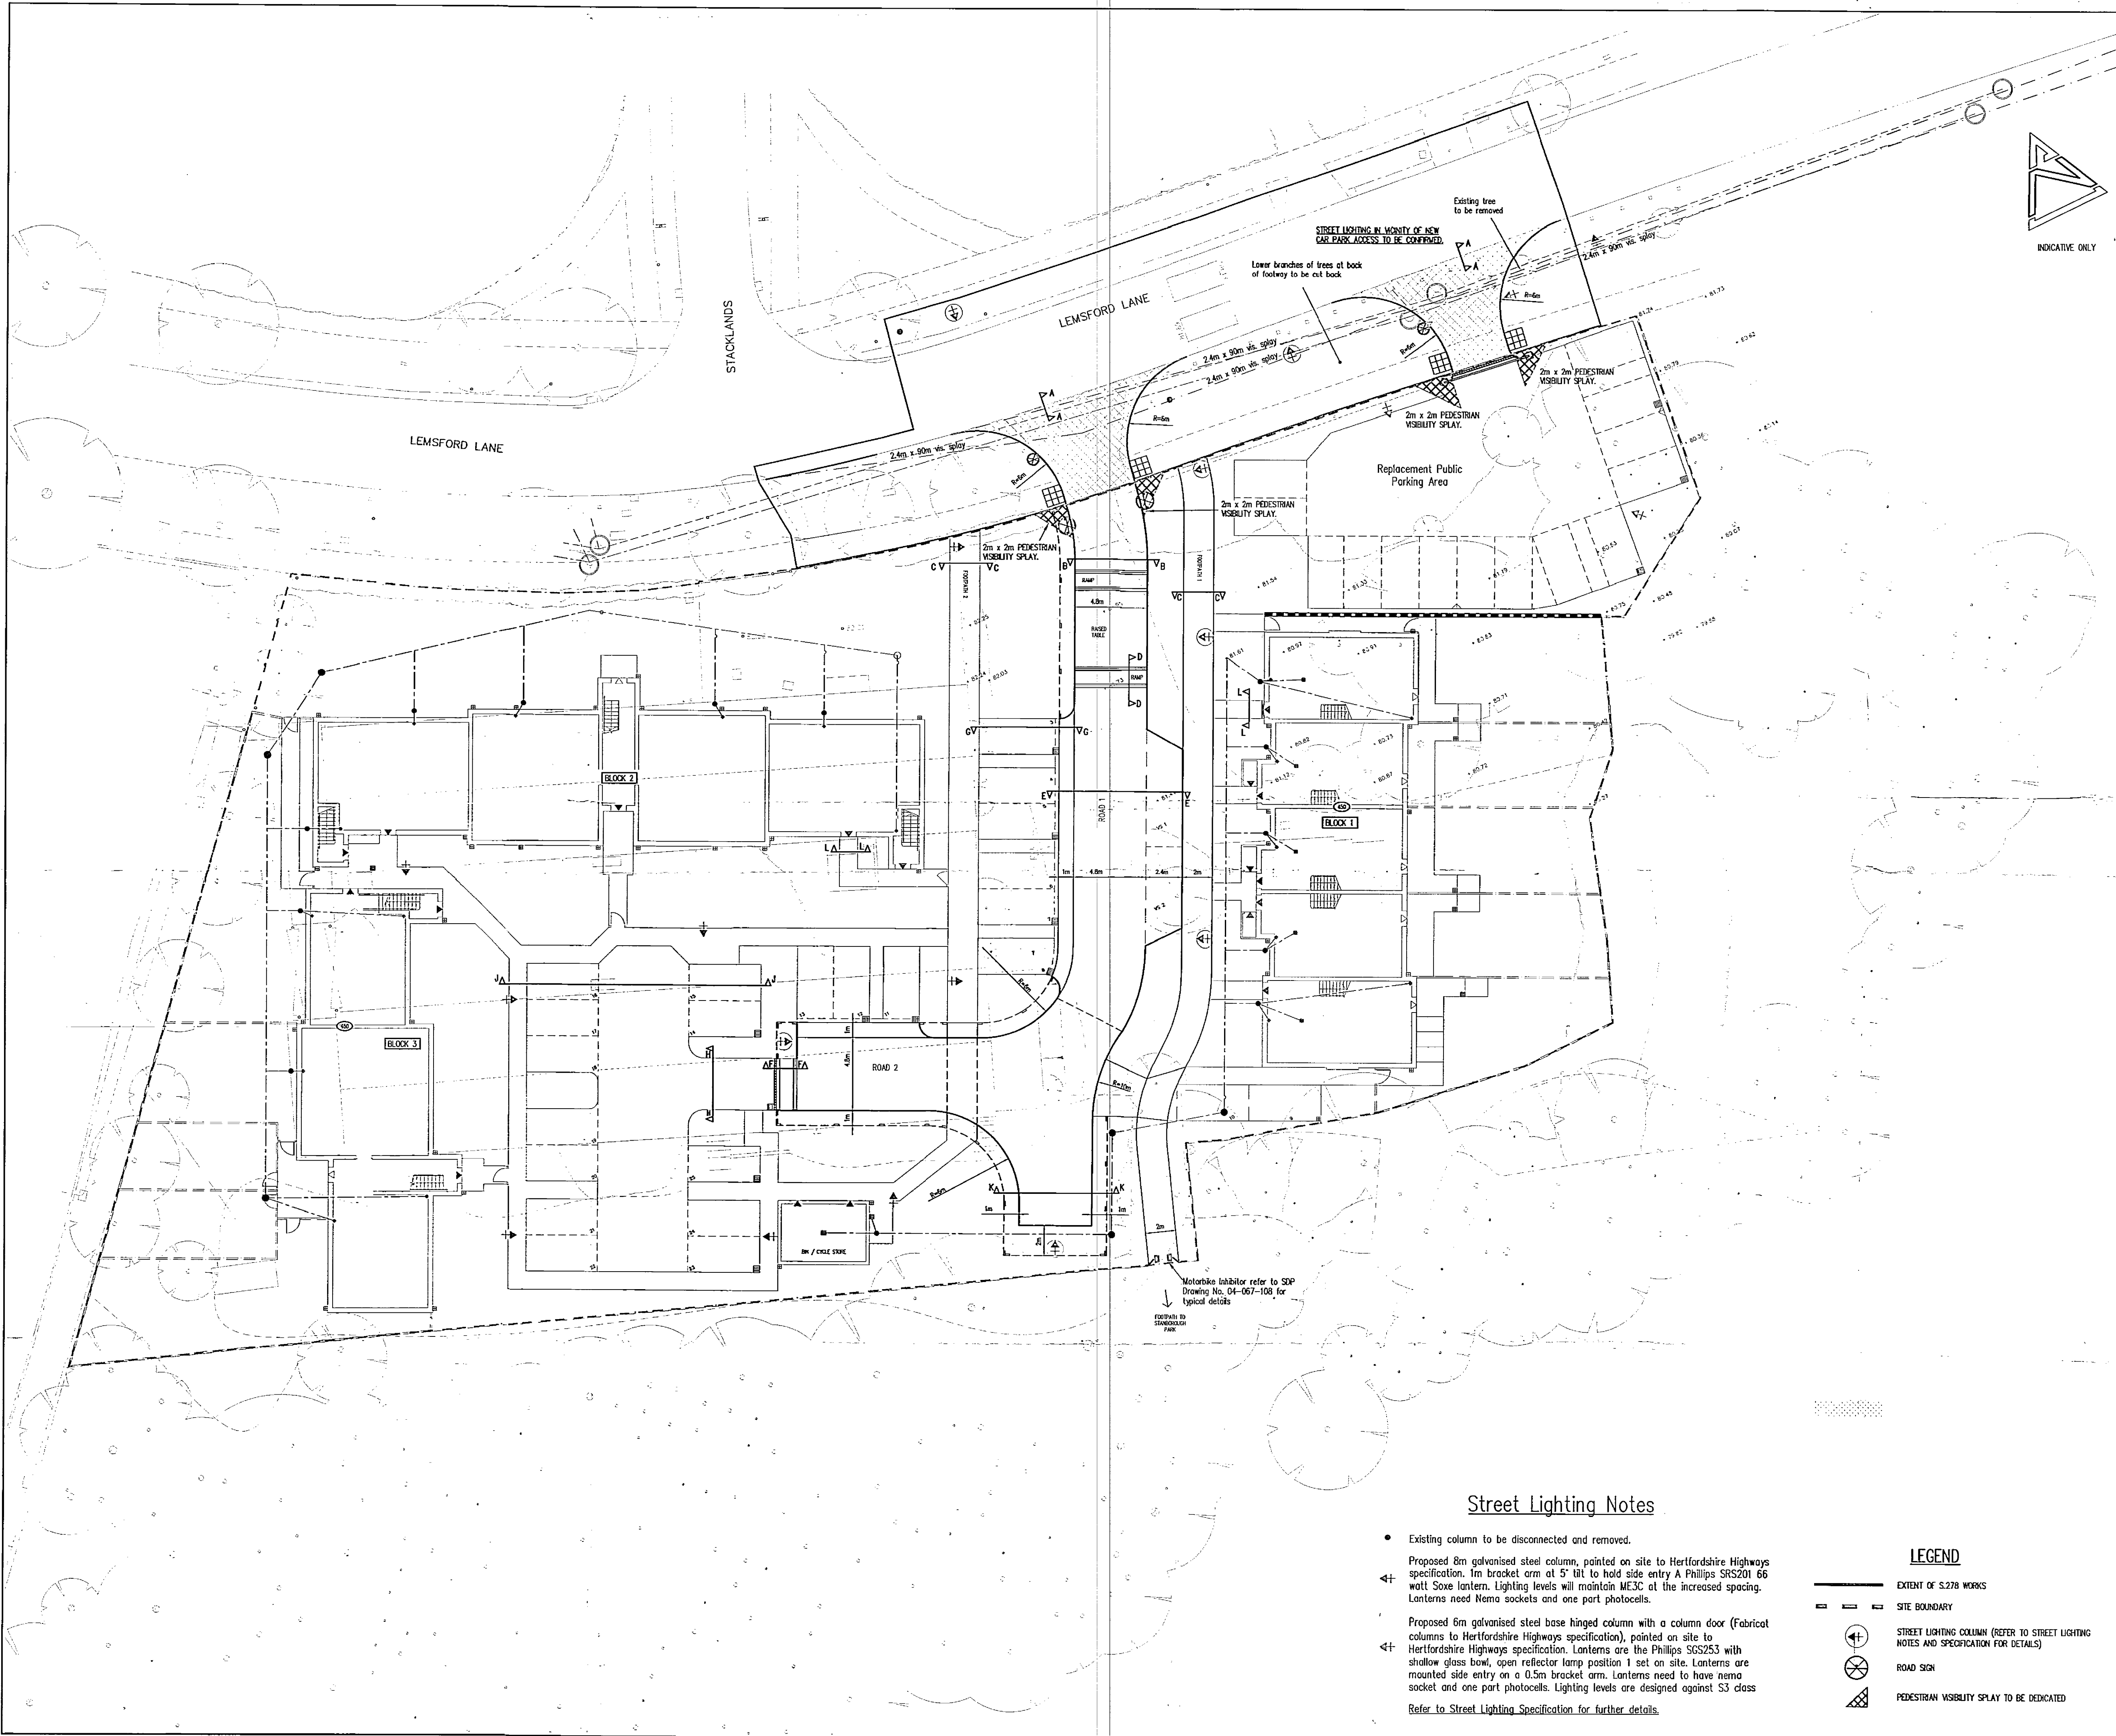

NOTES

1. THIS DRAWING SHALL BE READ IN CONJUNCTION WITH ALL RELEVANT ENGINEER'S DRAWINGS. ANY DISCREPANCIES FOUND BETWEEN INFORMATION SHOWN ON THIS OR ANY OTHER DRAWING SHALL BE REPORTED TO THE ENGINEER IMMEDIATELY AND PRIOR TO ANY WORKS COMMENCING ON SITE.
2. ALL CONNECTIONS TO ADAPTABLE MANHOLES SHALL BE VITRIFIED CLAY (EXTRA STRENGTH) AND BE 150mm DIA Min. REFER TO SITE AND DRAINAGE LAYOUT PLANS FOR ACTUAL SIZES.
3. ALL CONCRETE AT OR BELOW GROUND LEVEL ON SITE SHALL BE ABLE TO WITHSTAND CLASS D5-1 / AC-1 SULPHATE CONCENTRATIONS IN ACCORDANCE WITH THE BRE DIGEST 363.
4. ALL ADAPTABLE HIGHWAY WORKS SHALL BE UNDERTAKEN STRICTLY IN ACCORDANCE WITH THE CURRENT EDITION OF HERTFORDSHIRE COUNTY COUNCILS DESIGN GUIDE ENTITLED 'ROADS IN HERTFORDSHIRE - A GUIDE FOR NEW DEVELOPMENTS'. IT IS THE CONTRACTORS RESPONSIBILITY TO OBTAIN A COPY OF THIS DOCUMENT.
5. ALL ADAPTABLE DRAINAGE WORKS SHALL BE UNDERTAKEN STRICTLY IN ACCORDANCE WITH 'SEWERS FOR ADOPTION - FIFTH EDITION'. IT IS THE CONTRACTORS RESPONSIBILITY TO OBTAIN A COPY OF THIS DOCUMENT.

LOCATION PLAN
SCALE 1:200

REV	DATE	DESCRIPTION	BY	CHK
A	Sept 06	PEDESTRIAN VISIBILITY SPLAYS TO BE DEDICATED ADDED, AS REQUESTED BY HERTFORDSHIRE HIGHWAYS.	PJ	
B	Oct 06	PEDESTRIAN VISIBILITY SPLAYS EXTENDED TO MEET S278 BOUNDARY AND PEDESTRIAN VISIBILITY SPLAY BORDER COLOURED, AS REQUESTED BY HERTFORDSHIRE HIGHWAYS.	PJ	

STATUS

SUBJECT TO TECHNICAL APPROVAL

This drawing is the property and copyright of the Consulting Engineer and shall not without written consent be communicated to a third party.

CLIENT

McCANN HOMES Ltd (EASTERN REGION)

SITE

LEMSFORD LANE
WELWYN GARDEN CITY

TITLE

S.278 Agreement Plan

SDP

CONSULTING
ENGINEERS

Head Office, Suite 3, Salford House, Campfield Road,
St Albans, Hertfordshire, AL1 1HT
Tel: 01727 844606 Fax: 01727 830771
Email: mail@sdpc.co.uk

Southern Office, 21a Bargates,
Christchurch, Dorset, BH23 1QD.
Tel: 01202 496600 Fax: 01202 496601
Email: sdpsouth@sdpc.co.uk

SCALE	DRAWN	DATE
1:200 @ A1	AVJ	April 2005
CHECKED	PASSED	REV.
PB 14.04.05		B

DRAWING NO.

E04-067-119

Street Lighting Notes

- Existing column to be disconnected and removed.
 - Proposed 8m galvanised steel column, painted on site to Hertfordshire Highways specification. 1m bracket arm at 5' tilt to hold side entry A Phillips SRS201 66 watt Soxe lantern. Lighting levels will maintain ME3C at the increased spacing. Lanterns need Nema sockets and one port photocells.
 - Proposed 6m galvanised steel base hinged column with a column door (Fabricat columns to Hertfordshire Highways specification), painted on site to Hertfordshire Highways specification. Lanterns are the Phillips SCS253 with shallow glass bowl, open reflector lamp position 1 set on site. Lanterns are mounted side entry on a 0.5m bracket arm. Lanterns need to have nema socket and one port photocells. Lighting levels are designed against S3 class
- Refer to Street Lighting Specification for further details.

LEGEND

EXTENT OF S.278 WORKS

SITE BOUNDARY

STREET LIGHTING COLUMN (REFER TO STREET LIGHTING NOTES AND SPECIFICATION FOR DETAILS)

ROAD SIGN

PEDESTRIAN VISIBILITY SPLAY TO BE DEDICATED