

FLOODLIGHTING EQUIPMENT:

16 x 10m MASTS (M1-M16)
 M1, M4, M13, M16..... 1 x AL5780ZKVMH-TS2000W/XL
 M2, M3, M5, M8
 M9, M12, M14, M15..... 2 x AL5780ZKVMH-TS2000W/XL
 M6, M7, M10, M11..... 4 x AL5780ZKVMH-TS2000W/XL

LAMPS (VENTURE):

2KVMH-TS 2000W/XL/K12745 (240 000 INITIAL Lm)
 ILLUMINANCE LEVELS: (INDIVIDUALLY SWITCHED)
 INITIAL (100 Hrs)
 EL.ave = 639 LUX


MAINTAINED (4000 Hrs)

E.m.ave = 492 LUX
 UNIFORMITY
 Emin/Eave = 0.7

GRID VALUES IN LUX
 GRID INTERVAL = 5m
 CONTOUR VALUES IN LUX
 CONTOURS 2.5, 10, 25, 50 LUX
 MAINTENANCE FACTOR = 0.77

REVISION	DETAILS	BY	DATE	CHECKED

SPORTS LABS LTD
 128 Nesscroft Court
 Houston Industrial Estate
 Livingston, EH64 5EG
 T. +44(0) 845 602 6354
 Fax: +44(0) 845 602 6356
 E-mail: info@sportslabs.co.uk

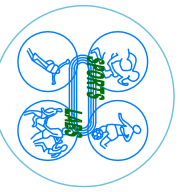


STANBOROUGH SCHOOL
 PROPOSED NETBALL COURTS
 SITE PLAN & GENERAL ARRANGEMENT

Drawn: MAB/TS	Job No.:	Drawn by: TD
Scale: As Shown		Checked by: RB

01 GENERAL ARRANGEMENT

 SCALE: 1:1000



Aerial imagery © 2013 Microsoft