


NORTH ELEVATION



SOUTH ELEVATION

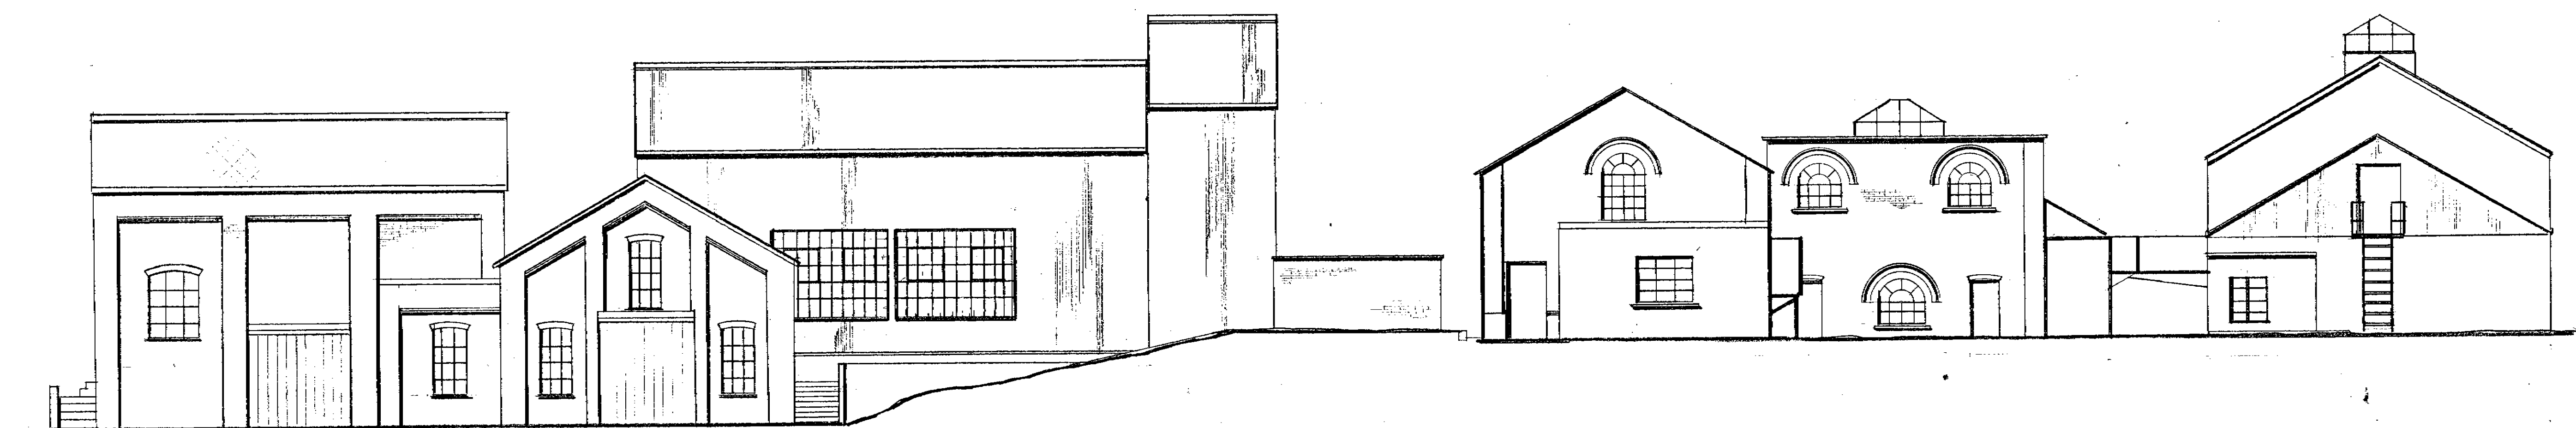

WEST ELEVATION

AMY 48

LEE VALLEY WATER COMPANY CHIEF ENGINEER K. J. REYNOLDS, B.Sc. Eng., F.I.C.E., F.I.Mech.E., F.I.W.E.S. BISHOPS RISE, HATFIELD, HERTS.	
NORTH MYMMS EXISTING ELEVATIONS	
DRAWING No. 105/139	REVISION

DRAWN	TRACED	APPROVED	DATE	SCALE
S.B.K.	82/2/77		FEB 77	1:100