
 


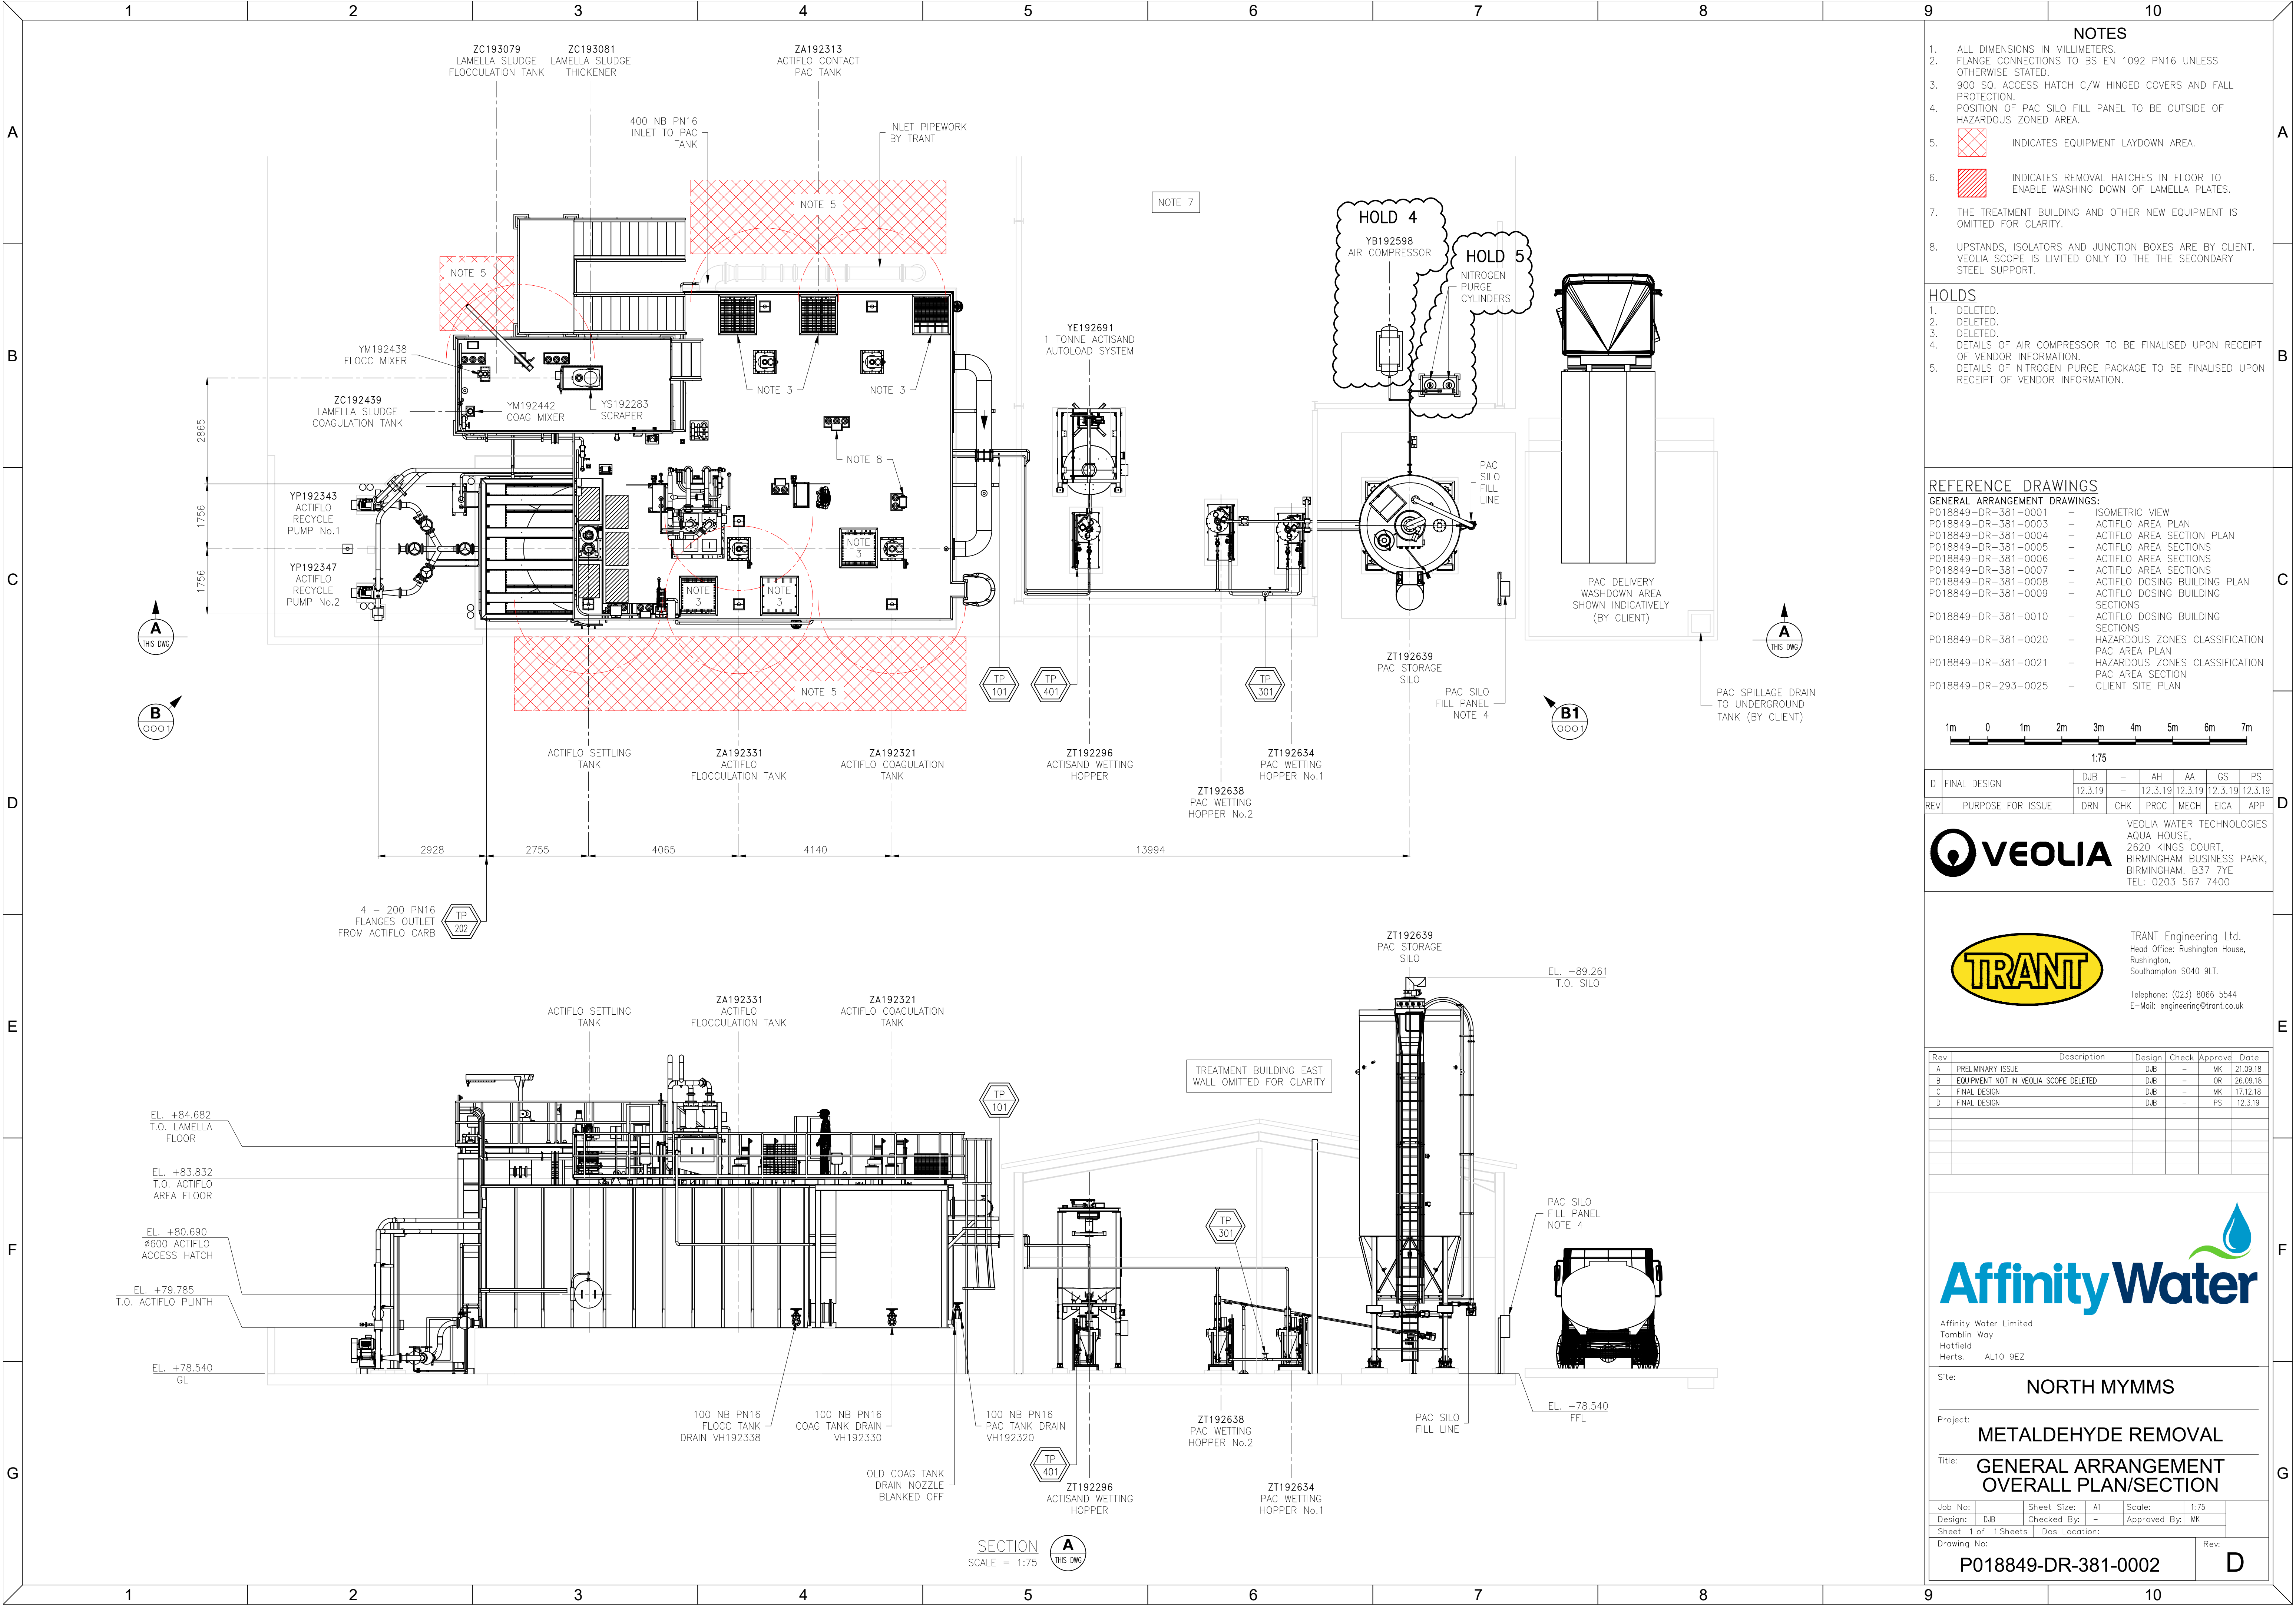

- NOTES**
- ALL DIMENSIONS IN MILLIMETERS.
 - FLANGE CONNECTIONS TO BS EN 1092 PN16 UNLESS OTHERWISE STATED.
 - 900 SQ. ACCESS HATCH C/W HINGED COVERS AND FALL PROTECTION.
 - POSITION OF PAC SILO FILL PANEL TO BE OUTSIDE OF HAZARDOUS ZONED AREA.
 - INDICATES EQUIPMENT LAYDOWN AREA.
 - INDICATES REMOVAL HATCHES IN FLOOR TO ENABLE WASHING DOWN OF LAMELLA PLATES.
 - THE TREATMENT BUILDING AND OTHER NEW EQUIPMENT IS OMITTED FOR CLARITY.
 - UPSTANDS, ISOLATORS AND JUNCTION BOXES ARE BY CLIENT. VEOLIA SCOPE IS LIMITED ONLY TO THE THE SECONDARY STEEL SUPPORT.

- HOLDS**
- DELETED.
 - DELETED.
 - DELETED.
 - DETAILS OF AIR COMPRESSOR TO BE FINALISED UPON RECEIPT OF VENDOR INFORMATION.
 - DETAILS OF NITROGEN PURGE PACKAGE TO BE FINALISED UPON RECEIPT OF VENDOR INFORMATION.

- REFERENCE DRAWINGS**
- GENERAL ARRANGEMENT DRAWINGS:
- P018849-DR-381-0001 - ISOMETRIC VIEW
 - P018849-DR-381-0003 - ACTIFLO AREA PLAN
 - P018849-DR-381-0004 - ACTIFLO AREA SECTION PLAN
 - P018849-DR-381-0005 - ACTIFLO AREA SECTIONS
 - P018849-DR-381-0006 - ACTIFLO AREA SECTIONS
 - P018849-DR-381-0007 - ACTIFLO AREA SECTIONS
 - P018849-DR-381-0008 - ACTIFLO DOSING BUILDING PLAN
 - P018849-DR-381-0009 - ACTIFLO DOSING BUILDING SECTIONS
 - P018849-DR-381-0010 - ACTIFLO DOSING BUILDING SECTIONS
 - P018849-DR-381-0020 - HAZARDOUS ZONES CLASSIFICATION
 - P018849-DR-381-0021 - HAZARDOUS ZONES CLASSIFICATION
 - P018849-DR-293-0025 - CLIENT SITE PLAN



D	FINAL DESIGN	12.3.19	-	12.3.19	12.3.19	12.3.19	12.3.19
REV	PURPOSE FOR ISSUE	DRN	CHK	PROC	MECH	EICA	APP

VEOLIA

VEOLIA WATER TECHNOLOGIES
AQUA HOUSE,
2620 KINGS COURT,
BIRMINGHAM BUSINESS PARK,
BIRMINGHAM. B37 7YE
TEL: 0203 567 7400

TRANT

TRANT Engineering Ltd.
Head Office: Rushington House,
Rushington,
Southampton SO40 9LT.
Telephone: (023) 8066 5544
E-Mail: engineering@trant.co.uk

Rev	Description	Design	Check	Approve	Date
A	PRELIMINARY ISSUE	DJB	-	MK	21.09.18
B	EQUIPMENT NOT IN VEOLIA SCOPE DELETED	DJB	-	OR	26.09.18
C	FINAL DESIGN	DJB	-	MK	17.12.18
D	FINAL DESIGN	DJB	-	PS	12.3.19

Affinity Water

Affinity Water Limited
Tomblin Way
Hatfield
Herts. AL10 9EZ

Site: **NORTH MYMMS**

Project: **METALDEHYDE REMOVAL**

Title: **GENERAL ARRANGEMENT
OVERALL PLAN/SECTION**

Job No:	Sheet Size:	A1	Scale:	1:75	
Design:	DJB	Checked By:	-	Approved By:	MK
Sheet 1 of 1 Sheets	Dos Location:				
Drawing No:	P018849-DR-381-0002				
Rev:	D				