


- GENERAL NOTES.
- DO NOT SCALE THIS DRAWING.
  - THIS DRAWING IS TO BE READ IN CONJUNCTION WITH ALL OTHER RELEVANT ENGINEERS, ARCHITECTS AND SPECIALIST DESIGN DRAWINGS AND DETAILS.
  - ALL DIMENSIONS ARE IN METRES UNLESS NOTED OTHERWISE. ALL LEVELS ARE IN METRES UNLESS NOTED OTHERWISE.
  - THIS DRAWING IS FOR STRATEGY PURPOSES ONLY AND IS NOT TO BE USED FOR CONSTRUCTION PURPOSES.

- KEY.
- PROPOSED FOUL WATER DRAIN
  - PROPOSED FOUL WATER MANHOLE
  - PROPOSED SURFACE WATER DRAIN
  - PROPOSED SURFACE WATER MANHOLE
  - PROPOSED DRAINAGE CHANNEL
  - PROPOSED GULLY
  - SEWER EASEMENT
  - PROPOSED PERMEABLE PAVING
  - EXISTING SURFACE WATER DRAIN

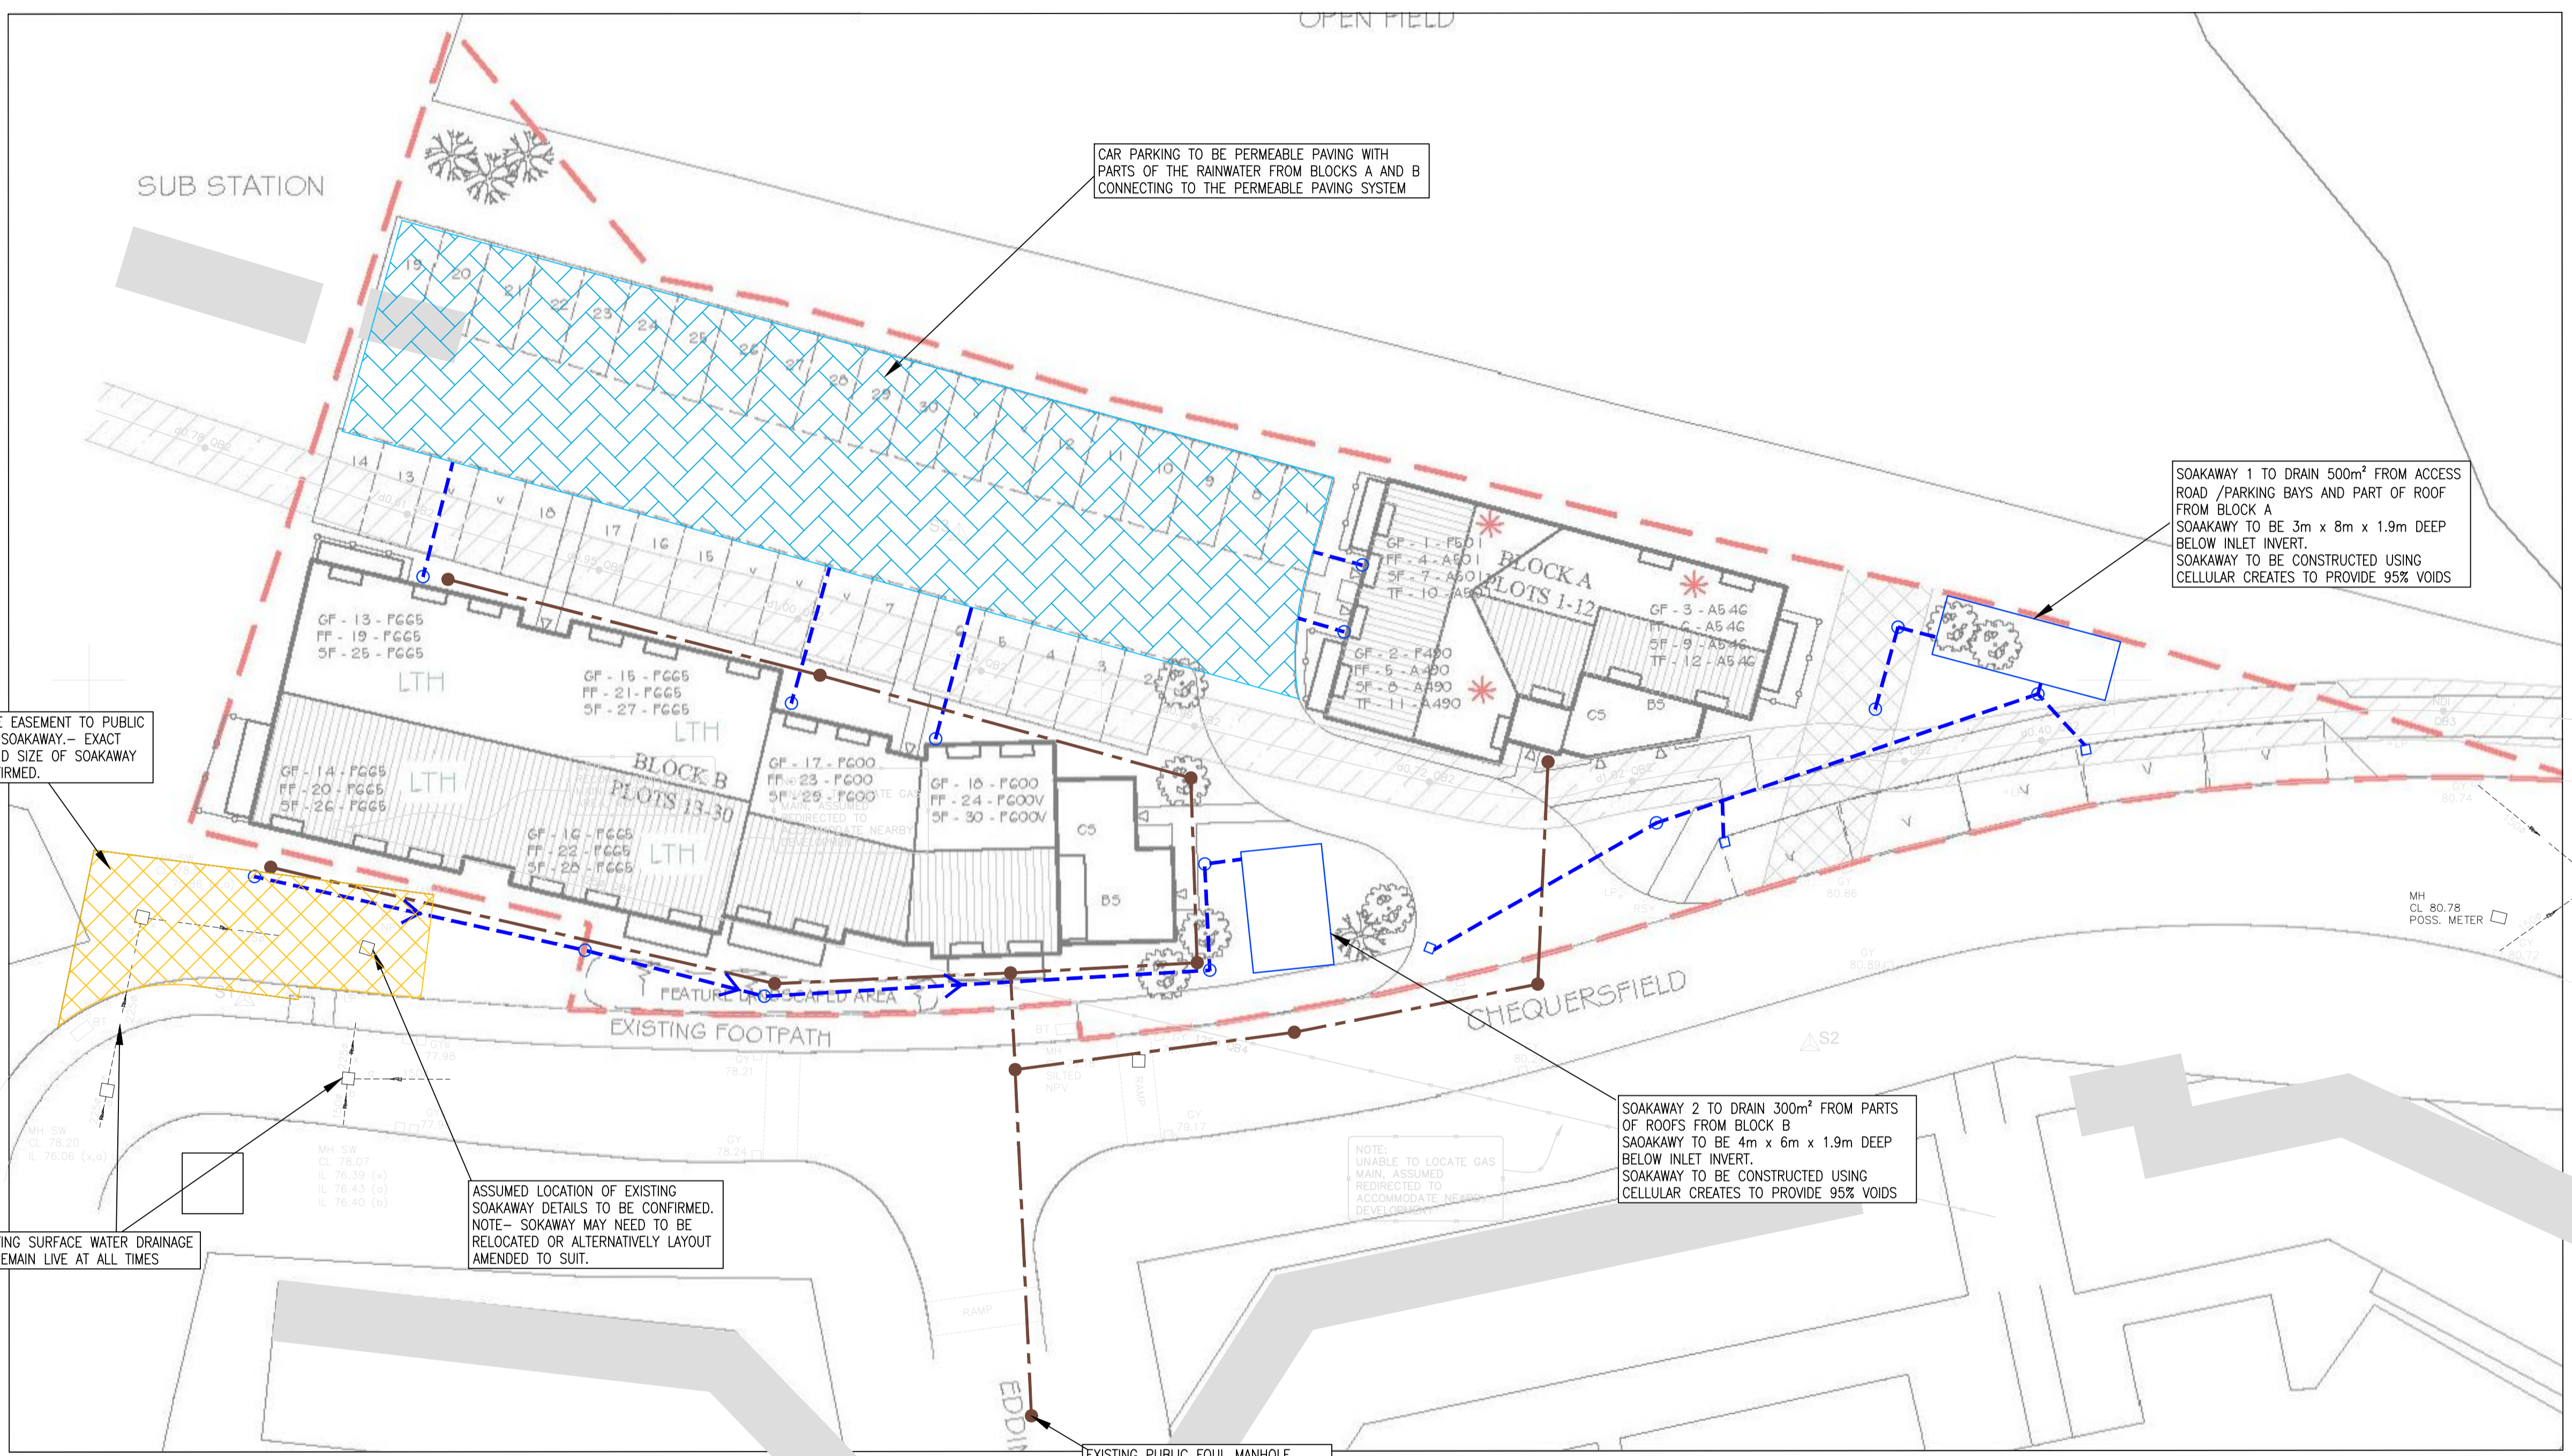

B	LATEST SITE LAYOUT (15/02/2018) ADDED	BB	MG2	23/05/18
A	LATEST SITE LAYOUT (15/02/2018) ADDED	BD	MG2	23/05/18
REV.	AMENDMENTS	DRN	CHK.	DATE:

PROJECT:  
**LAND NORTH OF CHEQUERSFIELD,  
WELWYN GARDEN CITY**

DRAWING TITLE:  
**DRAINAGE STRATEGY**

CLIENT:  
**TAYLOR WIMPEY (NORTH THAMES)**

DRAWING NUMBER:  
**22573\_02\_070\_001**

REVISION:	SHEET SIZE:	SCALE:
B	A1	1:200

DRAWN BY:	CHECKED BY:	DATE:
PS	MG2	18.05.18

STATUS:  
**PRELIMINARY**

**M-EC** Consulting Development Engineers  
 Leicester T: 01530 264 723  
 Birmingham T: 0121 2626 045  
 Milton Keynes T: 01908 440 042  
 Nottingham T: 0115 838 0990  
 Leeds T: 0115 468 1127  
 E: group@m-ec.co.uk  
 www.m-ec.co.uk

ORDNANCE SURVEY © CROWN COPYRIGHT 2015. ALL RIGHTS RESERVED.  
 LICENCE NUMBER 100055845.

File Location: \\M:\EC\Job Book\22573\Drawings\01 - Hydrology\22573\_02\_070\_001 rev B Drainage Layout.dwg  
 Printed: 25.05.2018