


**SURFACE WATER DRAINAGE  
EFFLUENT WATER DRAINAGE  
SOIL WATER DRAINAGE**

**Notes**  
 © This drawing is copyright and must not be reproduced or copied to any third party without the written permission of Norder Design Associates Ltd.  
 All dimensions must be checked on site.  
 Only figured dimensions should be worked from.  
 Discrepancies must be reported to Norder Design Associates before proceeding.

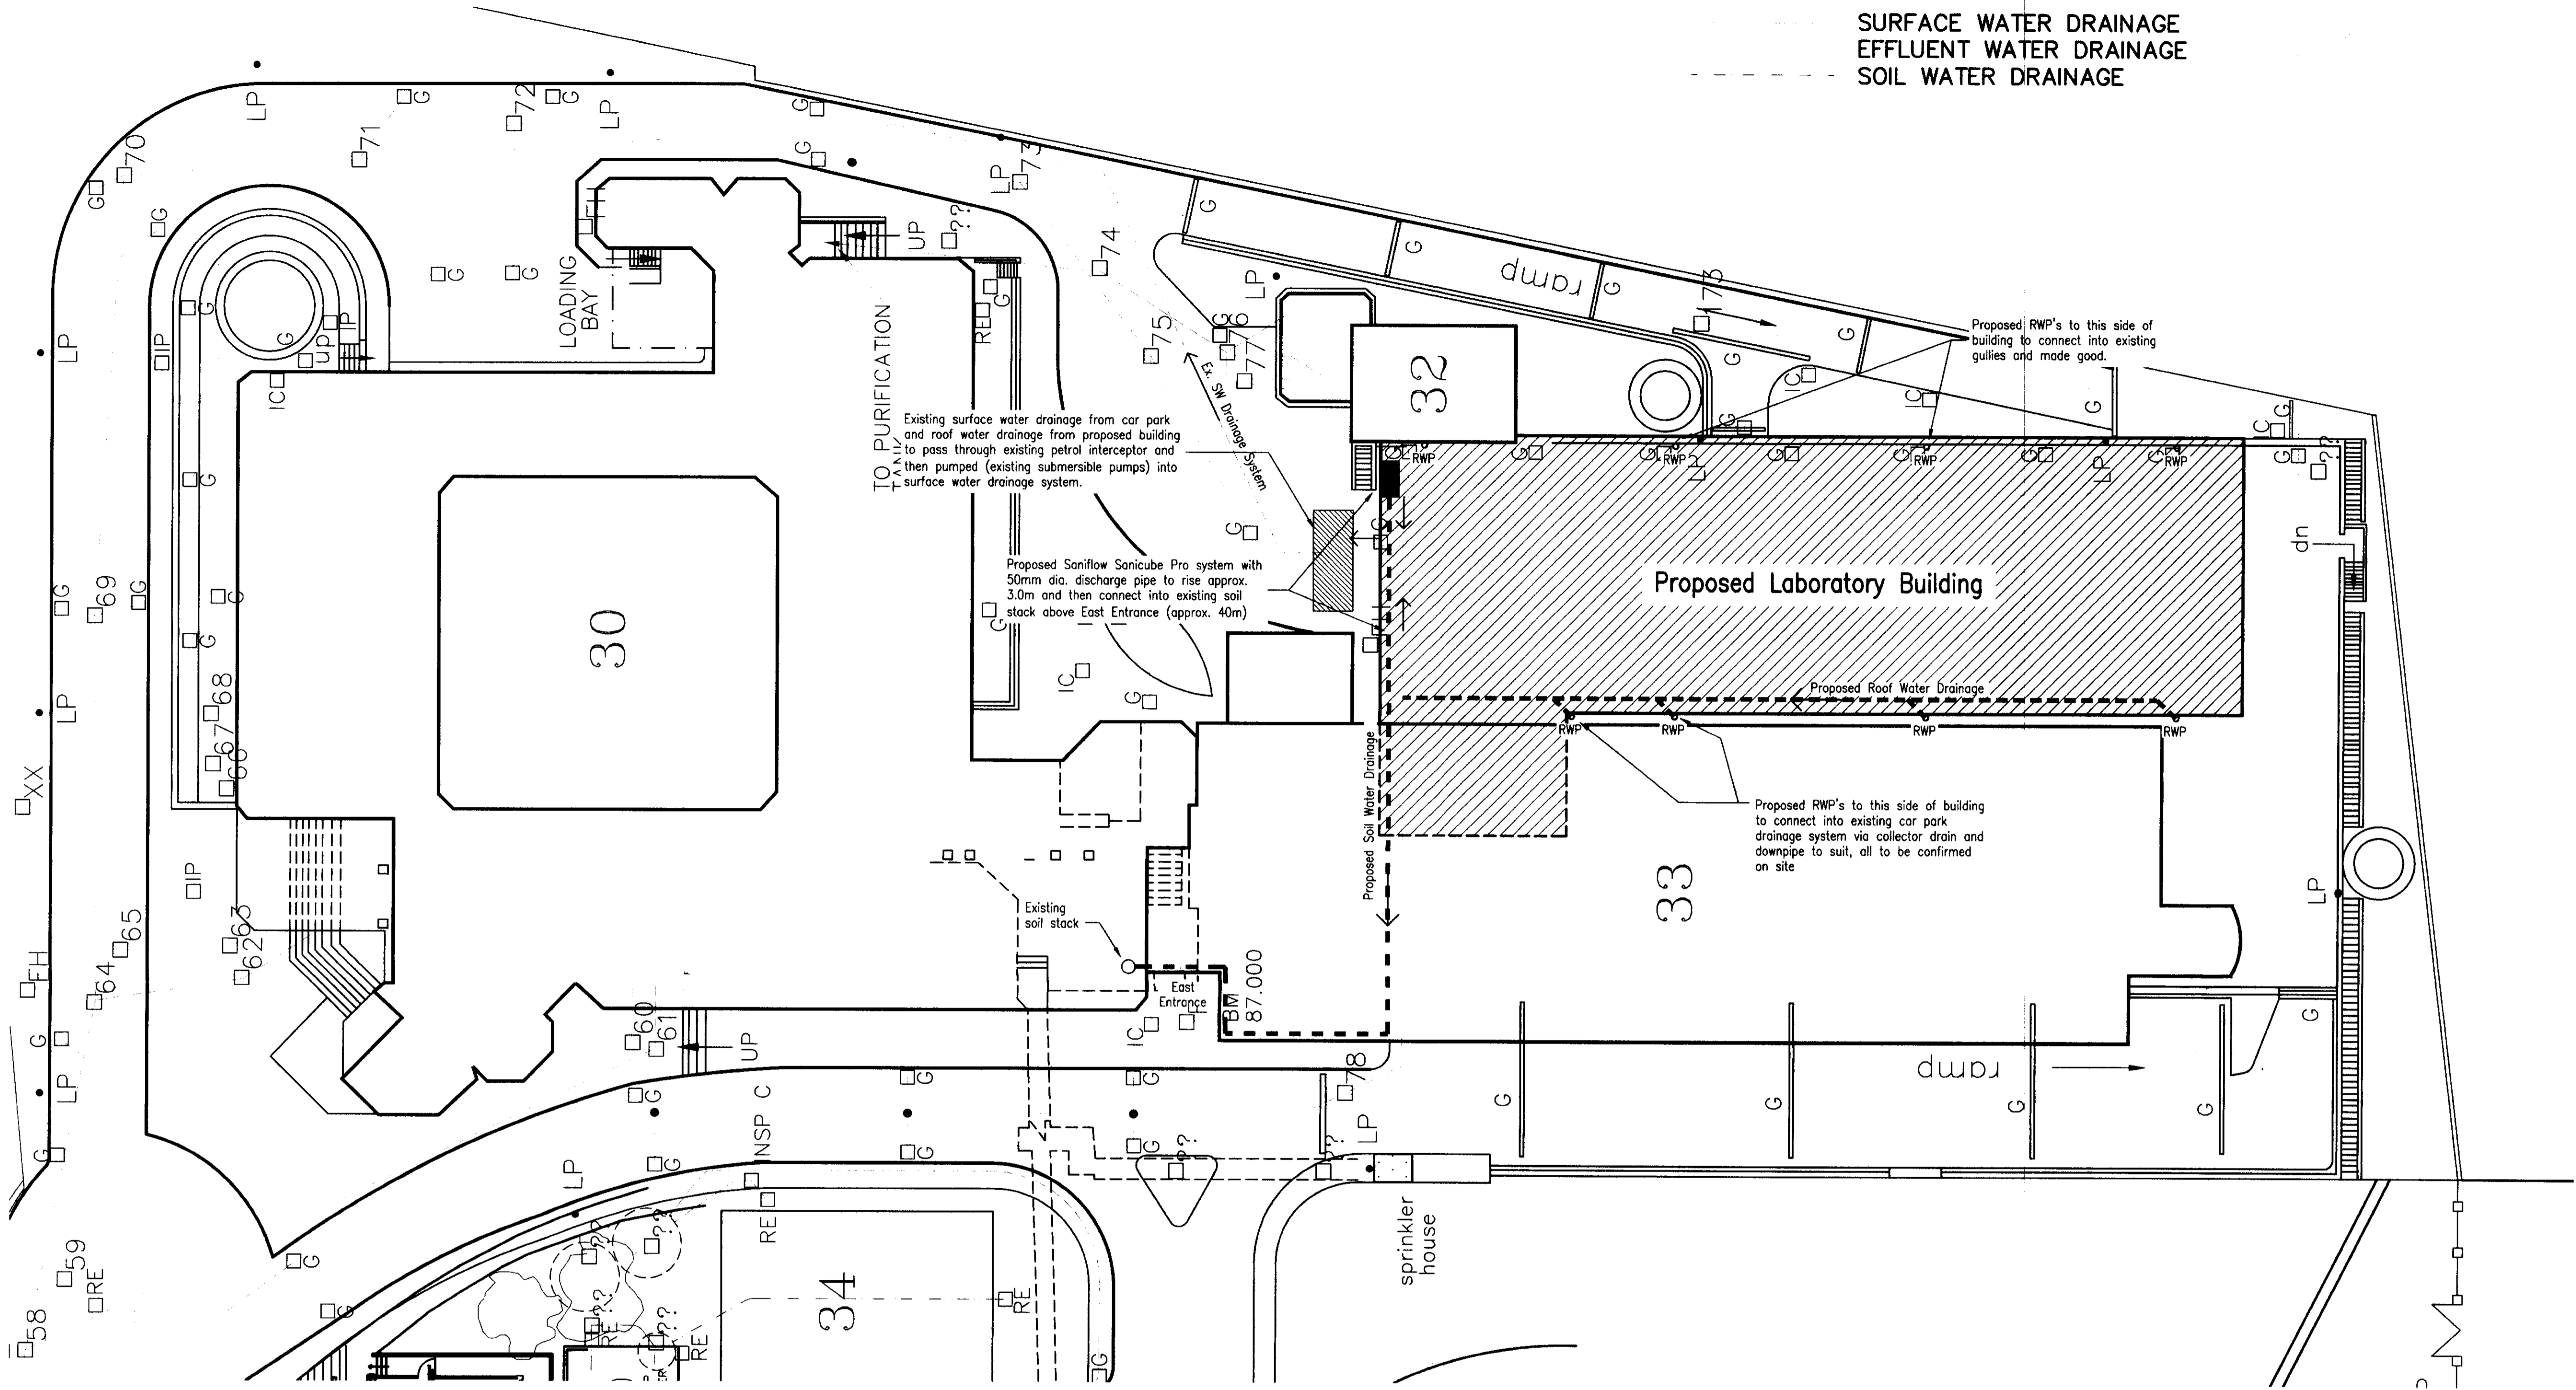

REV. DATE AMENDMENT B

CLIENT

**Merit Process Engineering**

PROJECT  
**Laboratory Project  
 Biopark, Hertfordshire  
 Welwyn Garden City**

DRAWING TITLE

**Drainage Layout**



**NORDER**

*Structural and Civil Engineering Consultants  
 Beech Lawn, Green Lane, Belper, Derby DE56 1B  
 Tel: 01773 824414 Fax: 01773 823305  
 e-mail: enquiries@norder.co.uk*

WELWYN HATFIELD  
 PLANNING  
 OFFICE COPY  
 19 MAY 2010  
 No: 2010/1045

SCALE 1:200 SHEET SIZE A1

DATE May 2010 DRAWN S.J.Briggs CHECKED RJK

JOB No. 6269 DRAWING No. 09