

EXISTING 1No. TX13 CABINET (POSITION '1' - SHOWN DASHED) TO BE REPLACED WITH NEW PTC IN SAME FOOTPRINT.

PROVIDE NEW LOCALISED SECTION OF 300mm WIDE VERTICAL CABLE LADDER DROP TO FLOOR BEHIND NEW 3G FLEXI CABINET.


PROPOSED NAKED FLEXI-2 STACK COMPLETE WITH UCU (POSITION '2') COMPRISING:
6No. RF MODULES
8No. SYSTEM MODULES
2No. POWER MODULES
TO BE INSTALLED ON EXISTING BASE - ALL CABLING TO RISE ON NEW LOCALISED CABLE MANAGEMENT TO REAR. TO BE INSTALLED IN PLACE OF REMOVED ULTRASITE ONCE REMOVED DURING 2G UPGRADE.

EXISTING 1No. 2G ULTRASITE CABINET (POSITION '3' - SHOWN DASHED) TO BE REMOVED - PROPOSED FUTURE HUAWEI BTS3900A OUTDOOR CABINET (SHOWN DASHED) TO BE INSTALLED ON EXISTING BASE

PROVIDE NEW LOCALISED SECTION OF 300mm WIDE VERTICAL CABLE LADDER DROP TO FLOOR BEHIND NEW BTS3900A.

PROPOSED HUAWEI BTS3900A OUTDOOR CABINET (POSITION '4') TO BE INSTALLED ON EXISTING BASE

EXISTING EE DISTRIBUTION BOARD TO BE INTERNALLY UPGRADED AS FOLLOWS:
- FIT NEW 1No. C63 MCB IN EXISTING DISTRIBUTION BOARD FOR NEW AC SUPPLY TO PROPOSED PTC CABINET
- LABEL DISTRIBUTION BOARD MCB SCHEDULE ACCORDINGLY

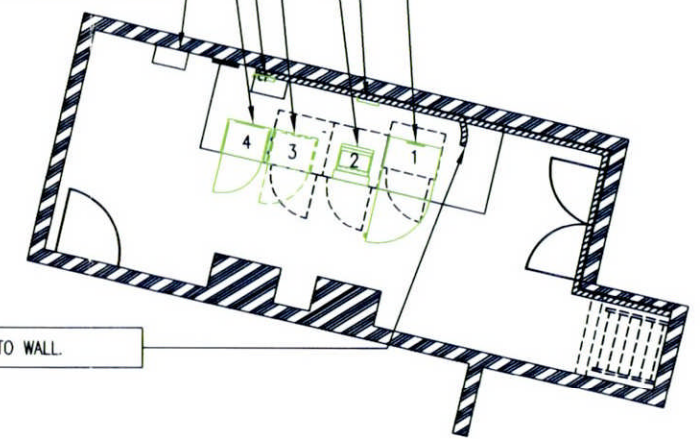

EXISTING VENT

EXISTING PLANT ROOM

PROPOSED EE CABINETS IN ROOM BELOW SEE DETAIL TO RIGHT

EXISTING CABLE TRAY TO BE CUT BACK TO WALL.

ALL EXISTING / REDUNDANT POSTS / LP & CABLE MANAGEMENT TO BE REMOVED UPON COMPLETION.

SIGNAGE TO BE BROUGHT IN LINE WITH MOST CURRENT OUK/EE SAFETY SIGNAGE SPECIFICATION (SPEC.201)

SITE PLAN
SCALE 1:100

DESIGN NOTE:	ICNIRP DETAILS (IN ACCORDANCE WITH EE DOC. SPEC2315 VERSION 1.0) DESIGN CLASSIFICATION OCCUPATIONAL NOTES	COLOUR CHART (REPRESENTS PROPOSED WORK AND NOT THE ACTUAL COLOUR OF THE EQUIPMENT) BLACK — TEXT AND EXISTING BUILDINGS, STRUCTURES, MASTS TREES GREEN — PROPOSED INSTALLATION BLUE — ACCESS ROUTE RED — SITE DEMISE 0 1 2 3 4 5m LINEAR SCALE 1:100	SITE PLAN CAMPUS WEST THE CAMPUS WELWYN GARDEN CITY HERTFORDSHIRE AL8 6UB				 Everything Everywhere Ltd, Hatfield Business Park, Hatfield, Hertfordshire, AL10 9BW									
	OPCS TRACKING REFERENCES N/A AEW ANTENNA SWAP N/A EQP CABINET UPGRADE N/A DSH DISH INSTALL		<table border="1"><tr><td>REV</td><td>A</td><td>DESCRIPTION OF REVISION</td><td>BY</td><td>DATE</td></tr><tr><td></td><td></td><td>FIRST ISSUE FOR APPROVAL</td><td>MO</td><td>16.06.12</td></tr></table> SCALE: AS SHOWN WHEN PRINTED AT A3 DRAWN BY / DATE: MO 16.06.12 CHECKED BY / DATE: NR 16.06.12 APPROVED BY / DATE: NR 16.06.12 ALL DIMENSIONS IN mm UNLESS OTHERWISE STATED. THIS DRAWING TO BE READ IN CONJUNCTION WITH OTHER RELEVANT DRAWINGS.					REV	A	DESCRIPTION OF REVISION	BY	DATE			FIRST ISSUE FOR APPROVAL	MO
REV	A	DESCRIPTION OF REVISION	BY	DATE												
		FIRST ISSUE FOR APPROVAL	MO	16.06.12												