


UNITARY PANEL KEY:

- GE - GLASS END PANEL
- GD - GLASS WALL DOOR
- TD - TEST AREA DOOR
- OE - OPEN END FRAME
- SE - SOLID MDF END PANEL
- MSE - NEW METAL END PANEL
- CG - COUNTER GATE
- CE - COUNTER END PANEL
- IP - INSERT PANEL

NOTES FOR GENERAL CONTRACTOR

- FLOOR FINISH: EXISTING WOODEN FLOORING TO BE TAKEN UP AND REMOVED COMPLETELY. SUPPLY AND LAY MODULEO PERLATO FLOOR TILES THROUGHOUT SALES AREA.
- WALL FINISHES TO BE MADE GOOD AS NECESSARY AND LEAVE READY TO RECEIVE DECORATIONS THROUGHOUT SALES AREA.

NOTE :-
BLUE LINES INDICATES TO BE DEMOLISHED.

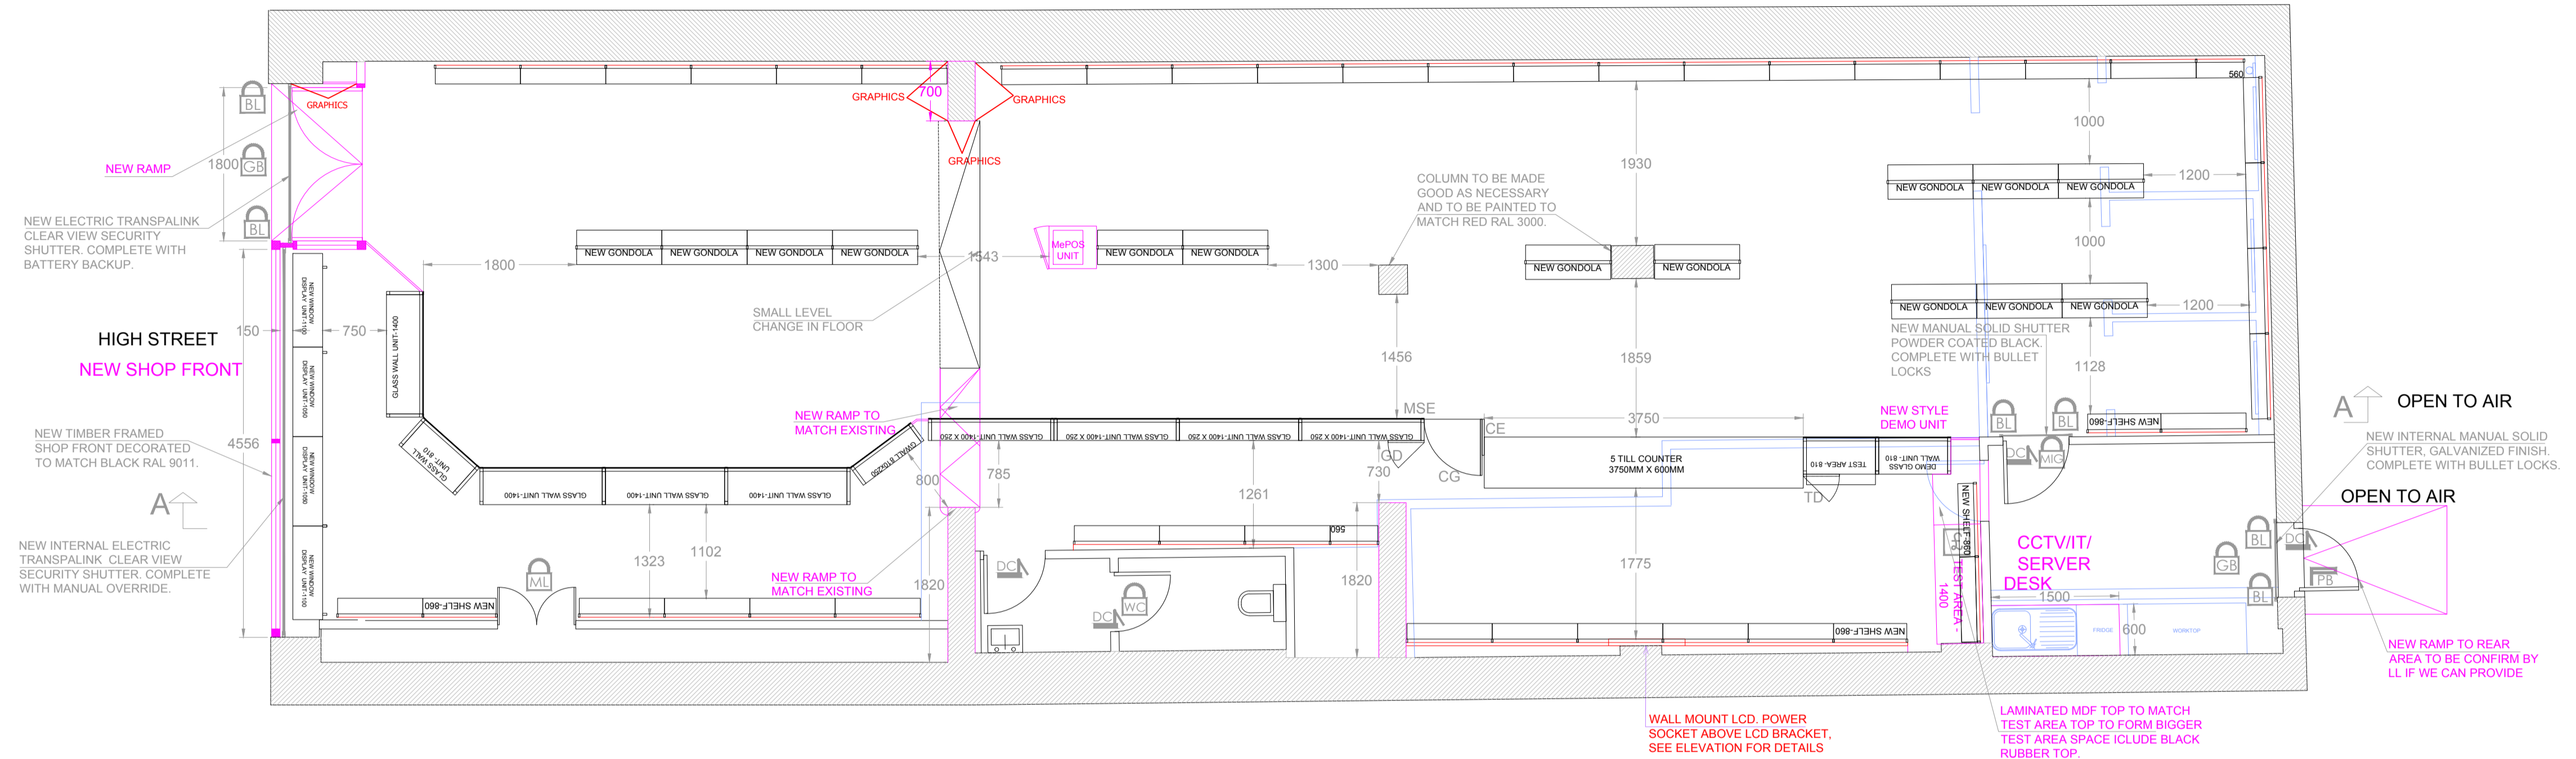

PROPOSED GROUND FLOOR PLAN
FLOOR AREA-146.00m²

AIR CONDITIONING KEY

- Heated Door Curtain
- Thermostat-Aircon
- Control Panel-Aircon
- Ceiling Mounted Heat Exchange Inverter Air Conditioning Cassette Unit
- External Condenser

FIRE PRECAUTIONS KEY

- Fire Alarm-Control Panel
- Fire Alarm-Break Glass Point
- Smoke Detector
- Fire Alarm bell/sounder
- EL Non-Maintained Emergency Surface Light Fitting
- E Emergency Escape Route Sign
- EXIT Final Fire Exit Sign
- A Extinguisher-Foam, 6 Litres
- C Extinguisher-CO2, 2 Kilograms
- SPRINKLER

LIGHTING KEY

- S = SURFACE FITTING
- Spotlight-7W-LED
- Pendant fitting, twin 42W PL
- Recessed 42W PL downlighter
- TS-Led 1500 1500mm T5 LED fittingsREF (CXL 2504 KZ)
- TS-Led 1200 1200mm T5 LED fittingsREF (CXL 4504 KZ)
- TS-Led 900 900mm T5 LED fittings
- TS-Led 600 600mm T5 LED fittings
- TS-Led 1500 1500mm T5 LED fittingsREF (CXL 5504 KZ)
- TS-Led 1200 1200mm T5 LED fittingsREF (CXL 4504 KZ)
- TS-Led 900 900mm T5 LED fittings
- TS-Led 600 600mm T5 LED fittings
- Integral LED Panel Back-lit 1200x600 Code -ALP1200600K4KCSWH 70W 4000K 6500lm
- Ansell Lightning (Infinite LED Recessed Panel 40W LED Silver Grey) Code -AIRMLED/CW Description - 40W 40W - Cool White

ELECTRICAL KEY

- Electric Meter
- Consumer Unit/Fuse box
- RCD-Residual Current Device
- Unswitched Fused Spur
- Single Outlet
- Double Outlet
- Double Outlet Clean Supply Counter/Server
- Last Man Out switch
- Electric Extractor Fan
- Electric Water Heater
- Incoming Data Point
- Double Data Point
- Speaker-arrow showing direction
- Hi-Fi & Amplifier

SECURITY KEY

- Intruder Alarm Key/Fob Panel
- Intruder Alarm-Internal bell/sounder
- Intruder Alarm-External bell/sounder
- Ground Bolt
- Bullet Lock
- Digital lock
- Magi lock
- Mortise Lock
- WC Lock
- Panic Bar
- Overhead Door Closer
- Safe
- CCTV Flat Screen Door Monitor
- CCTV camera-arrow showing direction
- Smoke Bandit

UTILITIES KEY

- Gas Meter
- Water Meter



Scale Bar 1:50

CeX Ltd
11 Northburgh Street, London EC1V OAH
e-mail: cexdesign@webuy.com
Contractors must verify all dimensions on site before commencing work. Only work to given dimensions. The copyright of this drawing is reserved and the drawing must not be disclosed without the authority of CeX Ltd.

Notes:
BUILT SET

Revision

Info	Existing	Proposed
FLOOR AREAS:	EXISTING GROUND FLOOR - 162.00m ²	RETAIL GROUND FLOOR - 146.00m ²
SUSPENDED CEILING AREA:	GROUND FLOOR - 00m ²	GROUND FLOOR - 00m ²
SLAT WALL PERIMETER LENGTH:	GROUND FLOOR - 00m ²	GROUND FLOOR - 00m ²
VINYL FLOOR AREA:	GROUND FLOOR - 00m ²	GROUND FLOOR - 00m ²

Store Name:-	CeX- Welwyn Garden City AL8 6AP UK			
Address:-	41 Howardsgate, Welwyn Garden City, Hertfordshire AL8 6AP			
Drawing Title:-	PROPOSED GROUND FLOOR PLAN			
Scale:-	Drawn:-	Date:-	Drawing No:-	Revision:-
1:50 @A1	SA	16-03-03	CEX-WEL-04	-