


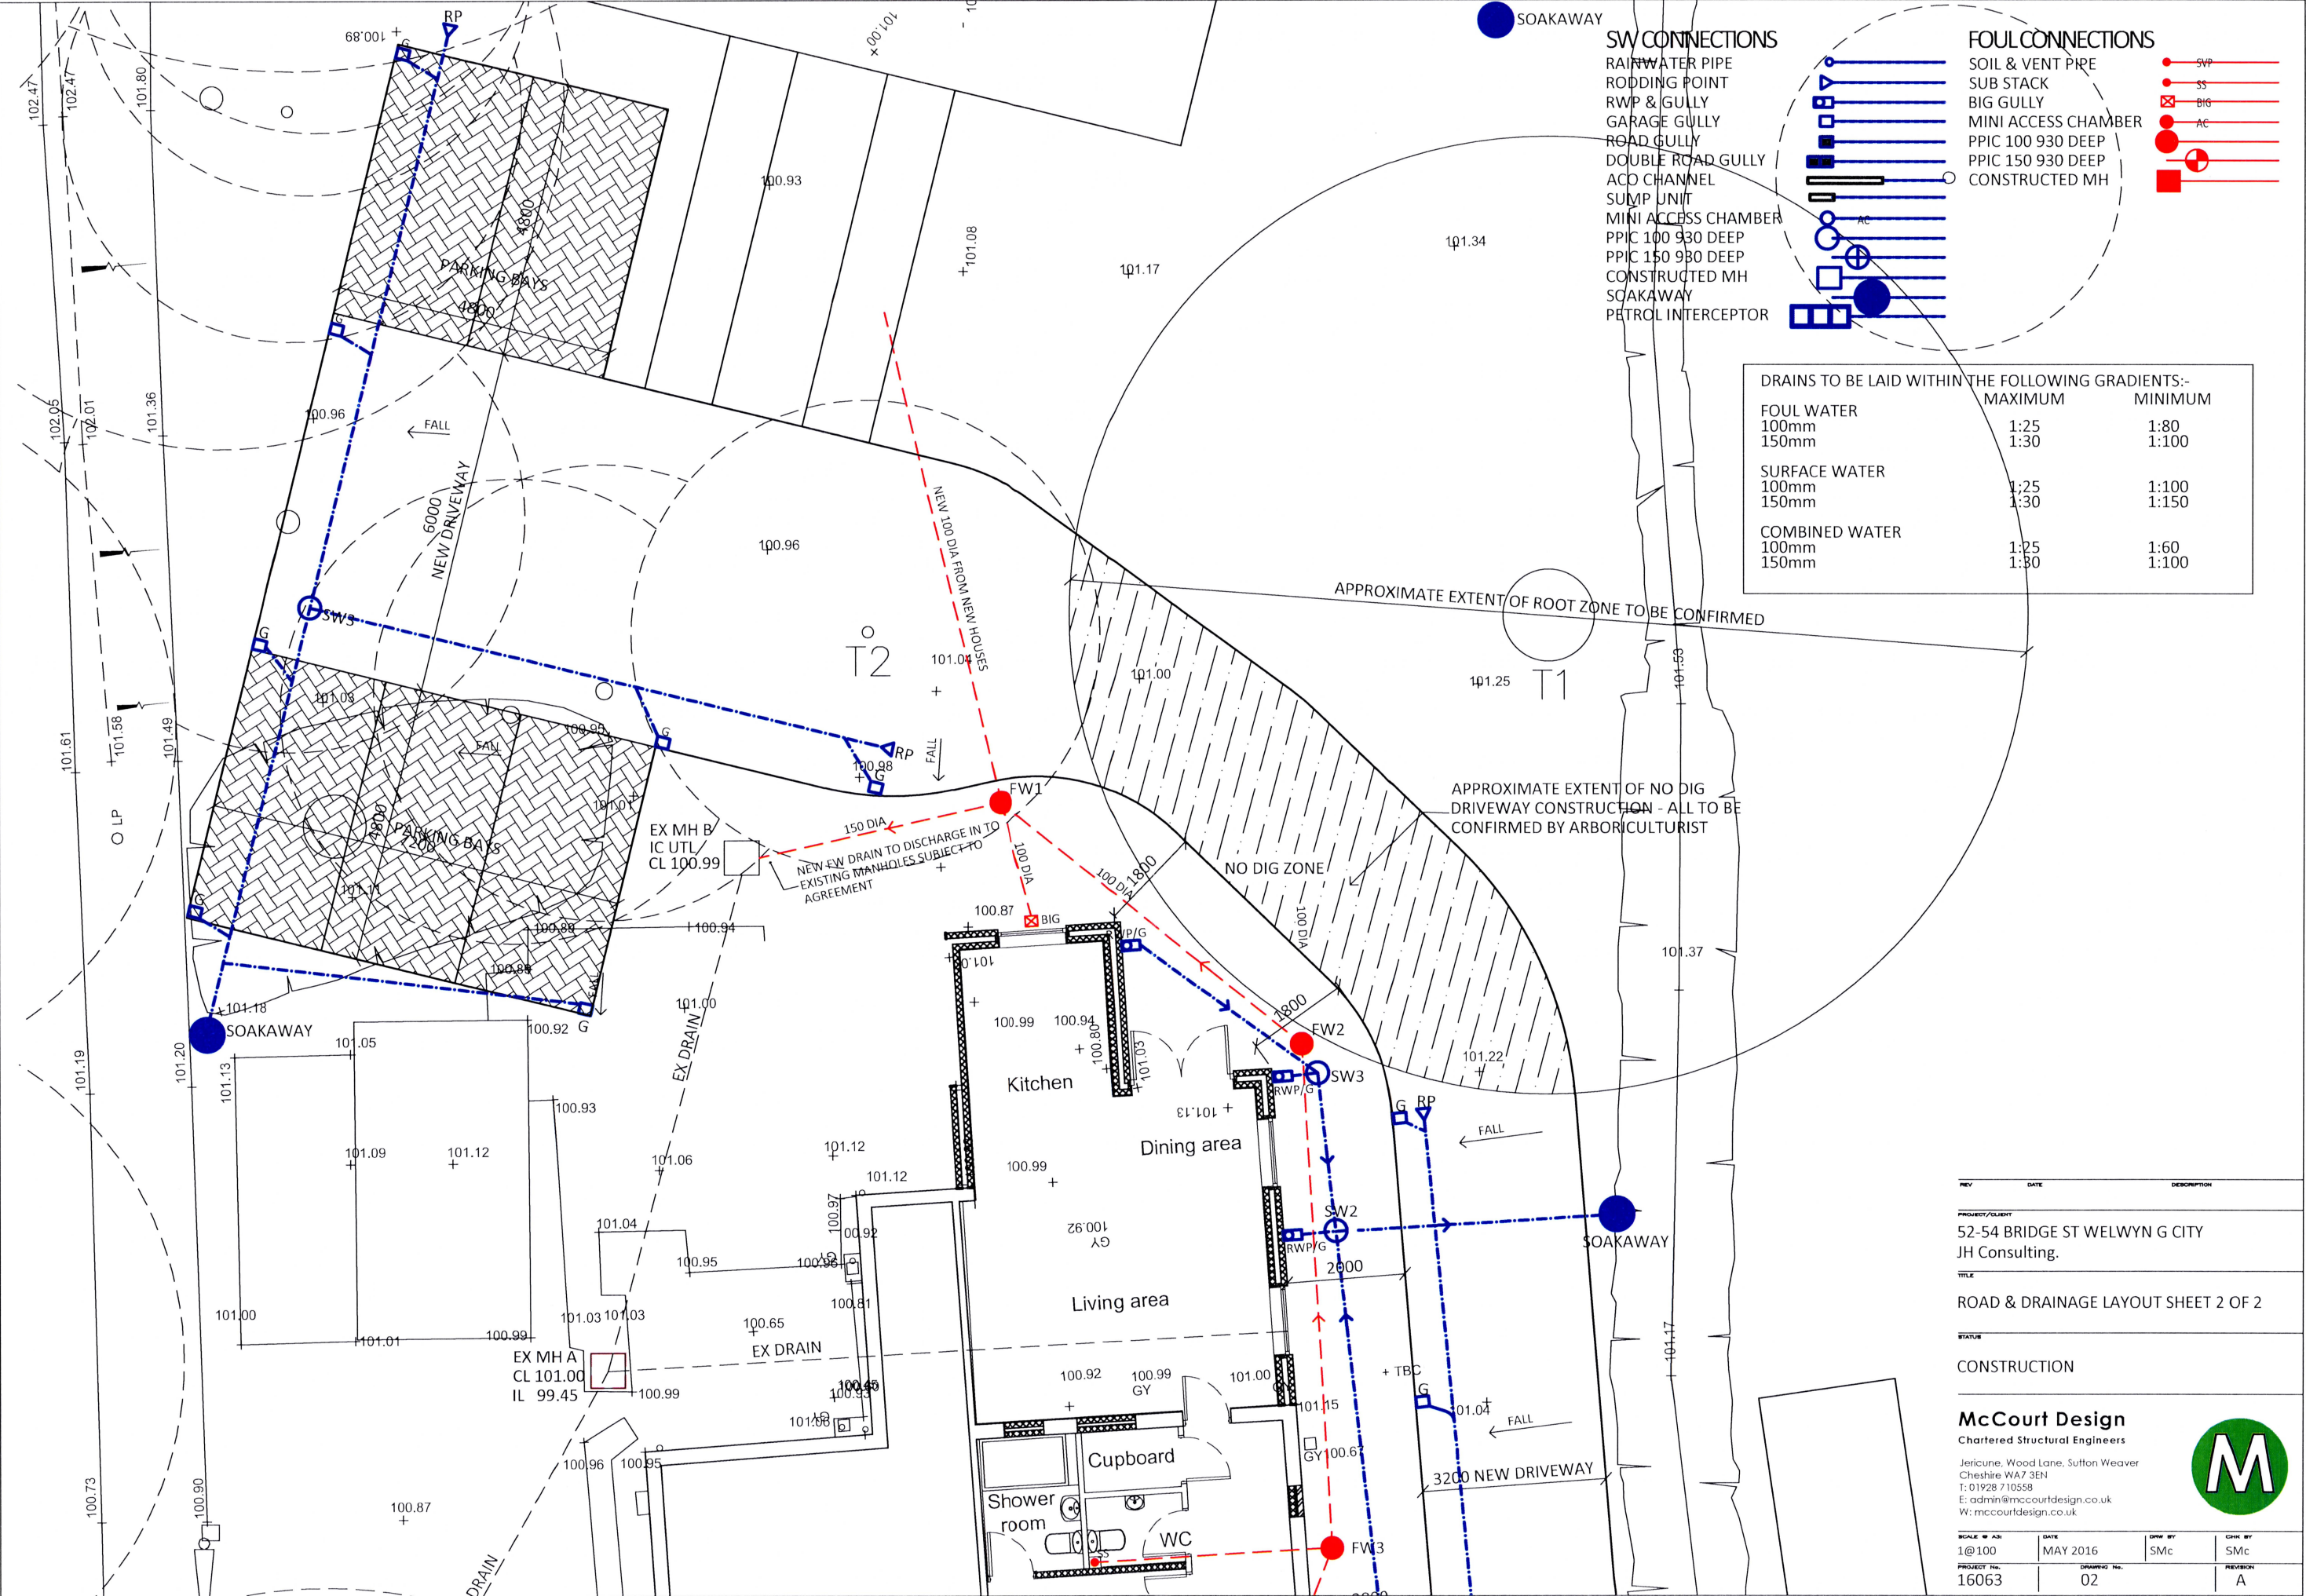

REV	DATE	DESCRIPTION	
PROJECT/CLIENT			
52-54 BRIDGE ST WELWYN G CITY			
JH Consulting.			
TITLE			
ROAD & DRAINAGE LAYOUT SHEET 2 OF 2			
STATUS			
CONSTRUCTION			
McCourt Design			
Chartered Structural Engineers			
Jericune, Wood Lane, Sutton Weaver			
Cheshire WA7 3EN			
T: 01928 710558			
E: admin@mccourtdesign.co.uk			
W: mccourtdesign.co.uk			
SCALE: AS SHOWN	DATE	DRAWN BY	CHECKED BY
1:100	MAY 2016	SMc	SMc
PROJECT No:	DRAWING No:	REVISION	
16063	02	A	