
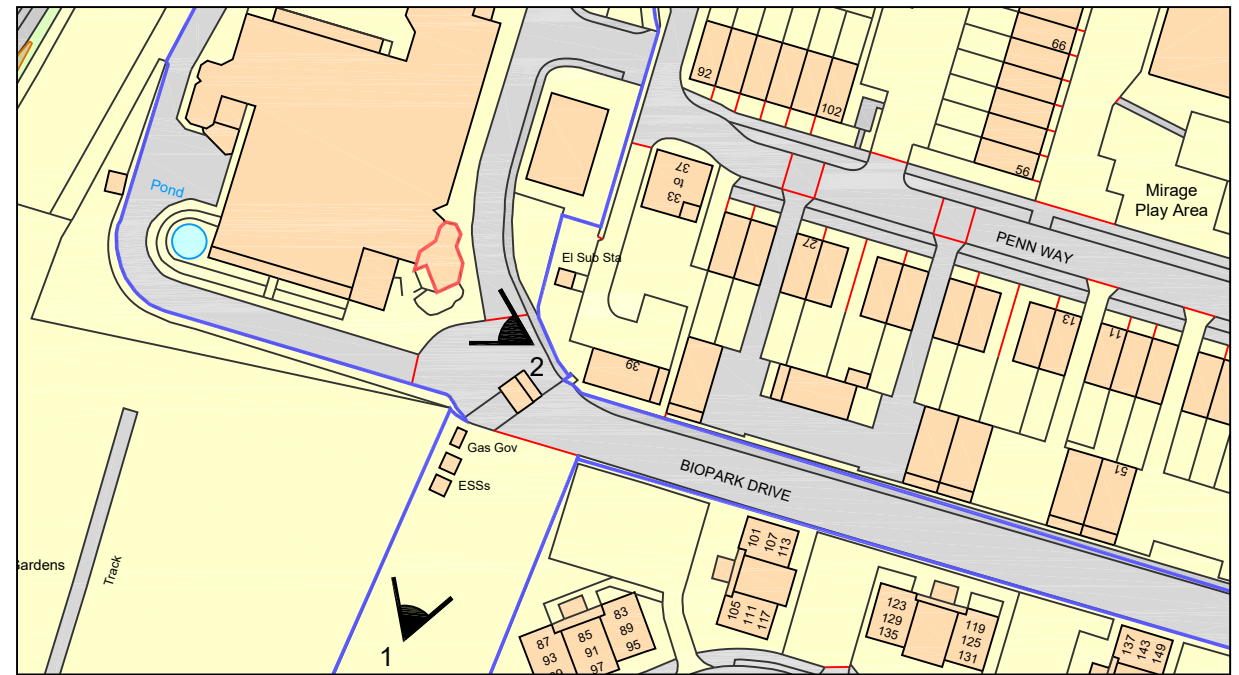


0 1m 5m 10m

Scale 1:100@A3

Revision	Description

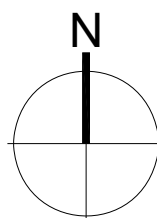

View 1



View 2



project name: Hatfield, BioPark Antenna Installation  
drawing reference: Site Plan  
date: MAY 2017  
sheet: drawn: IDMR  
scale: 1-100@A3 checked: PWL  
job number: M9424  
drawing number: APL002 revision: -  
status:  
cad ref: Antenna.dwg

Use figured dimensions only. All levels and dimensions to be checked on site. This drawing is to be read in conjunction with all other relevant drawings and specifications. Hunters is a trading name of Hunter & Partners Limited. © Hunter & Partners Limited. All rights reserved.

**hunters**

Space One Beadon Road  
London W6 0EA

T 020 8237 8200  
F 020 8741 2814  
mail@hunters.co.uk

www.hunters.co.uk