



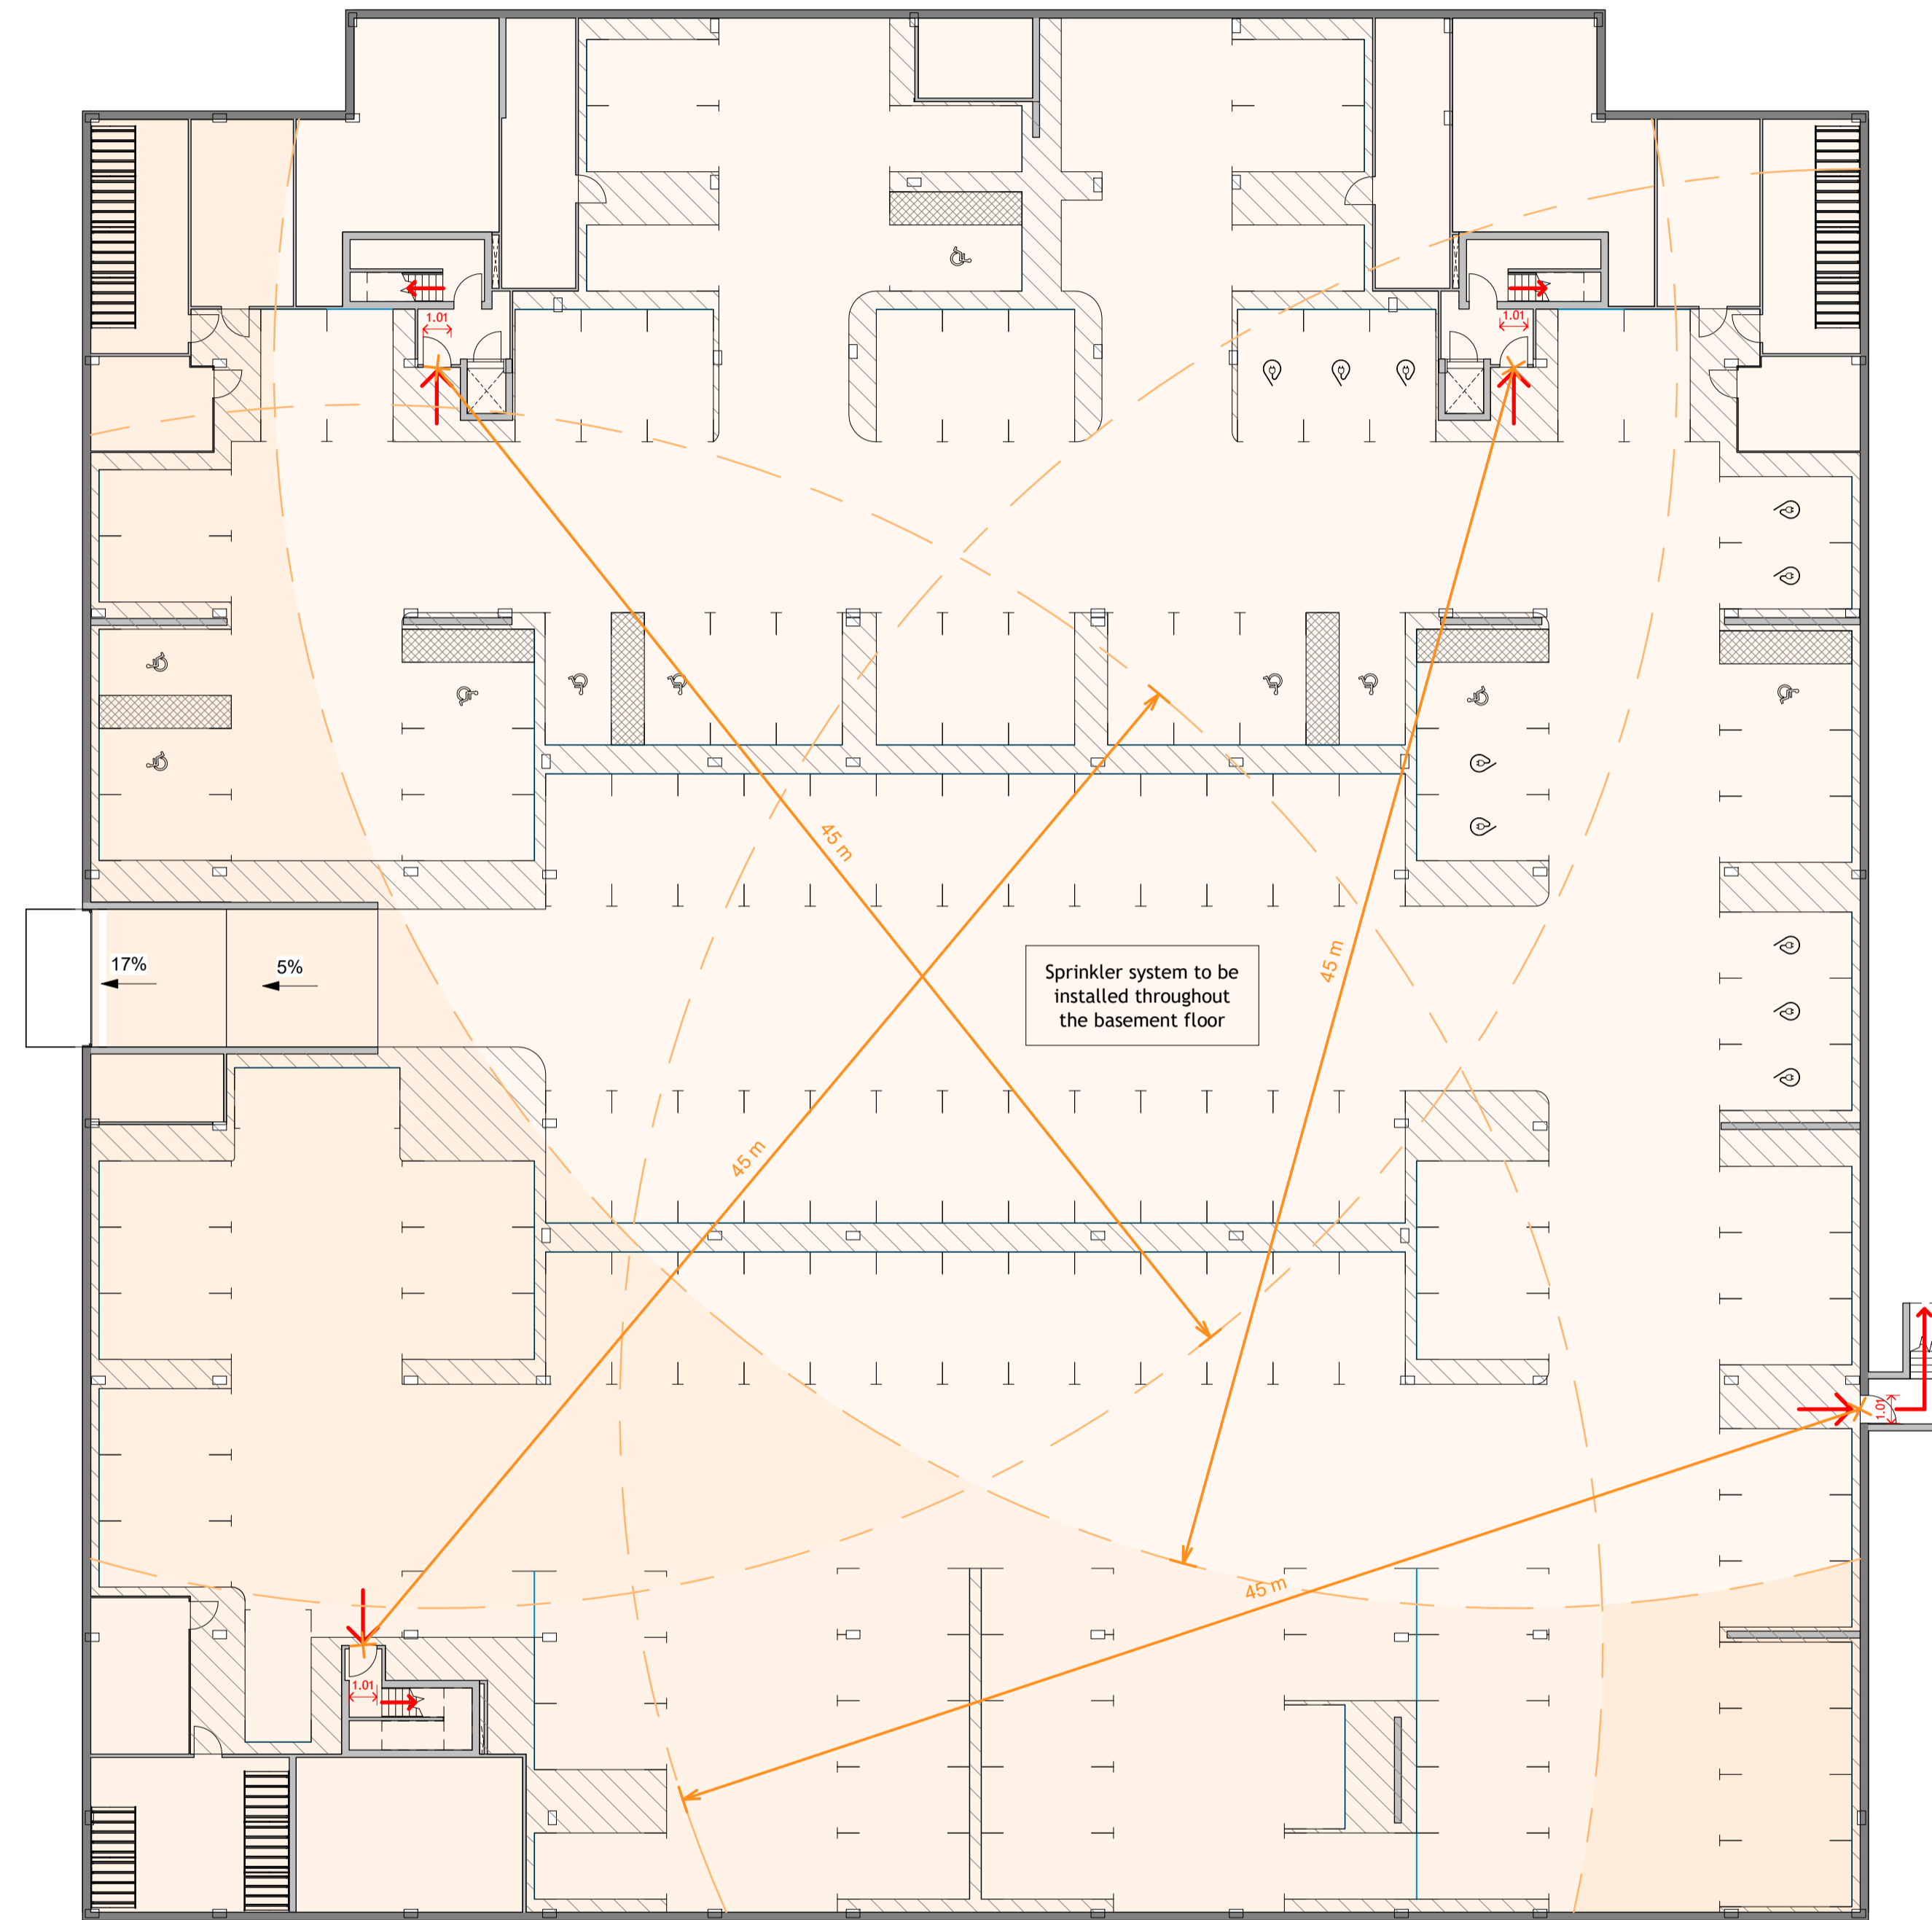


- FIRE SAFETY PLAN KEY**
-  DISEABLE PARKING SPACE
 -  ELECTRIC CAR CHARGING POINT
 -  ESCAPE ROUTE
 -  MAX. TRAVEL DISTANCES

Note: This drawing is indicative only, and should be read in conjunction with Fire engineer's notes.



Basement Floor Plan
1 : 200

P1 Issued for Planning		21.11.19
Revision	Amendment	Date
JP	JD	JD
Drawn by	Reviewed by	Approved by
60193	NOV '19	1 : 200 @ A1
MCB Number	Date Created	Scale @ A1

McBains

McBains Ltd
5th Fl. 26 Finsbury Square London EC2A 1DS
+44 (0)20 7786 7900 mcbains.co.uk

Client
Hightown Housing Association

Project
29 Broadwater Road
Welwyn Garden City

Drawing Title
Fire Safety
Basement Floor Plan

ARCHITECTURE

Drawing / Document Reference						Status
BRW01	MCB	ZZ	B1	DR	A	0308
Project No	Originator	Zone	Level	Type	Discipline	Number
						D5 - P1
						Suitability Revision

